


NOTE:
 COMPLETE SYSTEM OF SPRINKLERS IN
 ATTIC AND THIRD FLOOR TO BE A DRY
 TYPE SYSTEM. ALL SPRINKLER HEADS
 LOCATED IN ATTIC SHALL BE EXPOSED
 (TYP.) SEE SPECS FOR FURTHER DETAILS.
 INSTALL SPRINKLER SYSTEM PER LOCAL
 STATE & NFPA CODES. (NFPA 13R)

REFER TO FIRE
 PROTECTION RISER
 FOR DETAILS.

ATTIC LEVEL FLOOR PLAN

SCALE: 1/8" = 1'-0"

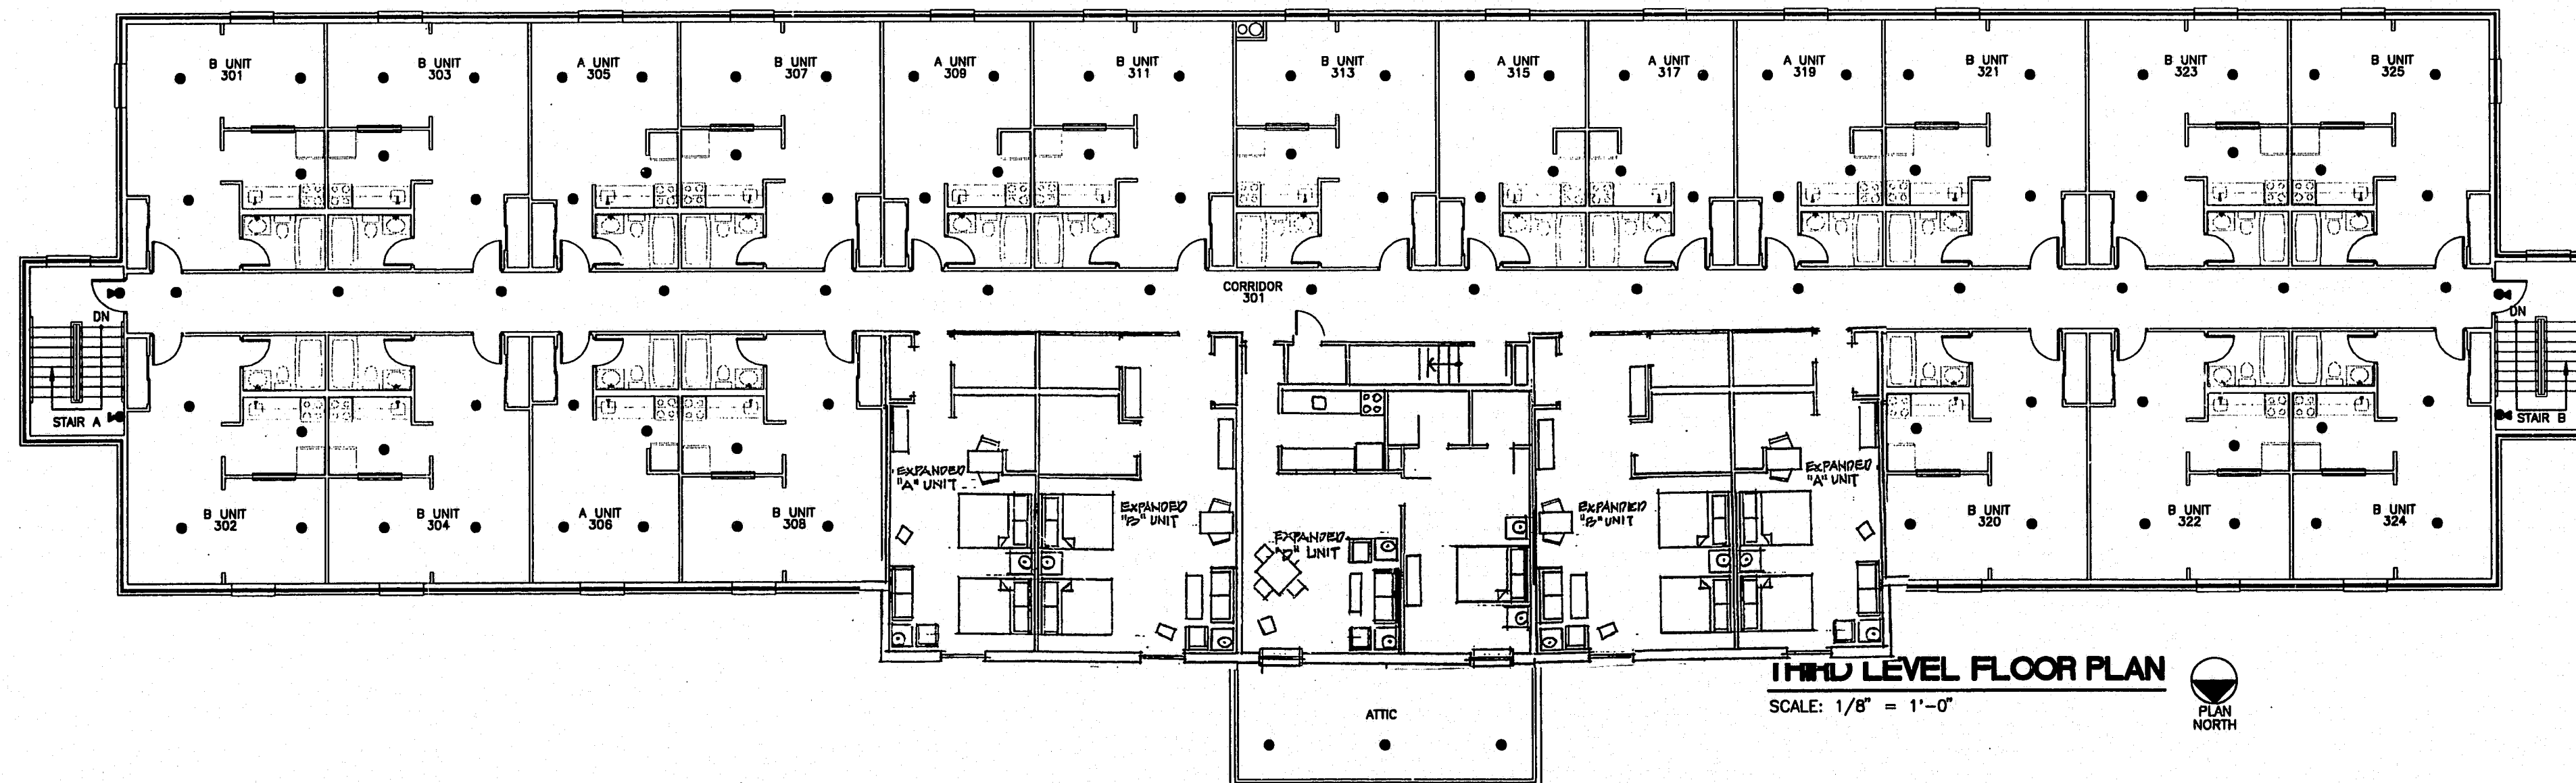


THIRD LEVEL FLOOR PLAN

SCALE: 1/8" = 1'-0"



Studio Plus of America, Inc. hereby reserves its common law copyright and other property rights in these plans, ideas and designs. These ideas, designs and plans are not to be reproduced, changed or copied in any form or manner whatsoever, nor are they to be assigned, transferred, licensed, or otherwise used without the written permission from Studio Plus of America, Inc. Written permission on these drawings shall have precedence over scale dimensions. Contractor shall verify and be responsible for all conditions and dimensions and be responsible for any conditions not noted in writing of any variation from the dimensions, conditions and specifications shown by these drawings.

STUDIO PLUS at UNIVERSITY PLACE, INC.
 MCCULLOUGH DRIVE
 CHARLOTTE, NORTH CAROLINA

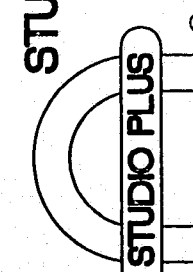

TRU
 ARCHITECTS

THOMAS ROOF INC. ARCHITECTS
 721 EMERSON ROAD Suite 200
 W. Lenoir, Vermont 05441 914-888-2339
 Fax: 988-5332

DATE: 6-22-95

REVISIONS

DWG. BY SPC

PROJECT NO. 95056/95109

SHEET NO.

FP-2