



FreemanWhite


Western Wake Medical Center

Parking Garage

Cary, NC

THIRD LEVEL FLOOR PLAN - LIGHTING

project number 1541941
date Oct 2, 00

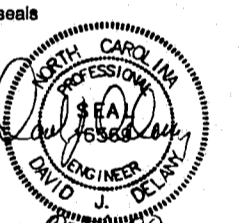

FINAL DESIGN
NOT RELEASED FOR CONSTRUCTION

© 2000 by FreemanWhite, Inc.

drawn by PAD
checked by DJD

revisions


cpr number
date

includes sheets

THIS DRAWING REFLECTS ALL CHANGES PROPERLY MADE ON THIS SHEET. ANY OTHER CHANGES MADE MUST BE IN ACCORDANCE WITH THE CONTRACT BEFORE. NO OTHER CHANGES SHALL BE SPECIFICALLY PERMITTED BY THE OWNER.

sheet number

E2.1

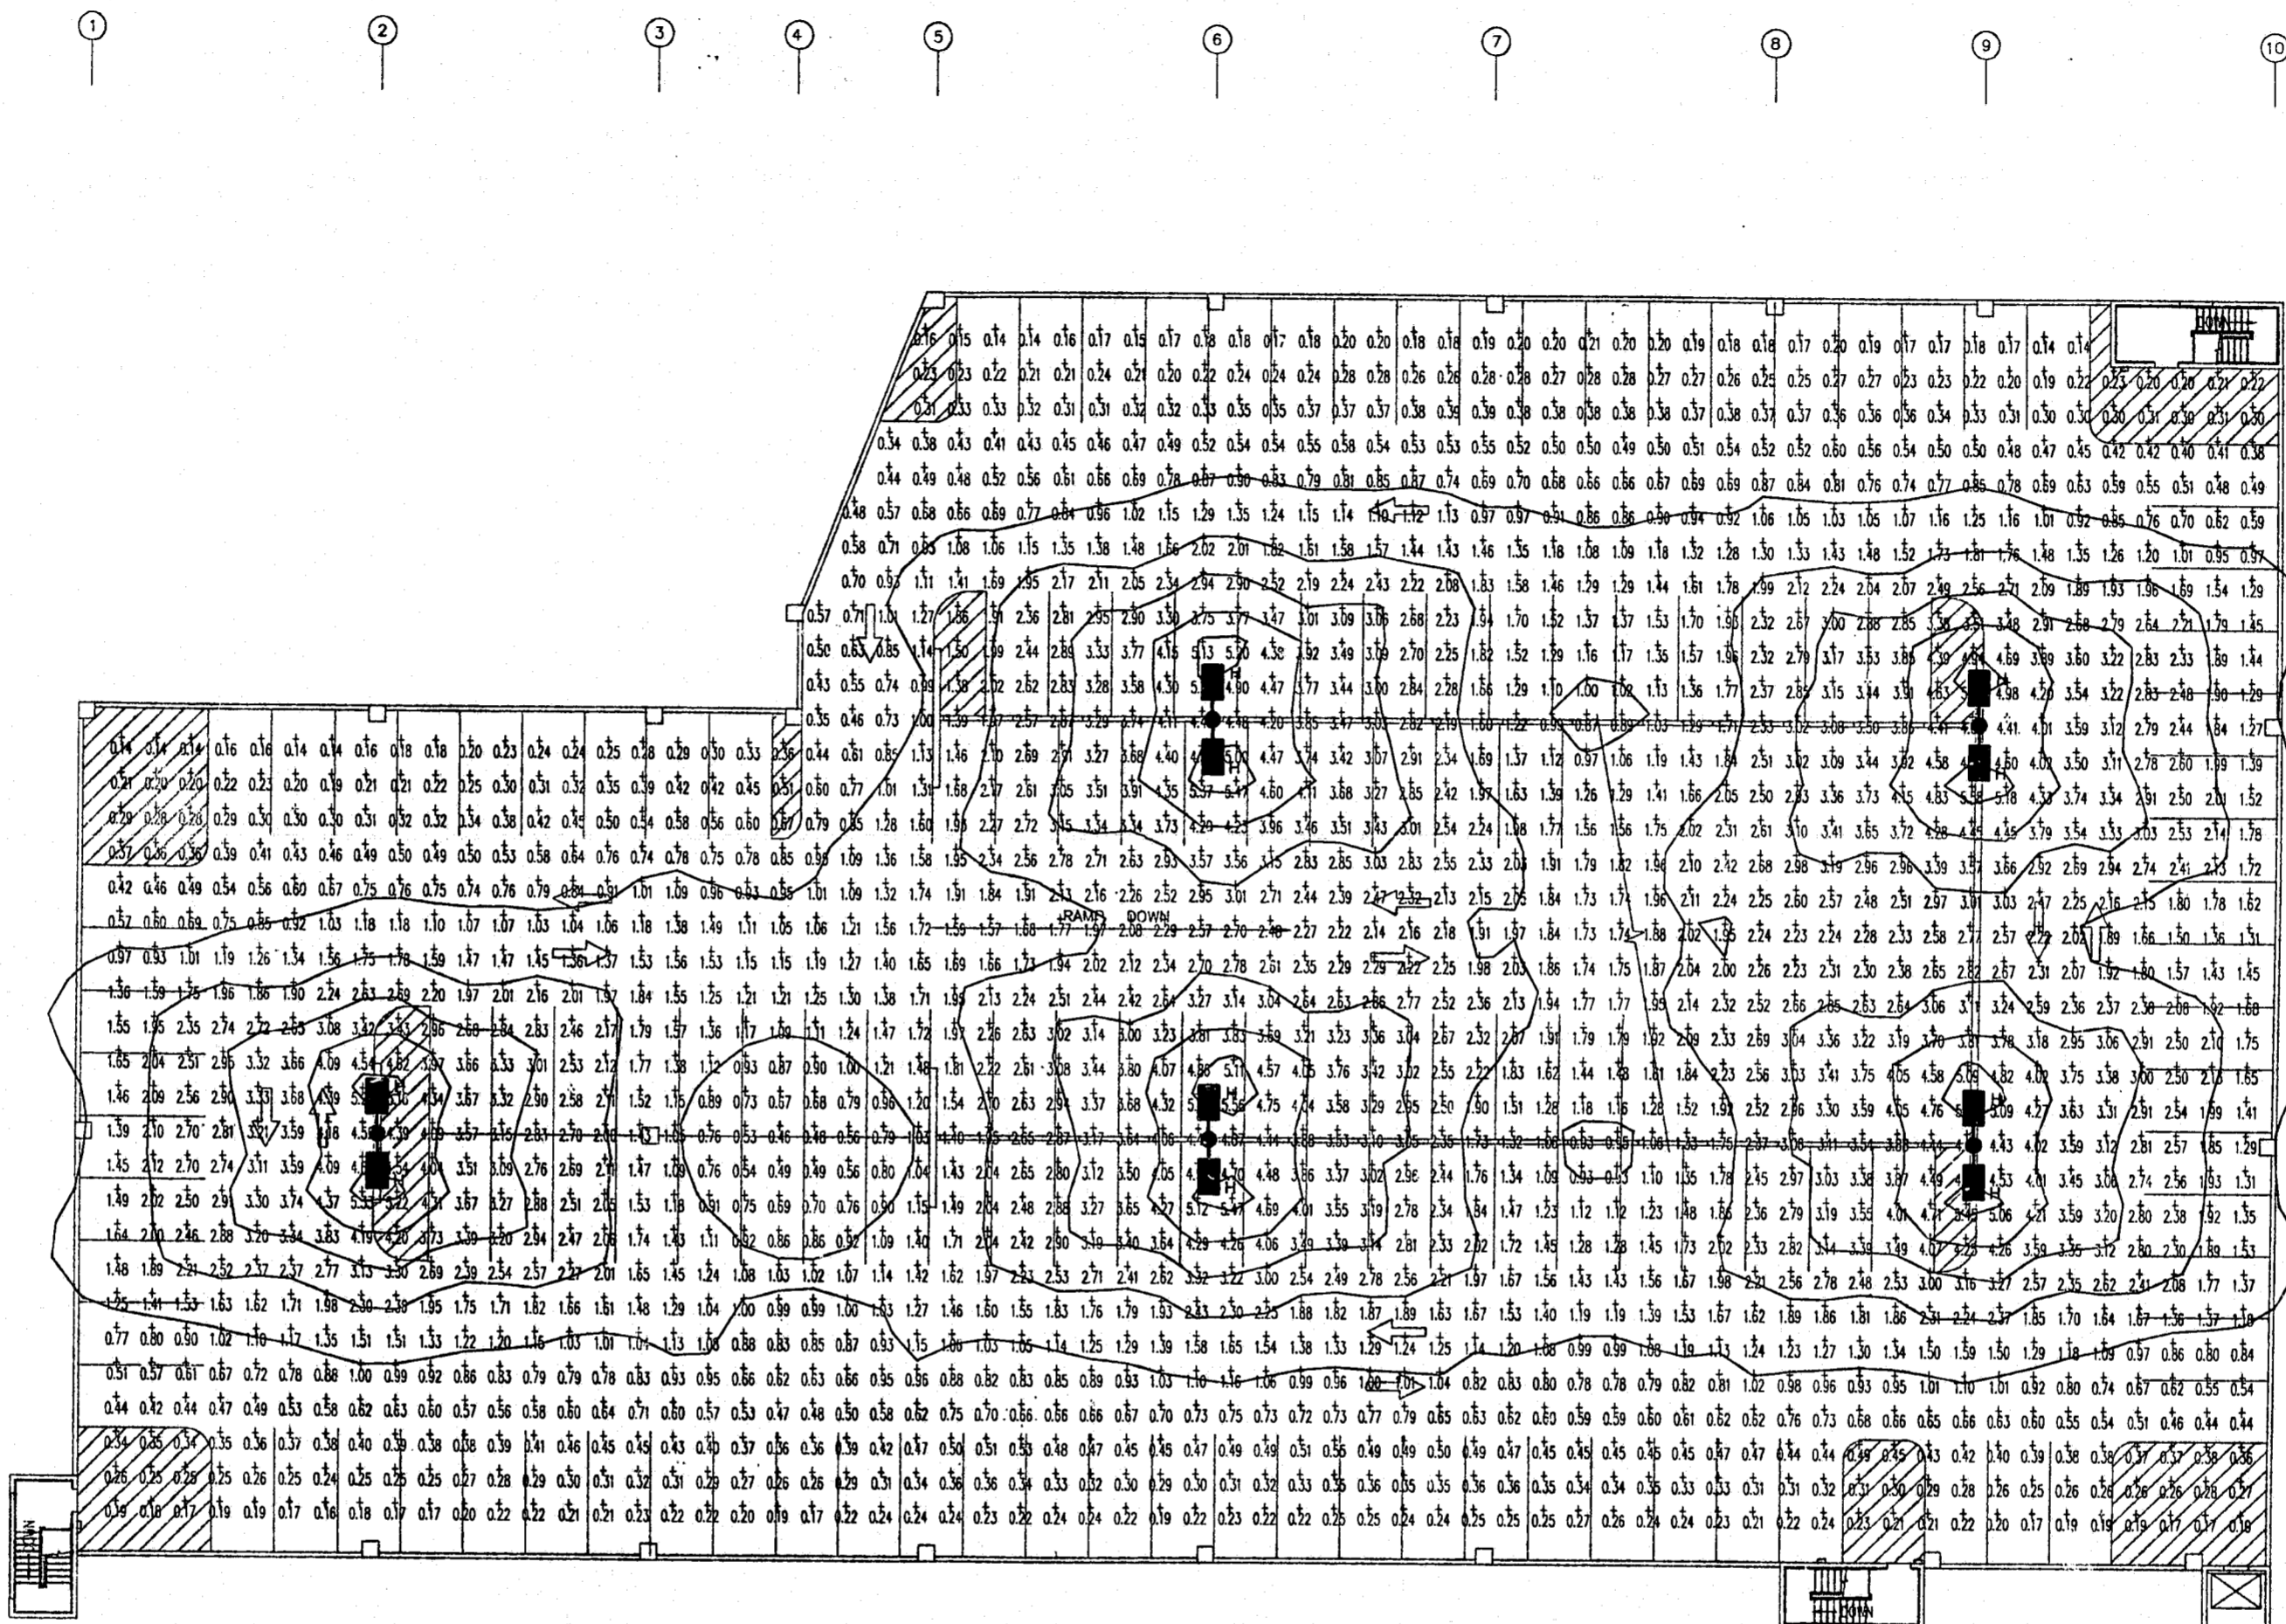

1 THIRD LEVEL FLOOR PLAN - LIGHTING
E2.1 SCALE: 1/16"=1'-0"

- NOTE:
- 1. ALL FIXTURES ON THIS SHEET ARE TYPE 'H'.
 - 2. TYPE 'H' FIXTURE IS 250W MH CUT-OFF TYPE SHOE BOX FIXTURE ON 30' ALUM. POLE.

DSAtlantic

160 OAK PLAZA BOULEVARD • SUITE 600 • WINSTON-SALEM, NC 27103
538-799-7400 • FAX 538-799-7900

CHARLOTTE, NC • COLUMBIA, SC • MACON, GA • NASHVILLE, TN
RICHMOND, NC • RICHMOND, VA • WINSTON-SALEM, NC

G:\MCC\055\ELC\B33E2-01.DWG