



HagerSmith
Design PA

Architecture
Landscape Architecture
Planning
Interior Design

PO Box 1308
300 South Dawson Street
Raleigh, North Carolina 27602
Fax: 919.828.4050

08.01.5547 © Copyright 1994

Associates / Consultants

STRUCTURAL ENGINEER

Name
Address
City / State / Zip
Phone: 919.000.0000

MECHANICAL / ELECTRICAL
ENGINEER

Name
Address
City / State / Zip
Phone: 919.000.0000

Notes

Project 12-400

Kildaro Plaza
Cary, North Carolina

NationsBank


Program Issues			
Submittal	Date	Level	Approved
PRE-DESIGN PHASE	04/28/94		
DESIGN SET	04/28/94		

Drawing Title: WALL SECTION & DETAILS

Revision	Number	Description	Date

Drawn by: DRS, BKA, HLD
Checked by: BSB, CMH
Date issued: 5/31/94

A-7
1 of 8

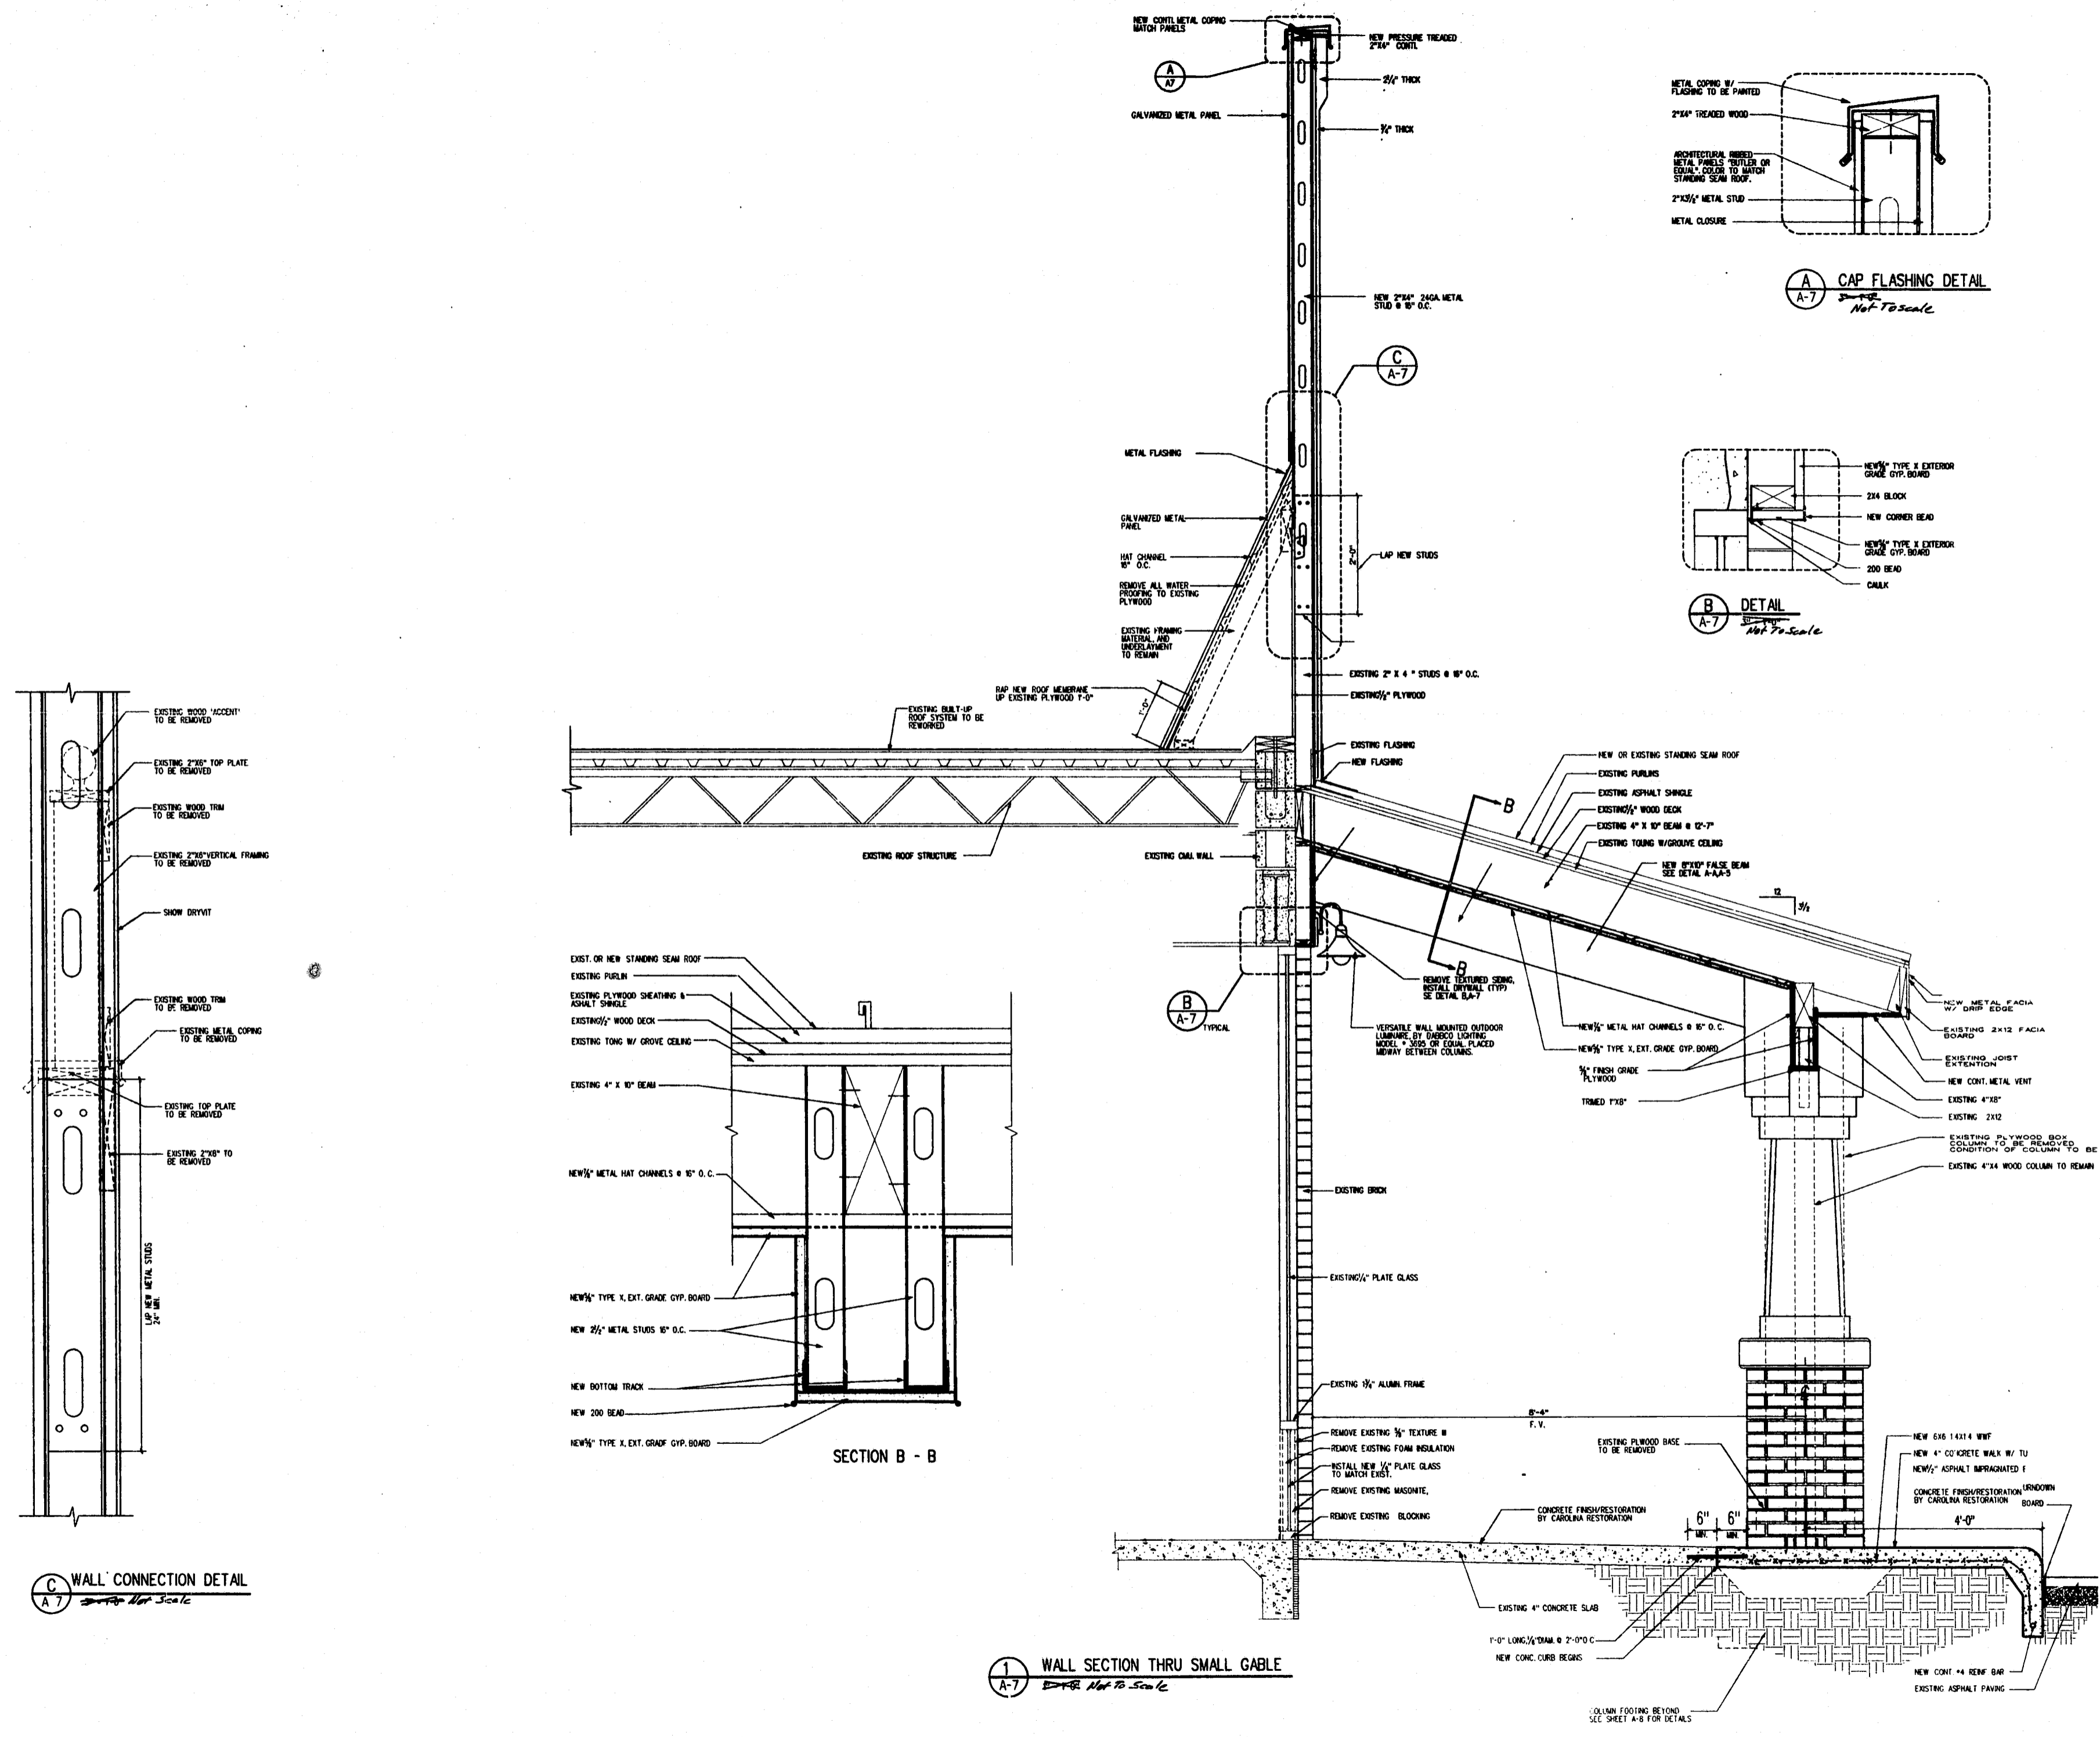

C WALL CONNECTION DETAIL
A-7 Not To Scale

1 WALL SECTION THRU SMALL GABLE
A-7 Not To Scale