



HagerSmith
Design PA

Architecture
Landscape Architecture
Planning
Interior Design

PO Box 1308
300 South Dawson Street
Raleigh, North Carolina 27602
Fax: 919.28.4050

93.02.5547 © Copyright 1994

Scale

Associates / Consultants

STRUCTURAL ENGINEER

Name
Address
City / State / Zip
Phone: 919.000.0000

MECHANICAL / ELECTRICAL ENGINEER

Name
Address
City / State / Zip
Phone: 919.000.0000


Notes

Project: 12-450


Kildere Plaza
Cary, North Carolina

Client

NationsBank

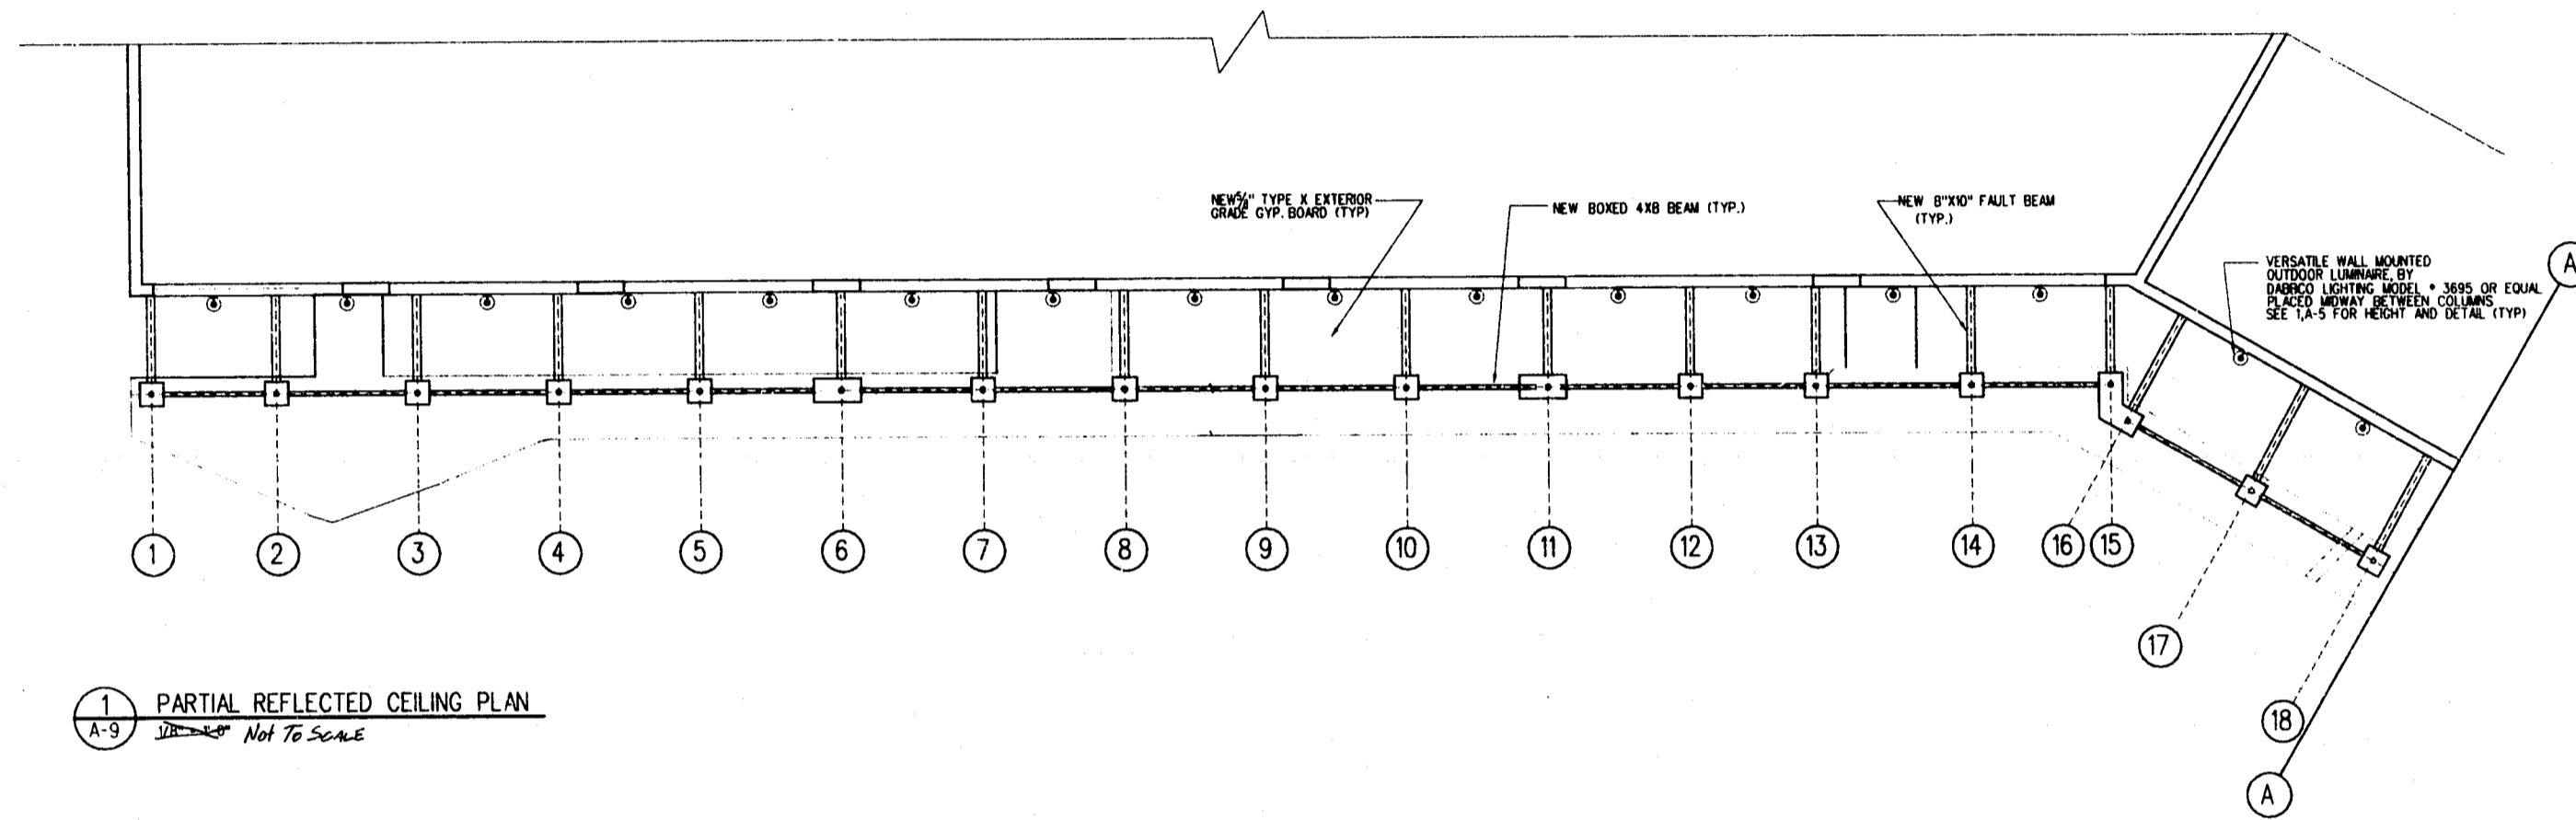

1 PARTIAL REFLECTED CEILING PLAN
A-9 Not To Scale

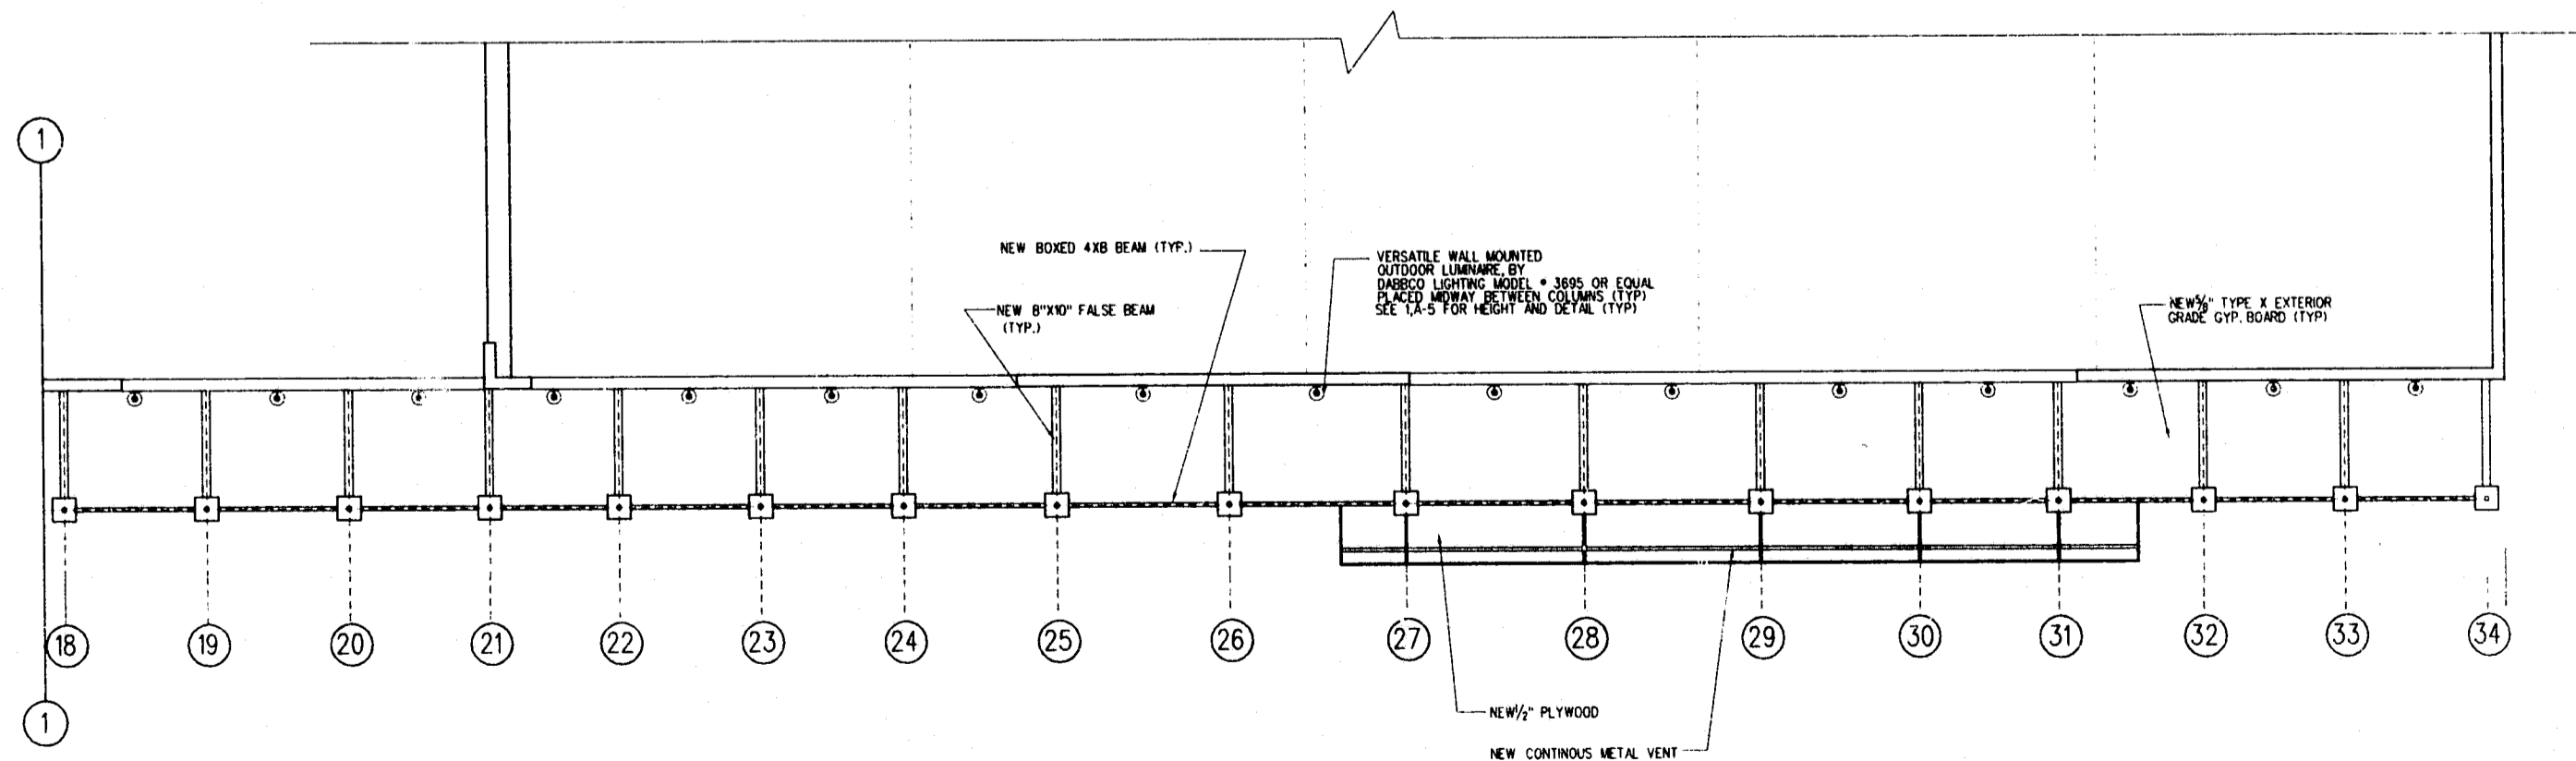

2 PARTIAL REFLECTED CEILING PLAN
A-9 Not To Scale

Submittal	Date	Design	Approval
NO.	DATE	BY	DATE
1	05/27/94		
2	05/27/94		
3	05/27/94		

Drawing Title: REFLECTED CEILING PLANS
Sheet No: A-9 of 10

Revisions	Number	Description	Date

Drawn By: J. Smith
Checked By: J. Smith
Date Issued: 5/31/94
A-9 of 10