



HagerSmith
Design PA

Architecture
Landscape Architecture
Planning
Interior Design

PO Box 1308
300 South Dawson Street
Raleigh, North Carolina 27602
Fax: 919.828.4050

919.821.5547 © Copyright 1994

Scale

Associates / Consultants

STRUCTURAL ENGINEER
LYSAGHT AND ASSOCIATES
120 SAINT MARY'S STREET
RALEIGH, NC
Phone: 919.833.0495

ELECTRICAL ENGINEER
TRIANGLE ENGINEERING ASSOC.
417 N. BOYLAN AV.
RALEIGH, N.C.
Phone: 919.831.2588

Project 430-425

8000 AERIAL CENTER

Client

PIZZAGALLI


AERIAL CENTER
EXECUTIVE PARK
CARY, NC

Drawing Title
PRELIMINARY ELEVATIONS


Revisions		
Number	Description	Date

Drawn By CAC,DSR
Checked By JWMS
Date Issued 12/28/94

A-1
2 of 10

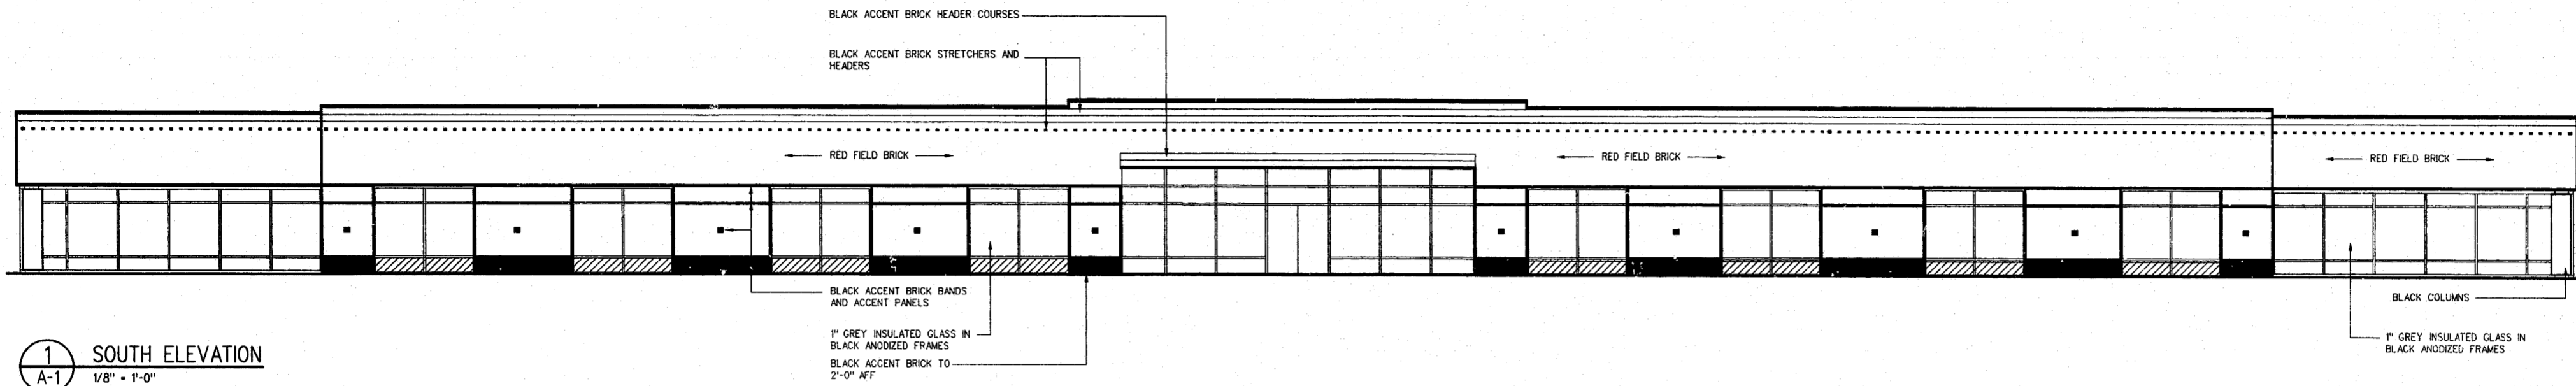


1 SOUTH ELEVATION
A-1 1/8" = 1'-0"

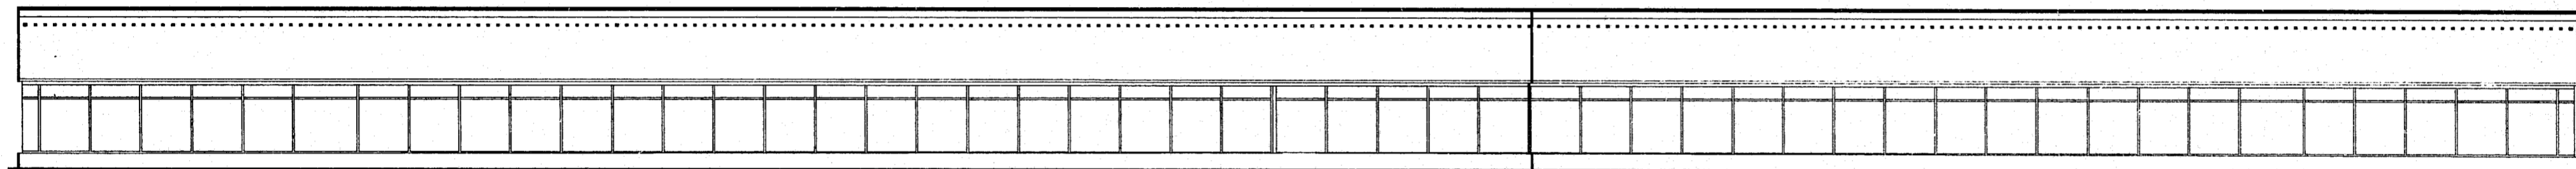


2 NORTH ELEVATION
A-1 1/8" = 1'-0"

NOTE: SEE 1/A-1 FOR TYPICAL NOTES

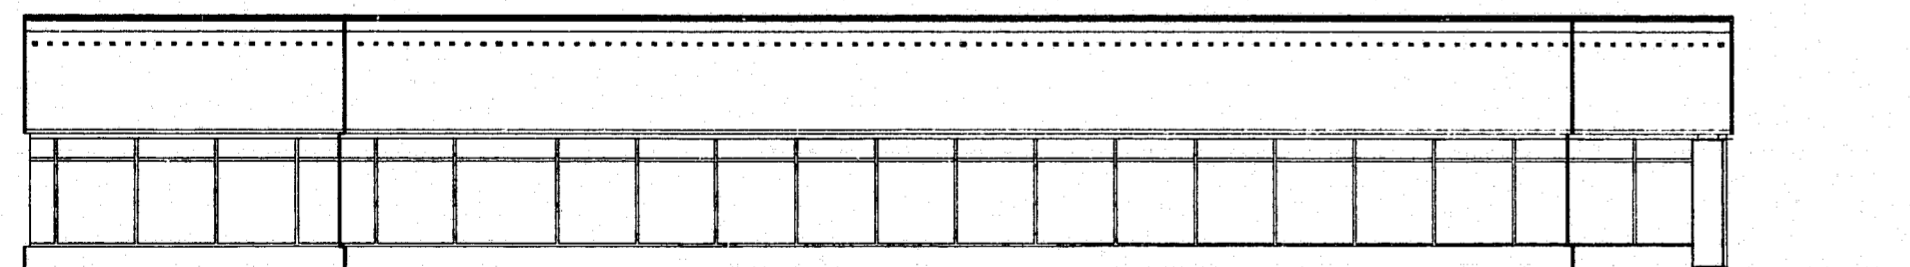

3 WEST ELEVATION
A-1 1/8" = 1'-0"

NOTE: SEE 1/A-1 FOR TYPICAL NOTES

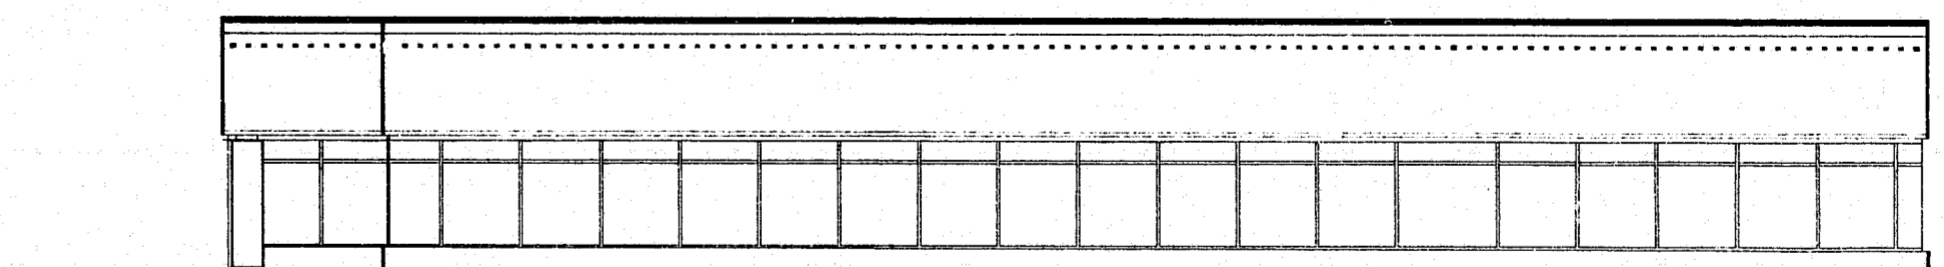

4 EAST ELEVATION
A-1 1/8" = 1'-0"

NOTE: SEE 1/A-1 FOR TYPICAL NOTES

FINAL APPROVED PLANS

2/21