

AERIAL CENTER 2701

AERIAL CENTER EXECUTIVE PARK
2701 AERIAL CENTER PARKWAY
CARY, NORTH CAROLINA


OWNER / DEVELOPER
PIZZAGALLI PROPERTIES, L.L.C.
2501 AERIAL CENTER PARKWAY
MORRISVILLE, NORTH CAROLINA 27560
919-481-3303

PREPARED BY



Aiken & Yelle Associates, PA
Professional Engineers & Land Surveyors

3755 Benson Drive
Raleigh, North Carolina 27609
919-877-9992 Fax 919-877-9979

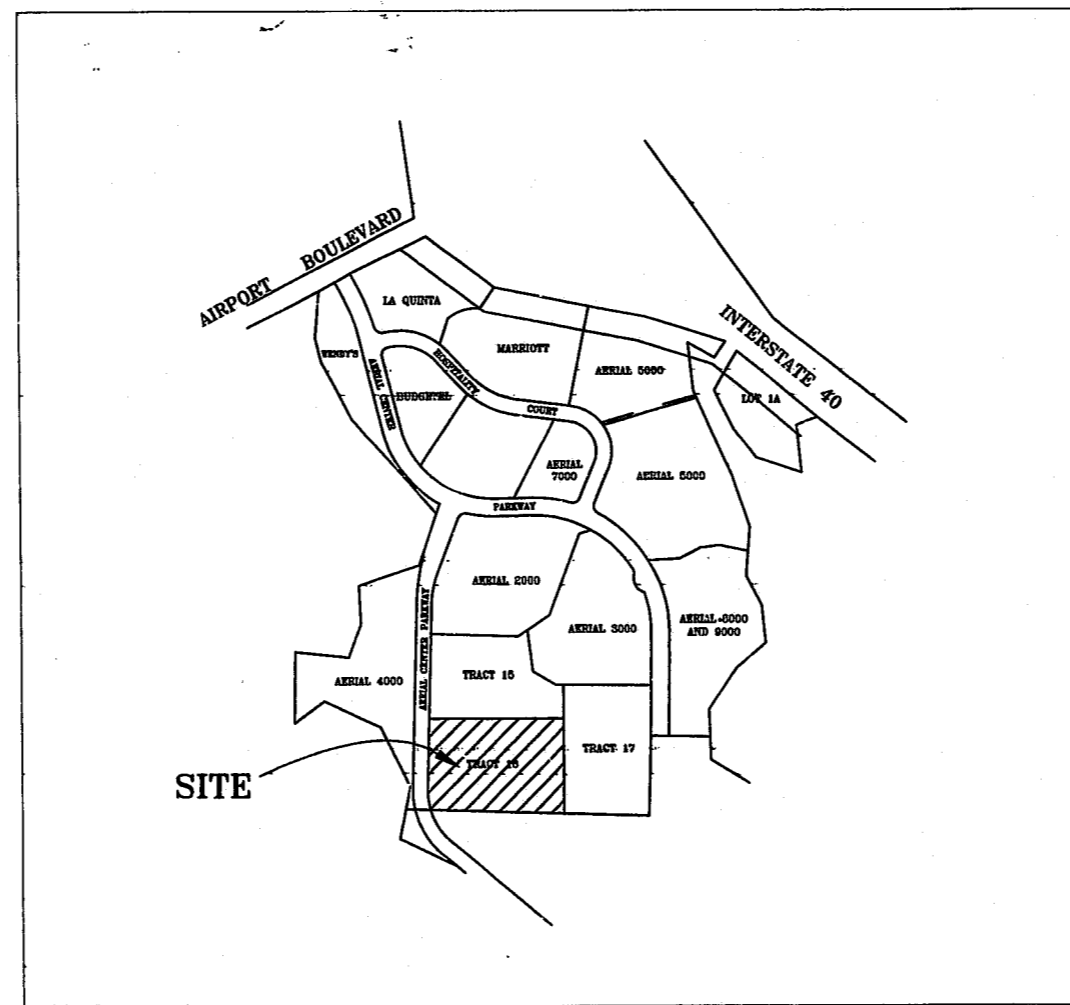

VICINITY MAP
SCALE 1" = 500'

TOWN OF CARY
ENGINEERING DEPT.
REVIEWED BY: J. Revick for Streets
DATE: 4-12-2002



99-51-178

INDEX TO DRAWINGS
SHEET TITLE

1. EXISTING CONDITIONS PLAN
2. PRELIMINARY SUBDIVISION PLAN
2. SITE LAYOUT PLAN
3. SITE GRADING, DRAINAGE AND UTILITY PLAN
4. SITE SEDIMENTATION AND EROSION CONTROL PLAN
5. SITE LANDSCAPE PLAN
6. SITE LIGHTING PLAN
7. BUILDING ELEVATION
- 7A. BUILDING FLOOR PLAN (FIRST FLOOR)
- 7B. BUILDING FLOOR PLAN (SECOND FLOOR)
8. SITE DETAILS
9. SITE DETAILS

PRELIMINARY
SUBJECT TO REVIEW