


NO.	REVISION	DATE
1	REVISED PER CITY COMMENTS	04/29/07
2	REVISED PER CITY COMMENTS	07/25/07
3	REVISED PER CITY COMMENTS	07/25/07
4	REVISED PER CITY COMMENTS	10/17/07

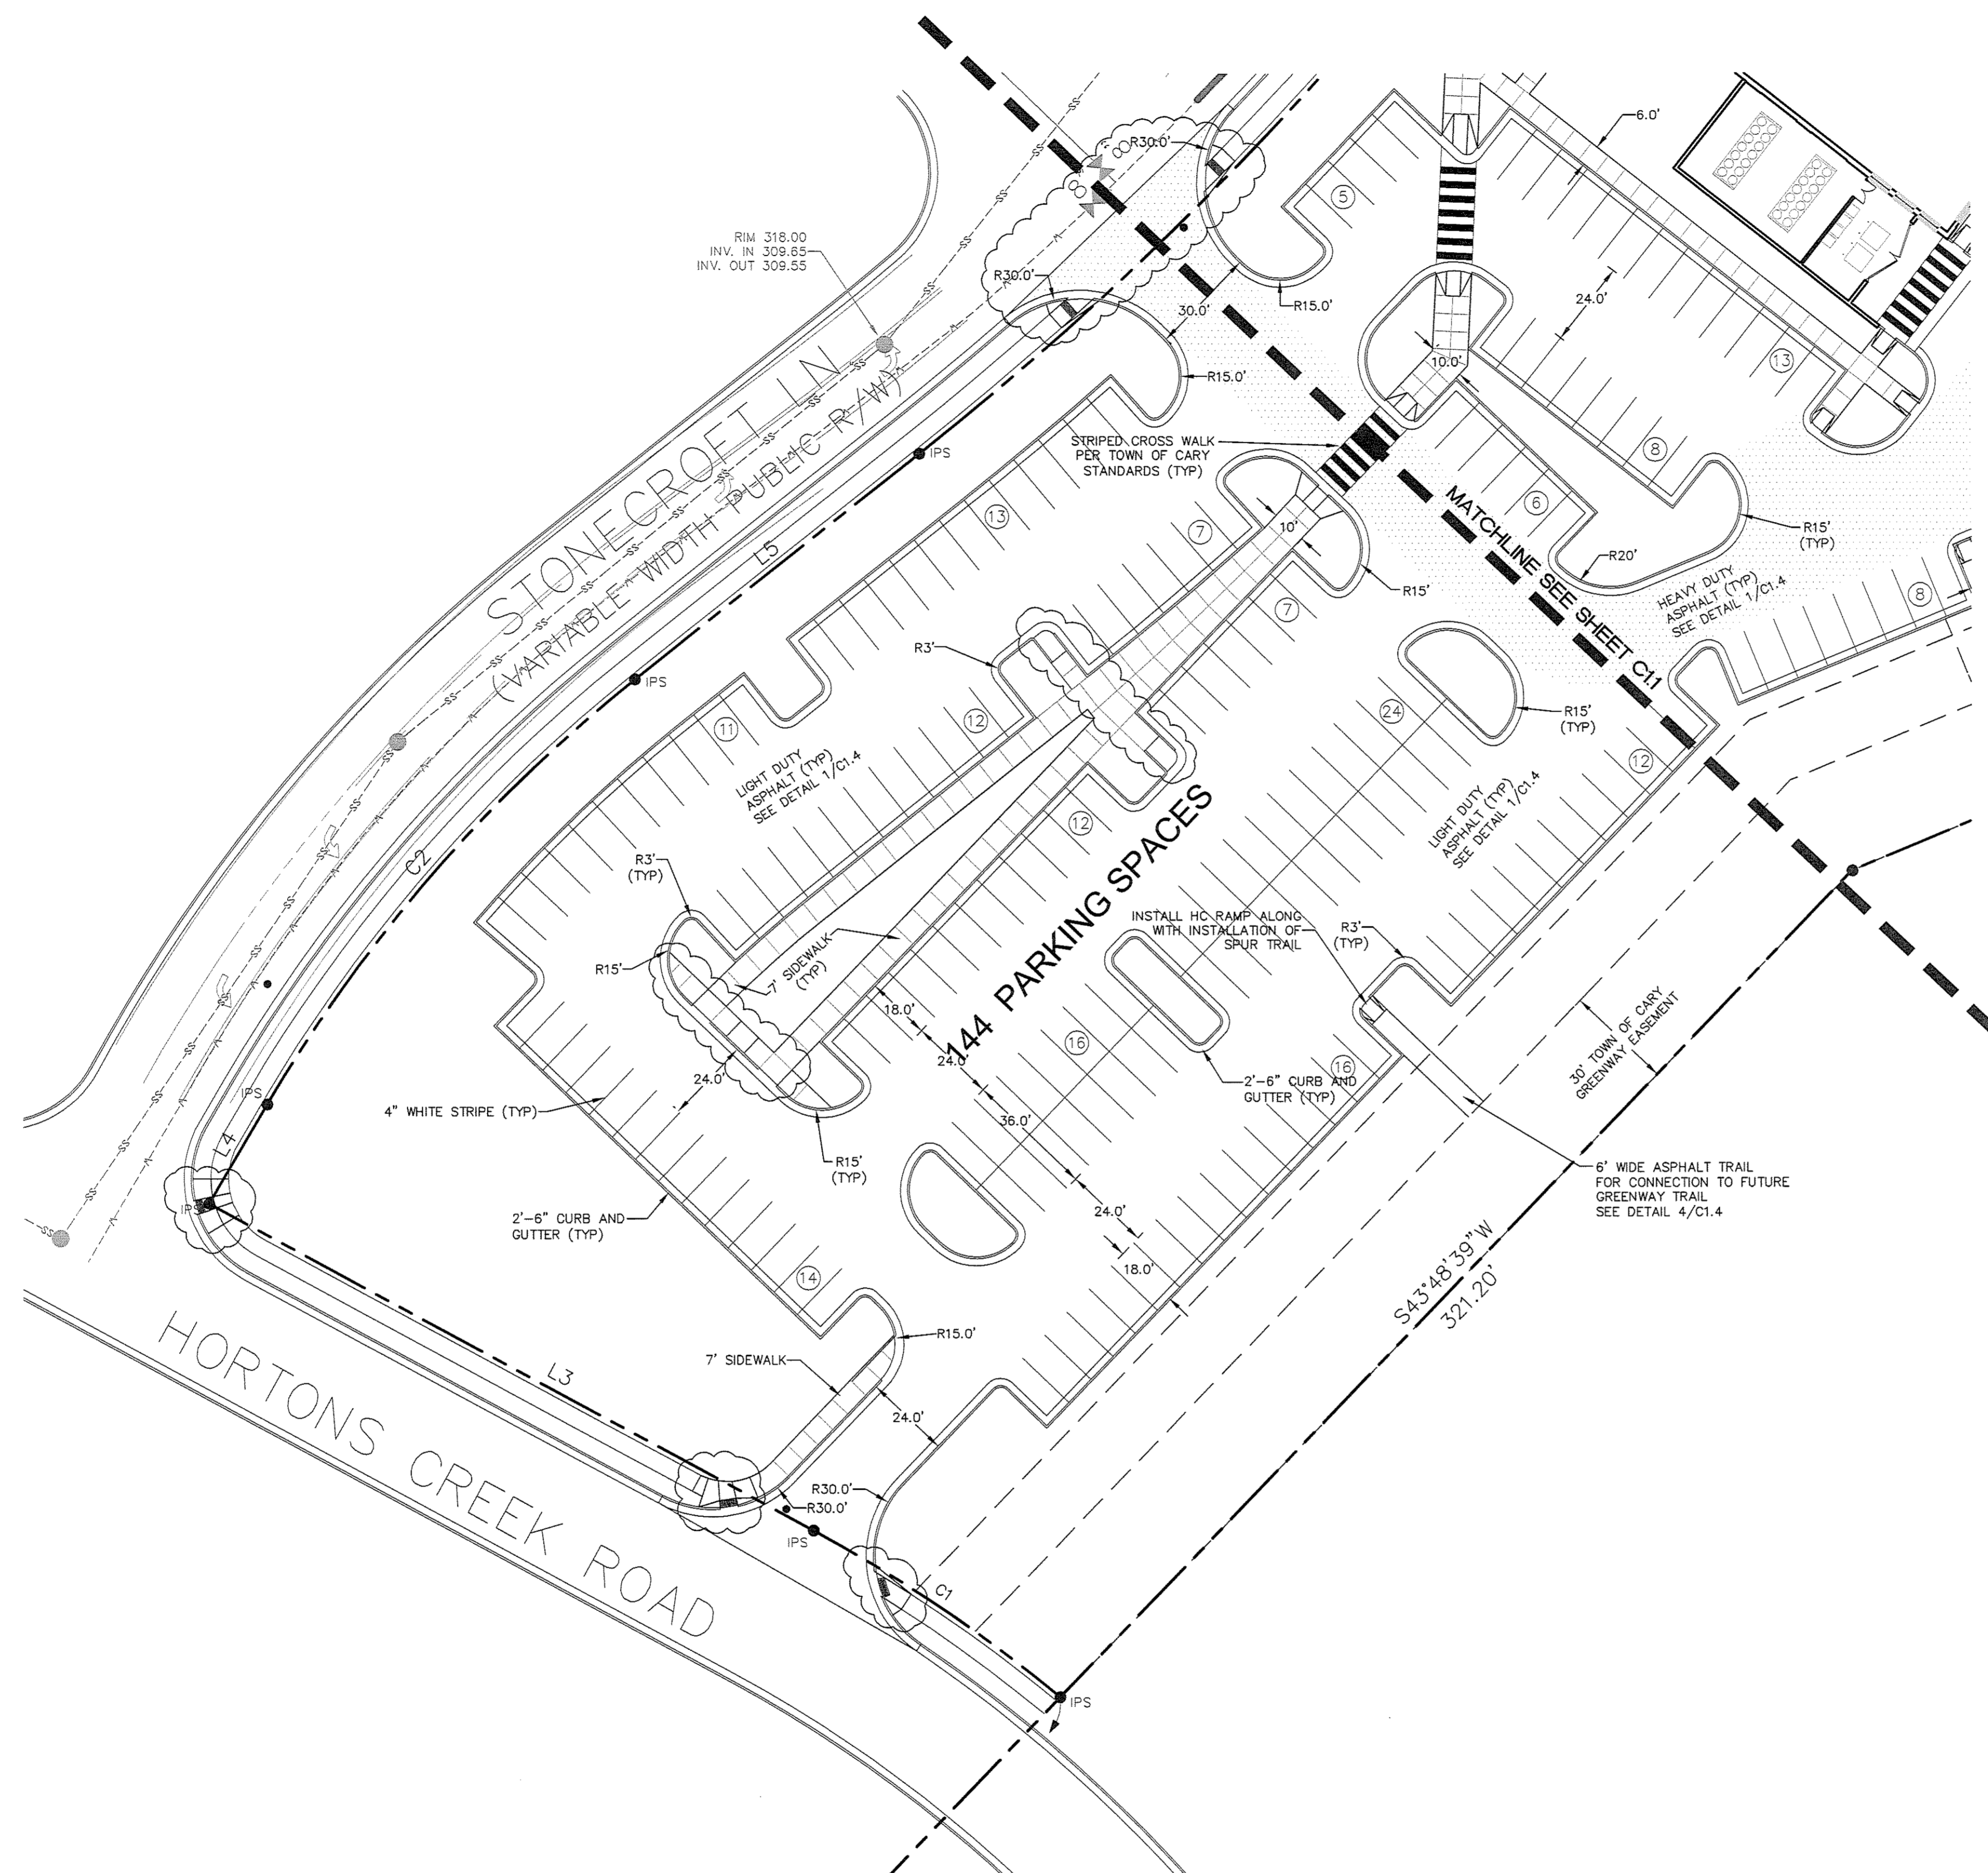

200 S COLLEGE ST
SUITE 720
CHARLOTTE, NC 28202
T 704.334.7925
F 704.334.7926
www.stewart-eng.com

STEWART

PERKINS EASTMAN
530 W. Sixth Street
CHARLOTTE, NC 28202
704.940.0501
Fax 362.4602

Owner:
UNC HOSPITALS
101 MANNING DR SUITE 6012
CHAPEL HILL, NC 27514

Civil / Site:
STEWART ENGINEERING
200 S. COLLEGE ST SUITE 720
CHARLOTTE, NC 28202 704.334.7925

Landscape:
STEWART ENGINEERING
200 S. COLLEGE ST SUITE 720
CHARLOTTE, NC 28202 704.334.7925

Structural:
STEWART ENGINEERING
200 S. COLLEGE ST SUITE 720
CHARLOTTE, NC 28202 704.334.7925

MECHANICAL, PLUMBING & FIRE PROTECTION
PW
4021 STIRRUP CREEK DR SUITE 400
DURHAM, NC 27703 919.480.1440

ELECTRICAL
PW
4021 STIRRUP CREEK DR SUITE 400
DURHAM, NC 27703 919.480.1440

POOL CONSULTANT
COUSLMAN-HUNSAKER
10733 SUNSET OFFICE DR SUITE 400,
ST. LOUIS, MO 63129 314.894.1245

PROJECT TITLE:

AMBERLY WELLNESS CENTER

UNC
WELLNESS CENTERS

AMBERLY
CARY, NORTH CAROLINA

PROJECT No: 24911.00
DRAWING TITLE:


ENLARGED SITE PLAN

SCALE: 1" = 30' STEWART-X6054.00


SHEET: **C1.2**

DATE: MARCH 7, 2007

HATCH LEGEND

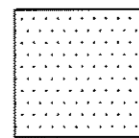 HEAVY DUTY ASPHALT
SEE DTL 1/C1.4

GRAPHIC SCALE

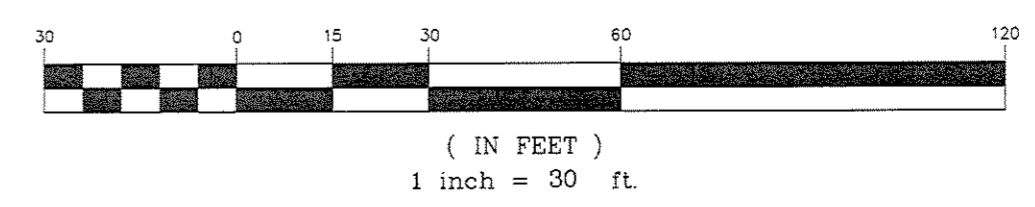

07-SP-024
APPROVED
TOWN OF CARY

APPROVED BY: **ZPC** DATE: 10/15/2007
PLANNING: **KAH** DATE: 2/28/2011
ENGINEERING: _____ DATE: _____