


STORM DRAINAGE PROFILE

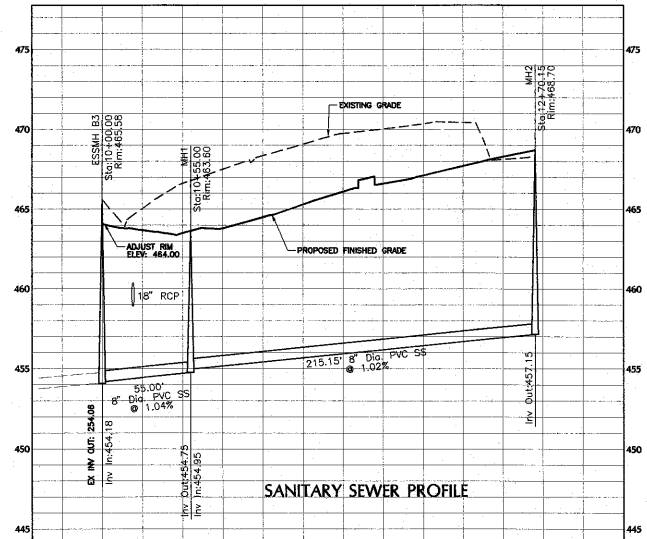

SANITARY SEWER PROFILE



05-SP-001  
APPROVED  
TOWN OF CARY  
DRC Date 06/30/05  
Planning Date 06/30/05  
Engineering Date 7-1-05

No.	Revision	Date	By
1	TOC FIRST REVIEW COMMENTS	02/21/05	MWH
2	TOC SECOND REVIEW COMMENTS	03/09/05	JM
3	ADD PARKING AREA TO COMMENTS	08/20/05	MWH

**THE ARBORETUM PHASE 2**  
WAKE COUNTY  
TOWN OF CARY  
NORTH CAROLINA

Designer: YWB  
Scale: 1" = 40' H  
1" = 4' V  
Drawn By: DW  
Date: 7/3/05  
Checked by: WE  
Job No: 20022120

**SANITARY SEWER & STORM DRAINAGE PLAN AND PROFILE**

**WITHERS & RAVENEL**  
ENGINEERS | PLANNERS | SURVEYORS  
111 Woodfern Drive, Cary, North Carolina 27511 Tel: 919-467-3310 Fax: 919-467-4208 www.wrsr.com