
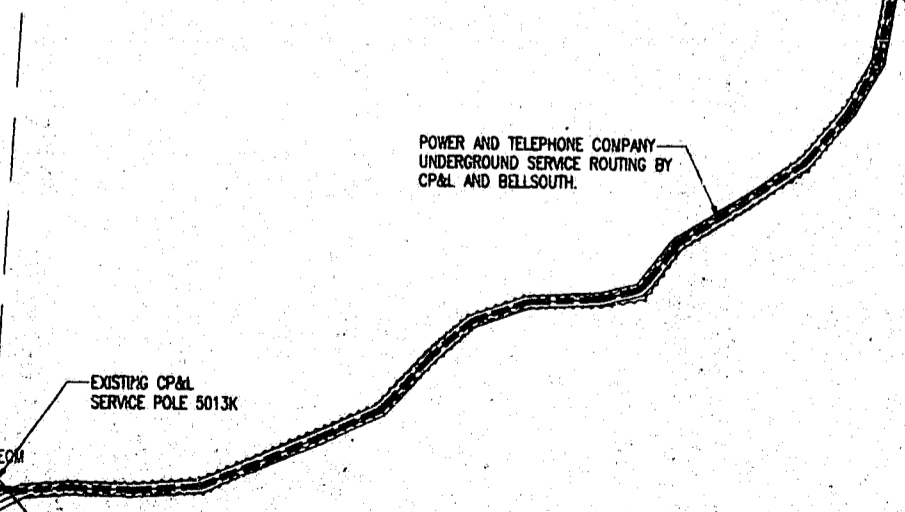


NOTE: COORDINATE FOUNDATION INSTALLATION WITH GROUNDING INSTALLATION
 ← SEE MONOPOLE VENDOR'S DRAWINGS FOR INFO NOT SHOWN.

1
 S-1 S-3
 NO SCALE
 ALTERNATE - MAT FOOTING

BELL SOUTH Carolinas PCS, L.P. 09-368-135-A SECTIONS AND DETAILS copyright © 1998 Richard Ober-Hensley 2301 Remondale Drive Post Office Box 31288, Raleigh, NC 27622-1288 Tel: 919/782-5211 Fax: 919/782-5225		
PROJECT MANAGER A. LATHAM LEAD DESIGN PROJ. B. ROSS DRAWN E. OLIVER PROJECT NUMBER 22597-02		DEPARTMENT MANAGER J. BAKER CHECKED J. BAKER DATE JUL 8, 1998 DRAWING NUMBER S-3

- NOTES:
1. PROVIDE 2 PULL STRINGS SECURELY FASTENED AT EACH END OF THE CONDUIT. PULL STRING TO BE 200LB TEST POLYETHYLENE CORD. PROVIDE CAP ON END OF THE CONDUITS AND MARK AS SHOWN ON THE ENLARGED SITE PLAN.
 2. PROVIDE MARKER (REBAR) AT END OF UTILITY TRENCH. MARKER SHALL BE DRIVEN SO THAT A MINIMUM OF 2 FEET REMAINS EXPOSED ABOVE GRADE. EXPOSED PORTION TO BE PAINTED BRIGHT ORANGE.
 3. CONTACT MR. SCOTT BARNES WITH CP&L PH.(919-481-6142) BEFORE BEGINNING UTILITY TRENCH CONSTRUCTION TO VERIFY ROUTING AND SERVICE CONNECTION. TO APPLY FOR SERVICE WITH CP&L CALL 919-783-5400.

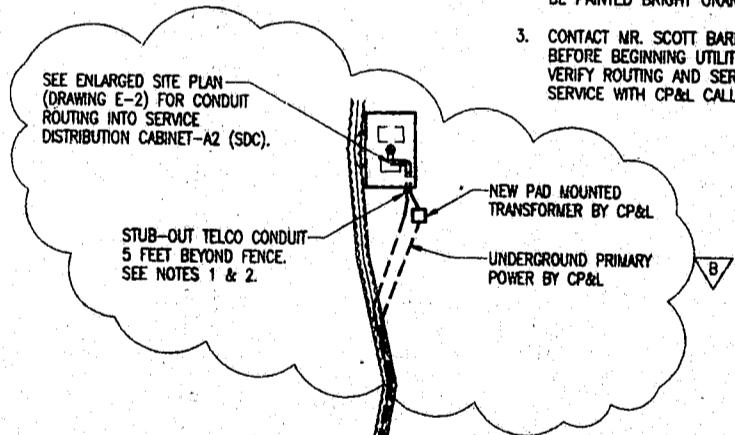

SERVICES ROUTING PLAN
 SCALE: 1" = 100'

BELL SOUTH Carolinas PCS, L.P. 09-368-135-A SERVICES ROUTING PLAN copyright © 1998 Richard Ober-Hensley 2301 Remondale Drive Post Office Box 31288, Raleigh, NC 27622-1288 Tel: 919/782-5211 Fax: 919/782-5225		
PROJECT MANAGER J. LATHAM LEAD DESIGN PROJ. B. WATTE DRAWN E. OLIVER PROJECT NUMBER 22597-02		DEPARTMENT MANAGER A. ANCHORS CHECKED A. ANCHORS DATE 11/26/98 DRAWING NUMBER E-1

90-SP-158
APPROVED
 11-26-98
 JHT 11-26-98