


- IRRIGATION METER
- WATER METER
- SANITARY SEWER LATERAL

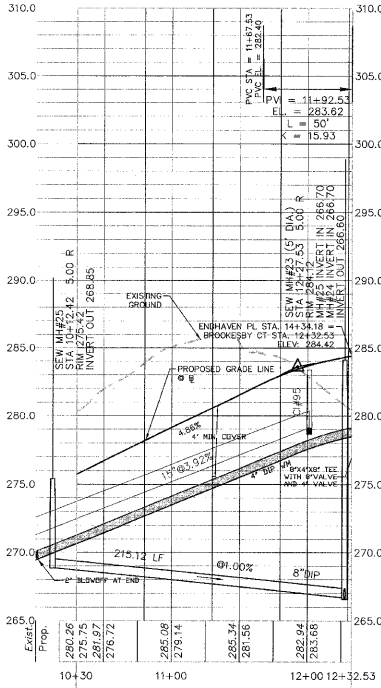

Approved by: DRC Date: 6/12/08  
 Planning: AR Date: 7/10/08  
 Engineering: TS Date: 7/12/08

04-5B-028  
 APPROVED  
 TOWN OF CARY

HORIZ. SCALE: 1" = 50'  
 VERT. SCALE: 1" = 5'

**CHAS. H. SELLS, INC.**  
 Consulting Engineers, Surveyors & Photogrammetrists

15401 Western Parkway  
 Suite 200  
 Cary, NC 27513  
 Tel: 919-678-0035  
 Fax: 919-678-0206  
 www.chasells.com

RELEASED FOR CONSTRUCTION

© CHAS SELLS INC. ALL RIGHTS ARE RESERVED. ANY PERMISSION, REPRODUCTION OR OTHER USE OF THIS DOCUMENT WITHOUT PRIOR PERMISSION FROM CHAS SELLS INC. IS EXPRESSLY FORBIDDEN.

**Carolina Preserve by  
 Del Webb at Amberly**  
 Phase 1  
 Cary, NC  
 GS Carolina  
 3412 1/2 Hillsborough St.  
 Raleigh, NC 27607

REVISIONS	
PROJECT #: 04-4300    DATE: 4/25/05	
DRAWN BY: JE    CHECKED BY: DS	
TITLE	
<b>BROOKESBY CT              PLAN AND PROFILE</b>	
SHEET	
<b>C3.7</b>	