
 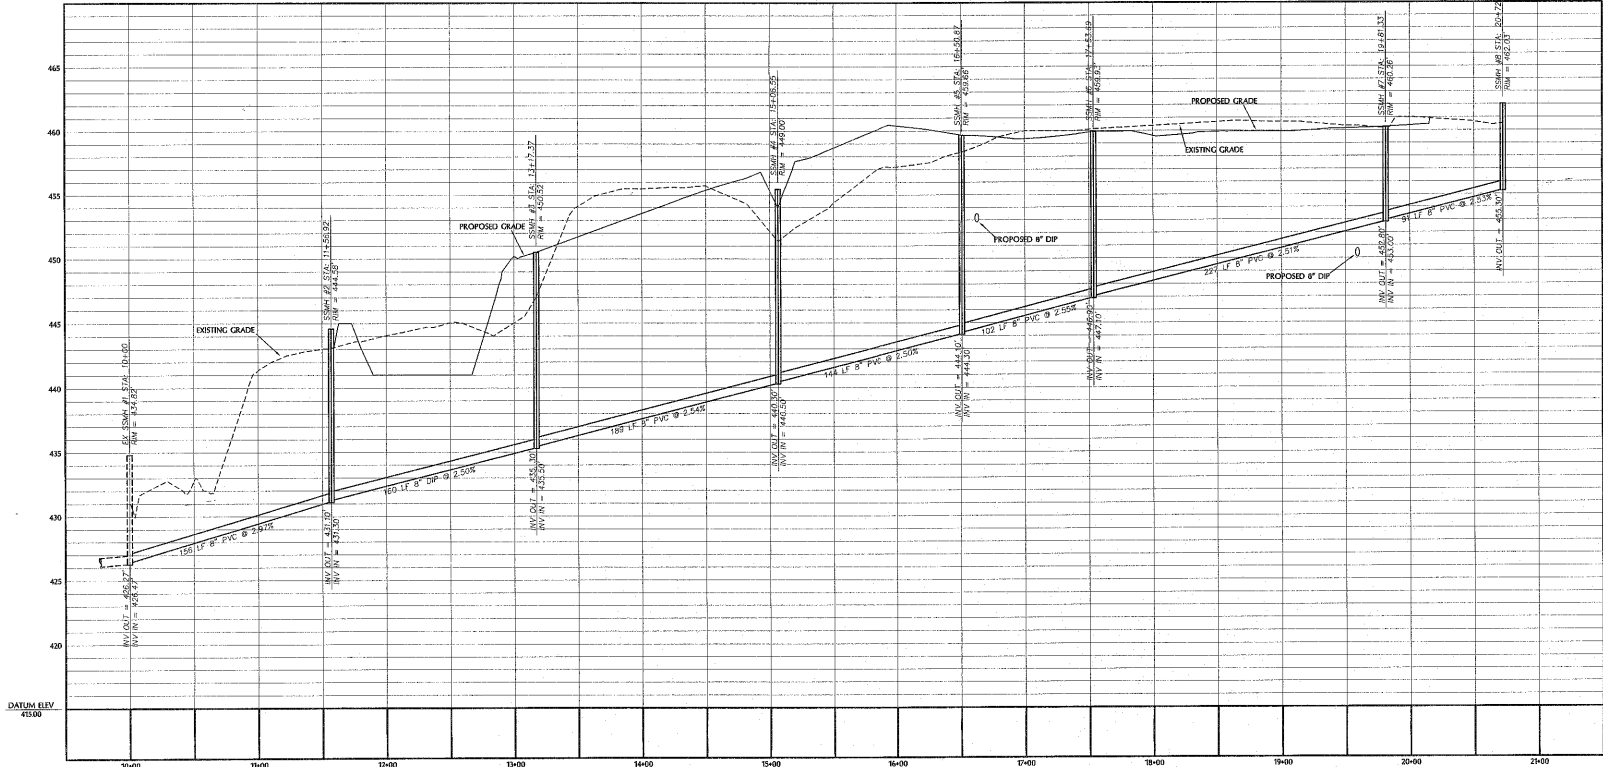


SANITARY SEWER PLAN/PROFILE  
 STA 10+00.00 THRU 20+72.63

BOTH THE DOMESTIC AND FIRE PROTECTION BACKFLOW DEVICES TO BE LOCATED WITHIN BUILDING REFER TO PLUMBING AND FIRE PROTECTION PLANS


N/E  
 WEST, KENNETH  
 DB 1744, PG 311  
 FIRE O/PROG/0188  
 ZONING R-30  
 LAND USE PREFAB WAREHOUSE



DATUM ELEV  
 435.00

07-SP-015  
 APPROVED  
 TOWN OF CARY  
 DATUM ELEV  
 435.00

Approved by: **DAC** Date: **04-23-07**  
 Planning: **JGB** Date: **05-18-07**  
 Engineering: **IS** Date: **5-21-07**

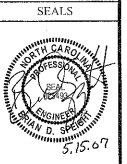

REVISIONS

NO.	DATE	DESCRIPTION

CONSTRUCTION DOCUMENT

**CARY ALLIANCE CHURCH**  
**4108 TEN TEN ROAD**  
**CARY, NORTH CAROLINA**

DRAWN BY: **JPC**  
 CHECKED BY: **JPC**  
 DATE: **2/14/07**  
 PROJECT NUMBER: **06-015**

SANITARY SEWER  
 PLAN/PROFILE

**C6.02**

SHEET 10 OF 27  
 FEBRUARY 2007