


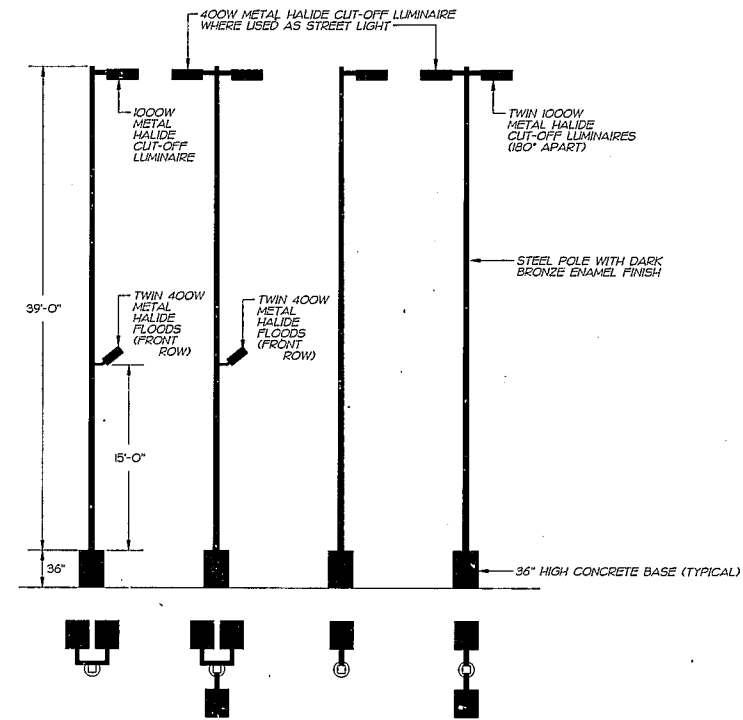

SITE LIGHTING
EQUIPMENT
LEGEND/
ELEVATIONS
SCALE: 5/32" = 1'-0"



SITE LIGHTING PLAN
SCALE: 1" = 60'-0"

Franceschi Architects PA.
1125 East Morehead Street / Suite 202
Charlotte, North Carolina 28204 / 704 / 333-6166

Project
CARY AUTO MALL
CARY, NORTH CAROLINA

Project Number 8910
Date NOVEMBER 17, 1989
Revisions

Sheet Description
SITE LIGHTING PLAN

Sheet Number 15

Franceschi Architects PA. hereby reserves its common law copyright and other property rights in these plans, ideas and designs. These ideas, designs and plans are not to be reproduced, changed or copied in any form or manner whatsoever, nor are they to be assigned to any third party without first obtaining the express written permission from Franceschi Architects PA. All dimensions on these drawings shall have precedence over scaled dimensions. Contractors shall verify and be responsible for all dimensions and conditions on the site and Franceschi Architects PA. must be notified in writing of any variation from the dimensions, conditions and specifications shown by these drawings.