


SITE LIGHTING  
EQUIPMENT  
LEGEND/  
ELEVATIONS  
SCALE: 5/32" = 1'-0"

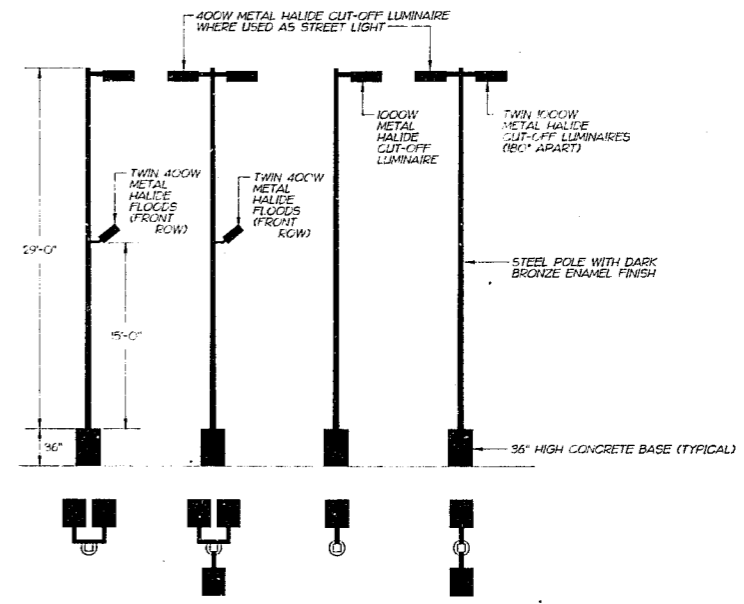

Franceschi Architects PA.  
1125 East Morehead Street / Suite 202  
Charlotte, North Carolina 28204 / 704 / 333 6166

PROJECT  
**CARY AUTO MALL**  
CARY, NORTH CAROLINA

Project Number 8910  
Date NOVEMBER 17, 1989  
Revision JANUARY 03, 1990

Sheet Description  
**SITE LIGHTING PLAN**

Sheet Number **E1**  
OF 2

**SITE LIGHTING PLAN**  
SCALE: 1" = 60'-0"

8957010ES-OLDWG  
Thursday, January 4, 1990 11:02 am

Franceschi Architects, PA. hereby reserves its copyright and other property rights in these plans, ideas and designs. These ideas, designs and plans are not to be reproduced, changed or copied in any form or manner without the express written permission from Franceschi Architects, PA. Where dimensions on these drawings shall have precedence over scaled dimensions. Contractors shall verify and be responsible for all dimensions and conditions on the job and Franceschi Architects, PA. must be notified in writing of any variation from the drawings, conditions and specifications shown by these drawings.