



SECTION THRU BUILDING
SCALE 3/8" = 1'-0"


SYMBOL SCHEDULE	
☒	SUPPLY AIR DUCT
☐	RETURN OR EXHAUST AIR DUCT
→	SUPPLY AIR
←	RETURN OR EXHAUST AIR
⊕	SPLITTER DAMPER
⊖	AIR DEFLECTOR
⊘	FLEXIBLE CONNECTION
⊙	THERMOSTAT
↗	ELBOW UP
↘	ELBOW DOWN
—L—	LIQUID LINE
—S—	SUCTION LINE
—G—	GAS LINE
—C.D.—	CONDENSATE DRAIN
—	GAS COCK
⊞	SWITCH WITH PILOT LIGHT

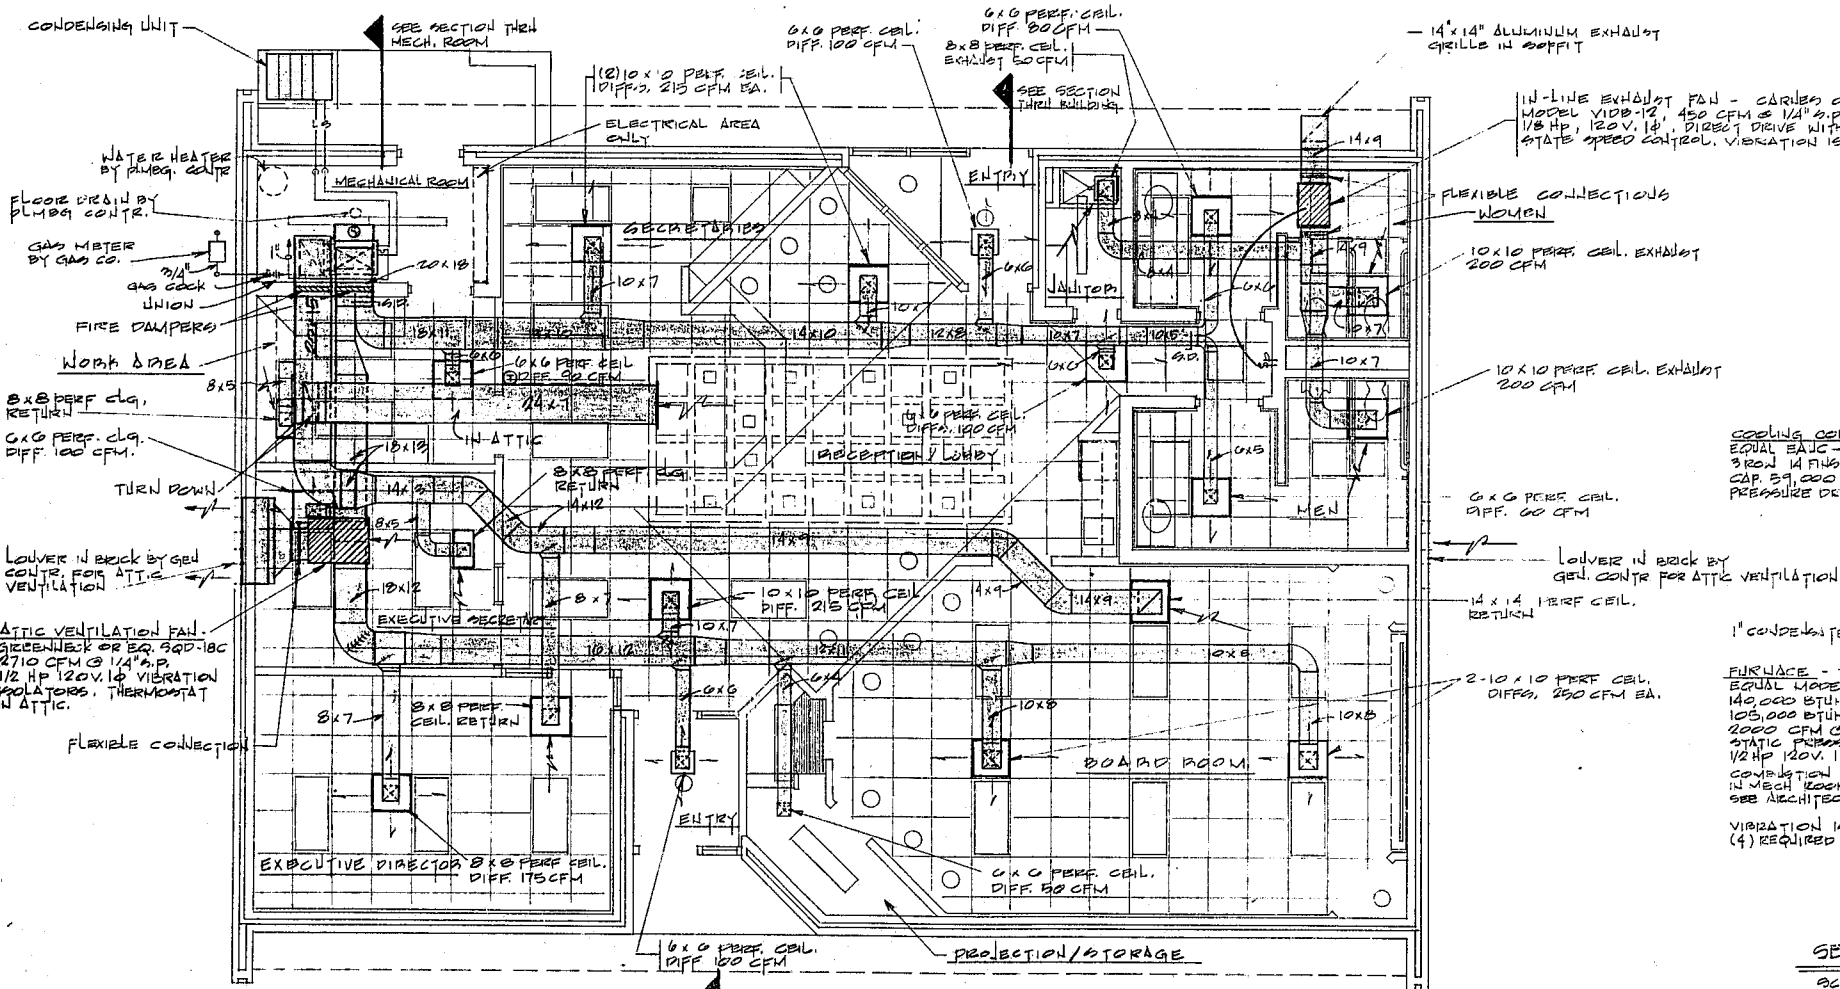

HEATING & AIR CONDITIONING FLOOR PLAN
SCALE 1/4" = 1'-0"

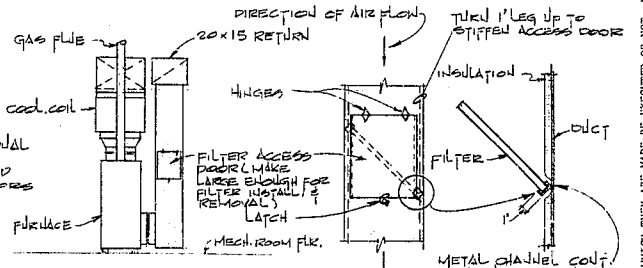

DETAIL OF FILTER RACK
SCALE 1/2" = 1'-0"

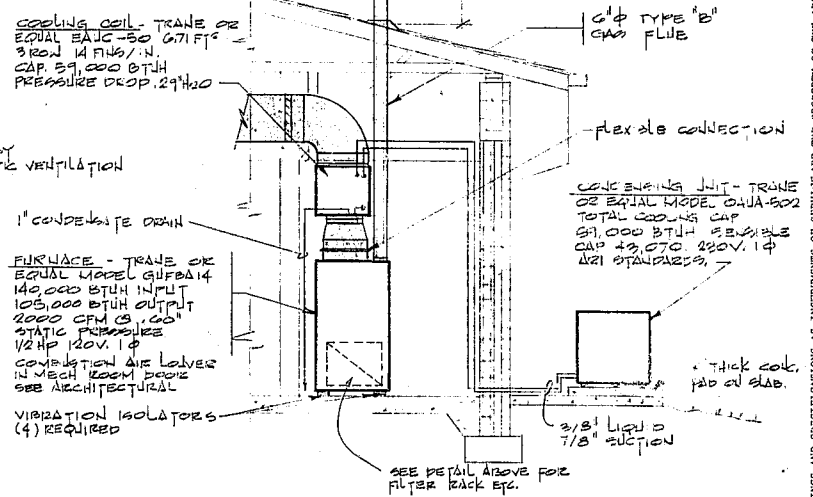


SECTION THRU MECHANICAL ROOM
SCALE 3/8" = 1'-0"

THESE DRAWINGS AND SPECIFICATIONS AS INSTRUMENTS OF SERVICE ARE THE PROPERTY OF THE ARCHITECT. ANY REUSE OR REPRODUCTION OF THESE DRAWINGS WITHOUT THE WRITTEN PERMISSION OF THE ARCHITECT IS STRICTLY PROHIBITED.

COMMISSION
8109
DRAWN BY
NTR
CHECKED BY
CFL

HACKNEY, SEARS & ASSOC., ARCHITECTS
321 EAST CHAPEL HILL STREET, DURHAM, N.C.
1142 EXECUTIVE CIRCLE, CARY, N.C.

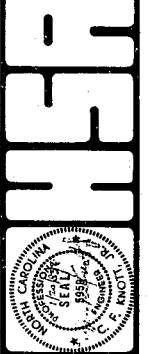

OFFICE BUILDING FOR COMMERCE
CARY CHAMBER OF COMMERCE
WEST CHATHAM STREET
CARY, NORTH CAROLINA

DATE: JAN. 20 1983
REVISIONS:

KNOTT & ROBERTS, P.A.
ENGINEERS
1014 CENTRAL CAROLINA BANK BUILDING
DURHAM, N.C.
TELEPHONE 919-683-1388

SHEET NO.
HAC-1
OF ONE SHEETS