


CARY CORPORATE CENTER

CARPENTER ASSOCIATES
 150 CORNERSTONE DRIVE, SUITE 102
 CARY, NORTH CAROLINA 27513
 PHONE (919) 462-0775 FAX (919) 462-9460

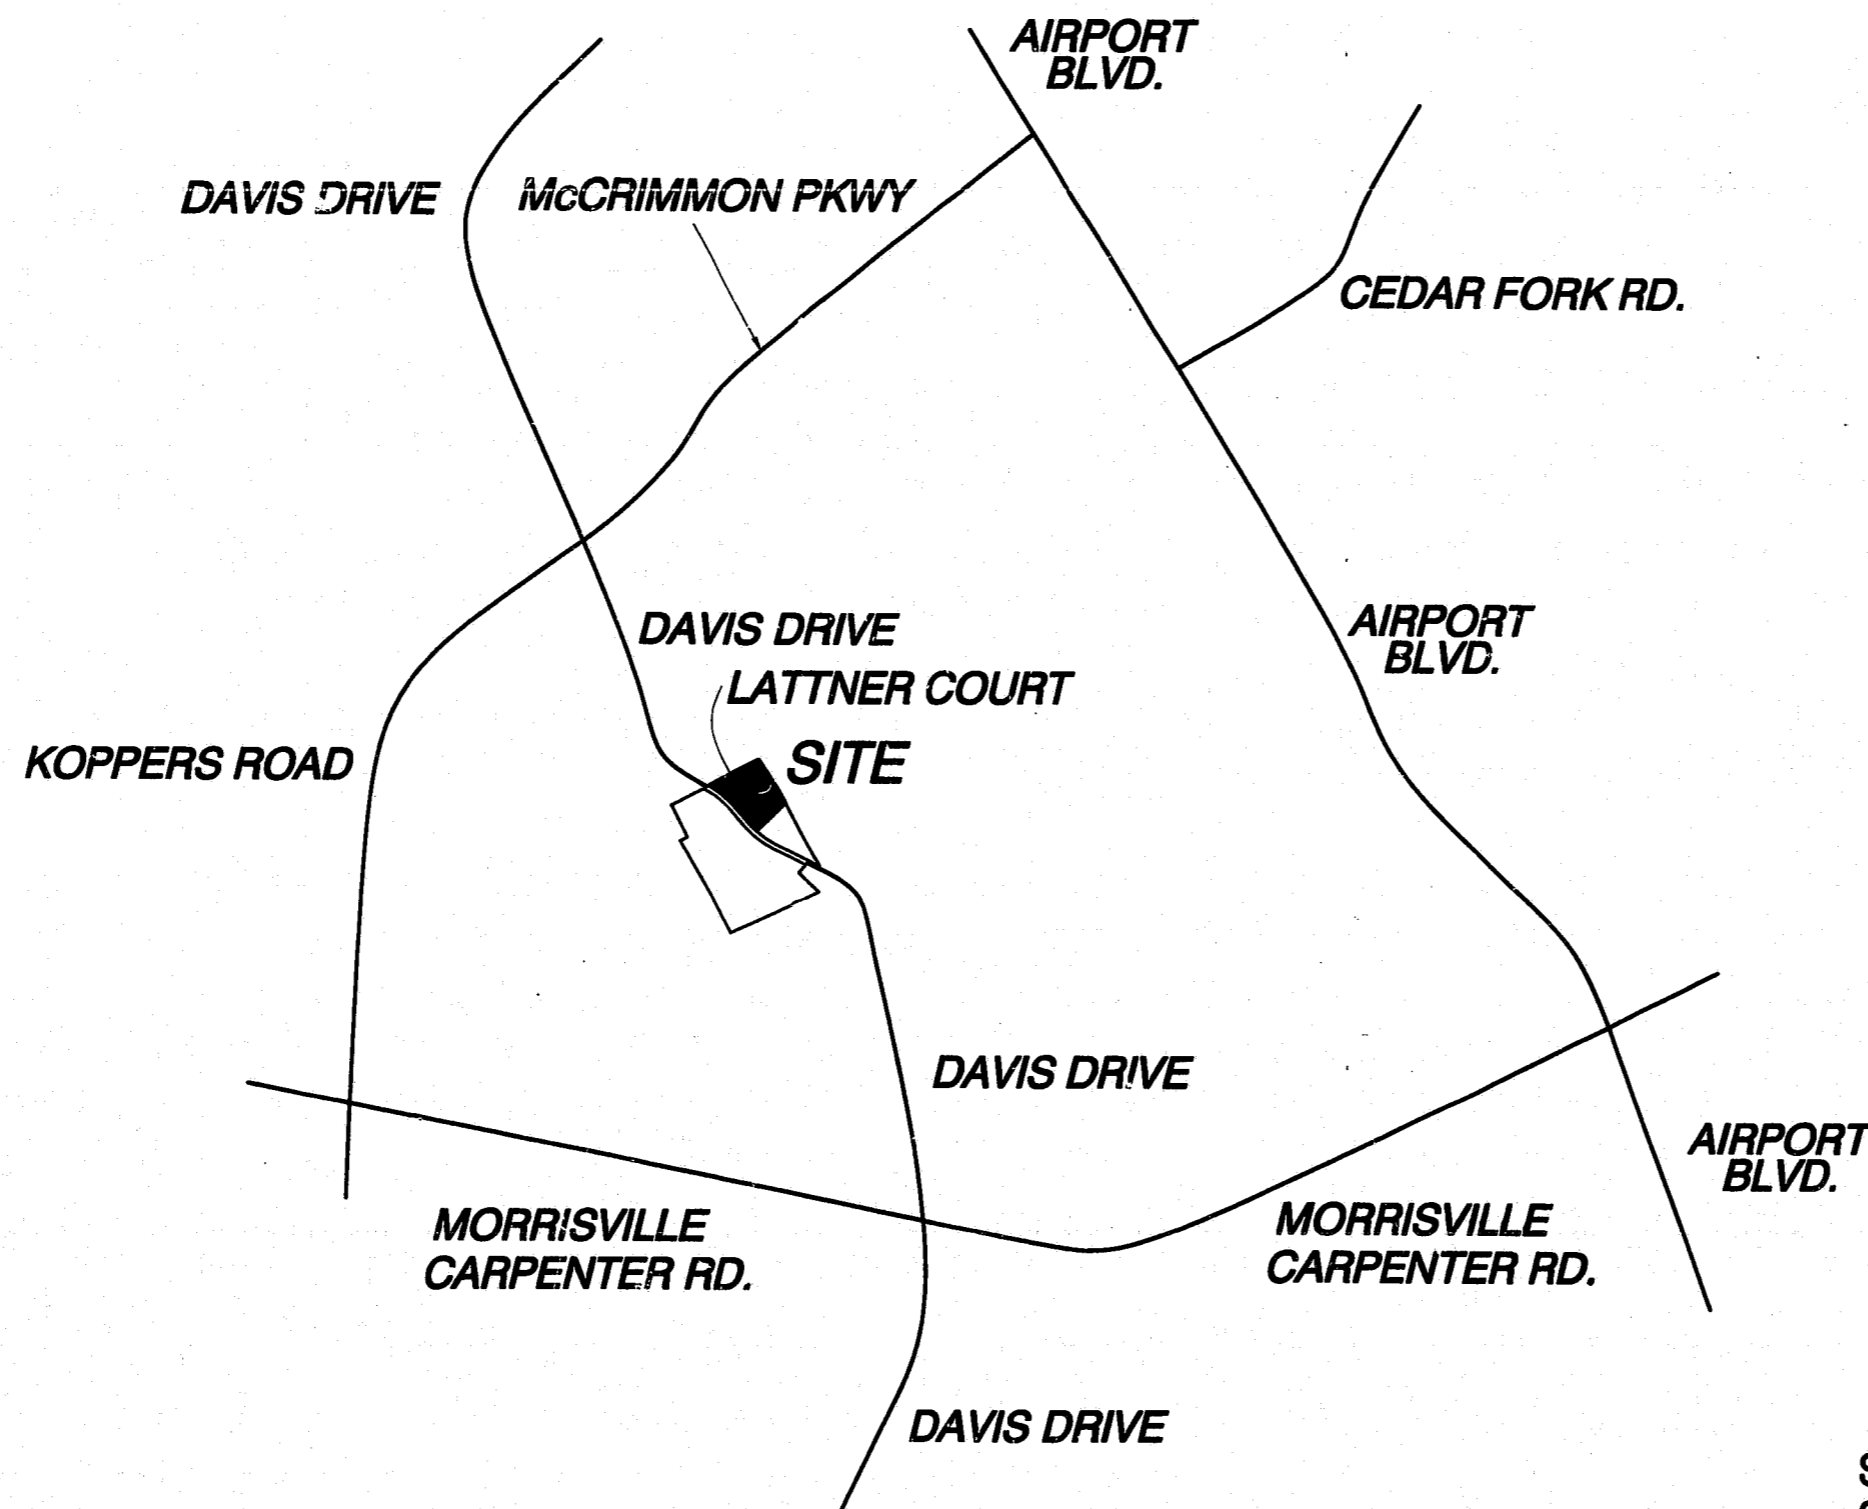


98-SP-148
APPROVED
 BY: DEC DATE: 9-15-98
 TM DATE: 9-29-98
 BY: JPP DATE: 1/23/98
 TOWN OF CARY
 DEVELOPMENT REVIEW GROUP

INDEX TO PLANS

SHEET C-0	COVER SHEET
SHEET C-1	LAYOUT
SHEET C-2	UTILITIES
SHEET C-3	GRADING, DRAINAGE AND EROSION CONTROL
SHEET L-1	PLANTING PLAN AND TREE SURVEY
SHEET L-2	LIGHTING PLAN
SHEET D-1	T.O.C. STANDARD DETAILS
SHEET D-2	T.O.C. STANDARD DETAILS
SHEET A-2,4,6	ARCHITECTURAL ELEVATIONS
SHEET A-1,3,5	ARCHITECTURAL FLOOR PLA

REVISION	DATE
1	
2	
3	
4	
5	

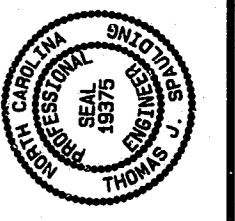

SE SPAULDING
ENGINEERING, P.C.
 Civil Consulting Engineers
 315 North Academy Street Cary, North Carolina 27513
 Phone (919) 319-9393 Fax (919) 319-9390

PREPARED FOR: CARPENTER ASSOCIATES
 DATE: Tue June 25 1998
 FILE NO: 70-9801.PRD
 DESIGNED BY: T.S. & M.L.
 DRAWN BY: M.L.
 APPROVED BY: T.S.

CARY CORPORATE CENTER
COVER SHEET

DRAWING
 SHEET
C-0

PROJECT NUMBER
70-9801