


Jul-12-1999 3:19PM

No. 5714 P. 2

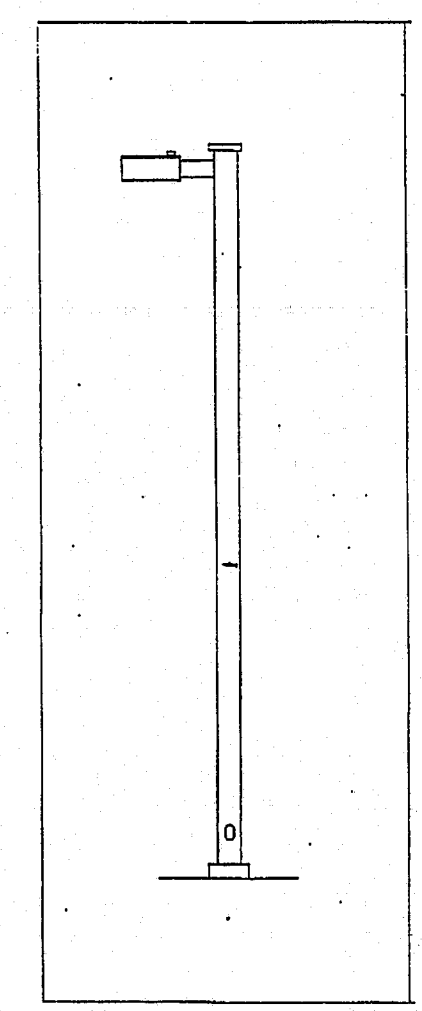

"Parkway"
Shoebox fixture on
30' ht pole
Cary Senior Center
Bond Park

000021 12-Jul-99 04:12P

APPROVED
TER 10-8-99
JFP 11/11/99

CALCULATION SUMMARY-							
AREA NAME	DIMENSIONS	GRID NAME	AVE	MAX	MIN	AVE/MIN	
Cary Senior Center	280x331x0ft	10x10	<+>	2.3	5.3	0.7	3.3

LUMINAIRE SCHEDULE							
TYP	SYMBOL	DESCRIPTION	LAMP	LUMENS	MOUNTING/BALLAST	LLF	QTY
013	☐	GE SB40_1/POLE (1) "004" SH_BOX40_1-4/POLE	(1) MS-400/HOR	40000	30 FT. MH 40000 LUMEN MH	0.64	10

"Parkway" Shoebox fixture - bronze

No.	DATE	REVISION	BY	CK	APP

PROJECT : CARY SENIOR CENTER
CLIENT: CAROLINA POWER & LIGHT COMPANY
RALEIGH, NORTH CAROLINA

Layout by C P & L (TONY FERGUSON)
Drawn by WCA Location CARY, N.C.
Checked by PSE Scale 1" = 30'
Date 06/07/99 Dwg. No. CPL-153
PCI Project No. 1999030 Rev. 0 Sht. SL-1 of 1