


NOTE: 1. STRIP LIGHTS SHOWN ON THIS SHEET ARE TO BE INSTALLED IN ATTIC SPACE ADJACENT TO AIR HANDLING UNITS


1 FIRST FLOOR PLAN - POWER
E2.01/SCALE: 1/4" = 1' - 0"

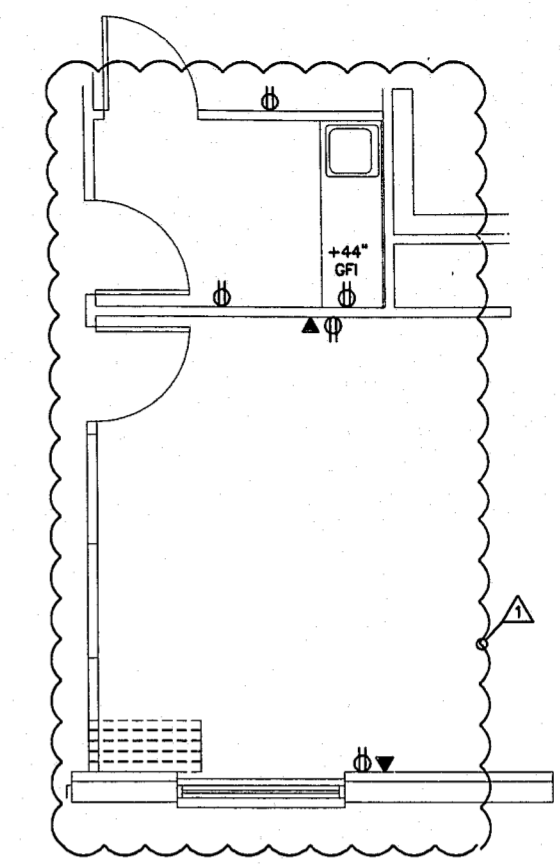


2 PARTIAL FLOORPLAN - ALTERNATE POWER
E2.01/SCALE: 1/4" = 1' - 0"

THIS SWITCH TO BE MOUNTED IN ATTIC SPACE FOR OPERATION OF ATTIC LIGHTS. VERIFY EXACT LOCATION OF ACCESS PANEL.

© 2000 CLINE DAVIS ARCHITECTS EXPRESSLY RESERVES ITS COMMON LAW COPYRIGHT AND OTHER PROPERTY RIGHTS IN THESE PLANS. THESE PLANS ARE NOT TO BE REPRODUCED, CHANGED OR COPIED IN ANY FORM OR MANNER WHATSOEVER, NOR ARE THEY TO BE ASSIGNED TO ANY THIRD PARTY WITHOUT FIRST OBTAINING THE EXPRESS WRITTEN PERMISSION AND CONSENT OF CLINE DAVIS ARCHITECTS, PA.

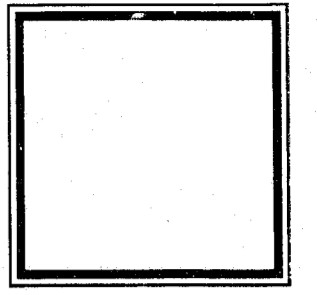

414 West Jones St.
Raleigh, NC 27603
919/833-6413
919/836-1250 FAX
CDA@INTERPATH.COM

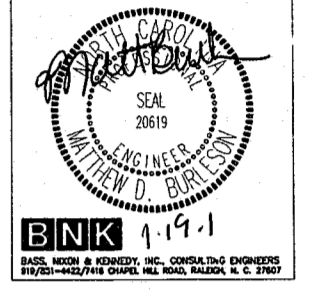

CARY TENNIS CENTER
Cary, North Carolina
Construction Documents

Project	
Date	JAN 19, 2001
Revisions	△ CHANGES
Drawn By	BEB
Checked By	MDB
Content	FIRST FLOOR ELECTRICAL POWER PLAN
Sheet	E2.01