


1 FIRST FLOOR PLAN - LIGHTING
 E2.02 SCALE: 1/4" = 1' - 0"

NOTES:
 CONNECT ALL EMERGENCY AND EXIT LIGHTING AHEAD OF SWITCHES

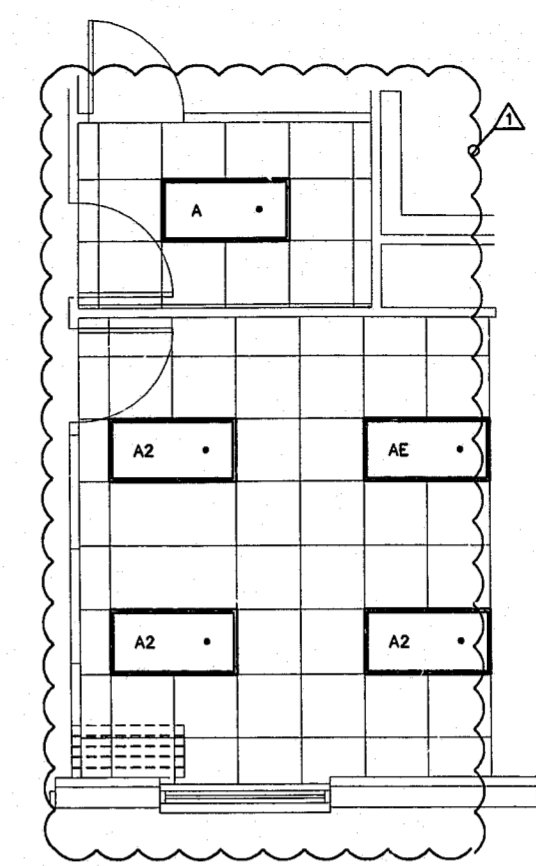

2 PARTIAL FLOORPLAN -
 ALTERNATE LIGHTING
 E2.01 SCALE: 1/4" = 1' - 0"

CLINE DAVIS
ARCHITECTS PA

414 West Jones St.
Raleigh, NC 27603
919/833-6413
919/836-1280 FAX
CDA@INTERPATH.COM

BINK 1-19-1

BINK ROOM & BOARD, INC. CONSULTING ENGINEERS
 8120-102/104 CARRIAGE HOUSE ROAD, WOODLAND, N.C. 27686

CARY TENNIS CENTER
 Cary, North Carolina

Construction Documents

Project	Date JAN 19, 2001
Revisions	△ CHANGES
Drawn By	BEB
Checked By	MDB
Content	FIRST FLOOR ELECTRICAL LIGHTING PLAN
Sheet	E2.02

© 2000 CLINE DAVIS ARCHITECTS EXPRESSLY RESERVES ITS COMMON LAW COPYRIGHT AND OTHER PROPERTY RIGHTS IN THESE PLANS. THESE PLANS ARE NOT TO BE REPRODUCED, CHANGED OR COPIED IN ANY FORM OR MANNER WHATSOEVER, NOR ARE THEY TO BE ASSIGNED TO ANY THIRD PARTY WITHOUT FIRST OBTAINING THE EXPRESSED WRITTEN PERMISSION AND CONSENT OF CLINE DAVIS ARCHITECTS, PA.