


1 FIRST FLOOR PLAN - LIGHTING
 E2.02 SCALE: 1/4" = 1' - 0"



NOTES:
 CONNECT ALL EMERGENCY AND EXIT LIGHTING AHEAD OF SWITCHES



2 PARTIAL FLOORPLAN - ALTERNATE LIGHTING
 E2.01 SCALE: 1/4" = 1' - 0"

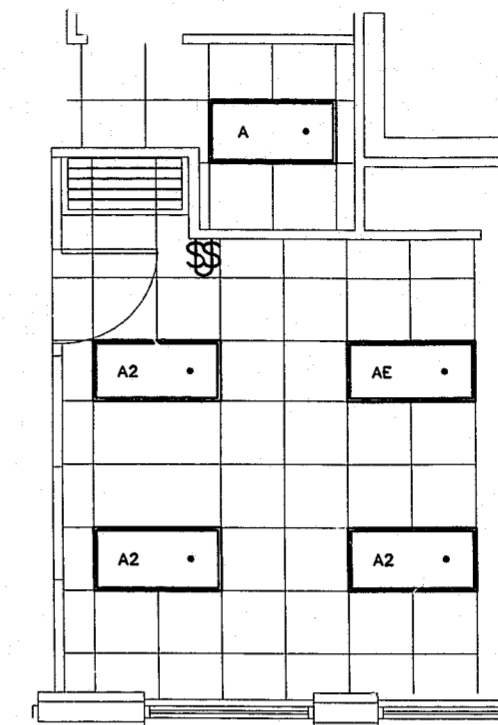

414 West Jones St.
 Raleigh, NC 27603
 919/833-6413
 919/836-1220 FAX
 CDA@INTERPATH.COM

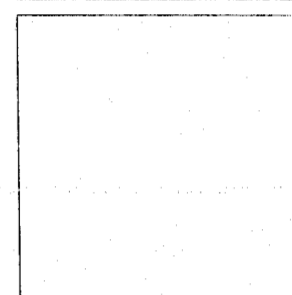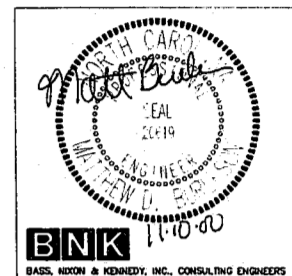

CARY TENNIS CENTER
 Cary, North Carolina
 Construction Documents

Project	
Date	NOV 10, 2000
Revisions	
Drawn By	BEB
Checked By	MDB
Content	FIRST FLOOR ELECTRICAL LIGHTING PLAN
Sheet	E2.02

CO-SP-018-A
APPROVED
 2/2/01

© 2000 CLINE DAVIS ARCHITECTS EXPRESSLY RESERVES ITS COMMON LAW COPYRIGHT AND OTHER PROPERTY RIGHTS IN THESE PLANS. THESE PLANS ARE NOT TO BE REPRODUCED, CHANGED OR COPIED IN ANY FORM OR MANNER WHATSOEVER, NOR ARE THEY TO BE ASSIGNED TO ANY THIRD PARTY WITHOUT FIRST OBTAINING THE EXPRESSED WRITTEN PERMISSION AND CONSENT OF CLINE DAVIS ARCHITECTS, PA.