



**2 PARTIAL FLOORPLAN - ALTERNATE POWER**  
 E2.01 SCALE: 1/4" = 1' - 0"

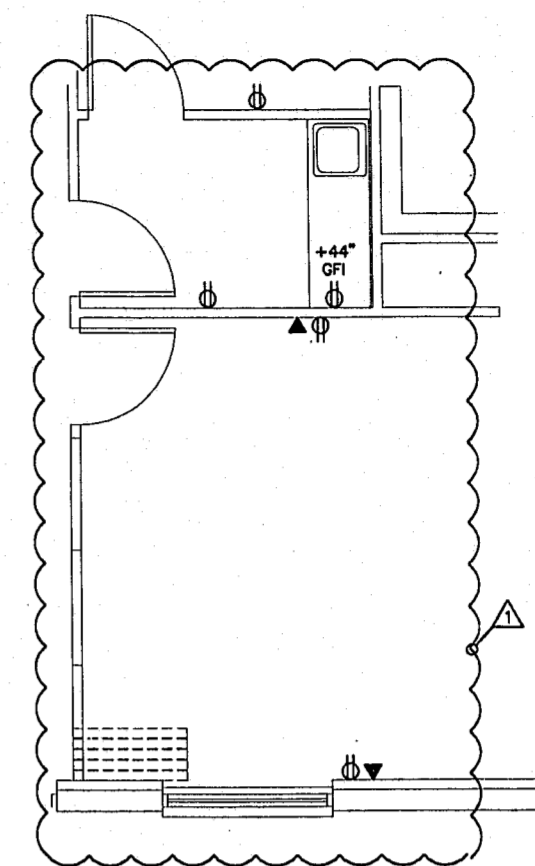


NOTE: 1. STRIP LIGHTS SHOWN ON THIS SHEET ARE TO BE INSTALLED IN ATTIC SPACE ADJACENT TO AIR HANDLING UNITS

**1 FIRST FLOOR PLAN - POWER**  
 E2.01 SCALE: 1/4" = 1' - 0"

© 2005 CLINE DAVIS ARCHITECTS EXPRESSLY RESERVES ITS COMMON LAW COPYRIGHT AND OTHER PROPERTY RIGHTS IN THESE PLANS. THESE PLANS ARE NOT TO BE REPRODUCED, CHANGED OR COPIED IN ANY FORM OR MANNER WHATSOEVER, NOR ARE THEY TO BE ASSIGNED TO ANY THIRD PARTY WITHOUT FIRST OBTAINING THE EXPRESSED WRITTEN PERMISSION AND CONSENT OF CLINE DAVIS ARCHITECTS, PA

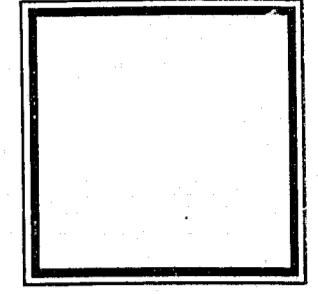

414 West Jones St.  
 Raleigh, NC 27603  
 919/833-6413  
 919/836-1280 FAX  
 CDA@INTERPATH.COM

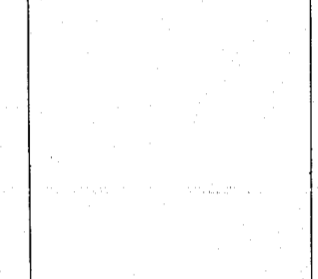

**CARY TENNIS CENTER**  
 Cary, North Carolina  
 Construction Documents

Project	
Date	JAN 19, 2001
Revisions	△ CHANGES
Drawn By	BEB
Checked By	MDB
Content	FIRST FLOOR ELECTRICAL POWER PLAN
Sheet	<b>E2.01</b>