


111 MacKenan Drive  
Cary, N.C. 27511  
PHONE : 919-469-3340  
FAX : 919-467-6008

SEALS

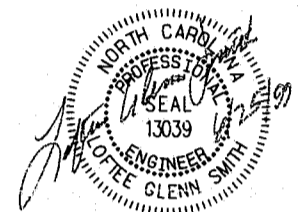

DRAWING TITLE

**OVERALL LIGHTING PLAN**


PROJECT TITLE 98043  
**CENTREGREEN PARK AT WESTON**  
(FORMERLY WESTON COMMONS TRACT 6A)

REVISIONS


NUMBER	DESCRIPTION	DATE
1	PER T.O.C FIRST REVIEW	5/26/98
2	PER T.O.C SECOND REVIEW	6/23/98
3	PER T.O.C THIRD REVIEW	7/27/98
4	ADDENDUM #1 REVISIONS	8/14/98
5	MRB OPTIONS	8/28/98
6	ADDENDUM #2 REVISIONS	2/17/99
7	ADDENDUM #3 REVISIONS	4/1/99
8	RESUBMIT TO TOWN OF CARY	4/12/99
9	PER T.O.C FIRST RE-REVIEW	5/10/99

DRAWN BY DW  
CHECKED BY LGS  
DATE ISSUED 4/13/1998  
SCALE 1"=100'



SHEET NO. **5**  
OF

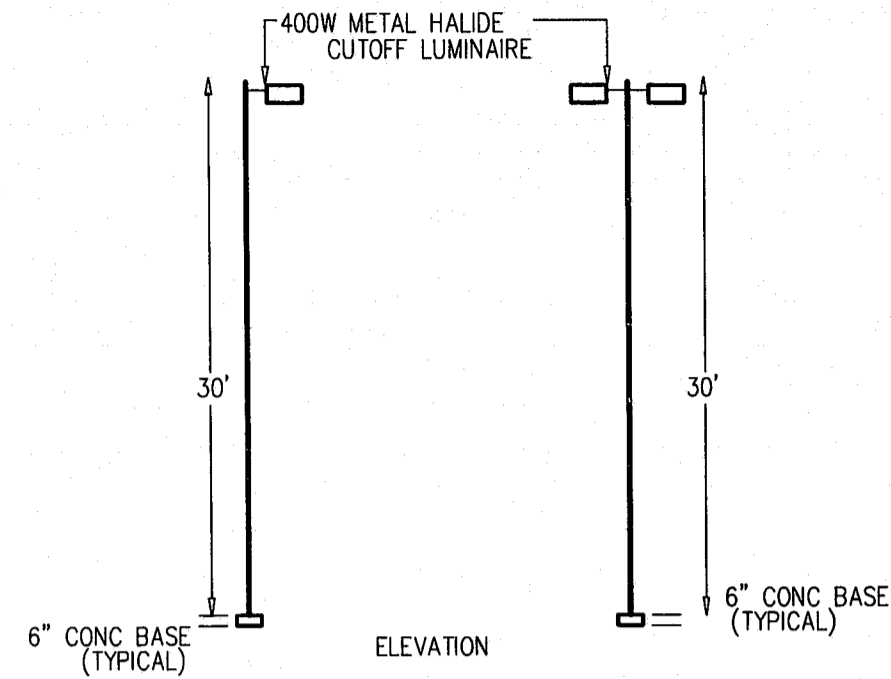


**LIGHTING LEGEND**

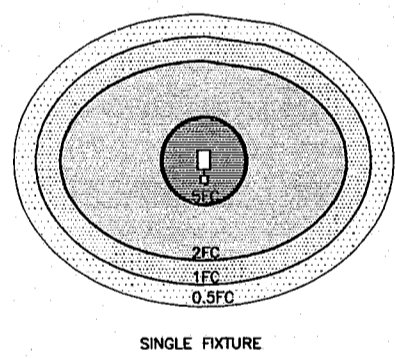

**TYPICAL FOOTCANDLES**

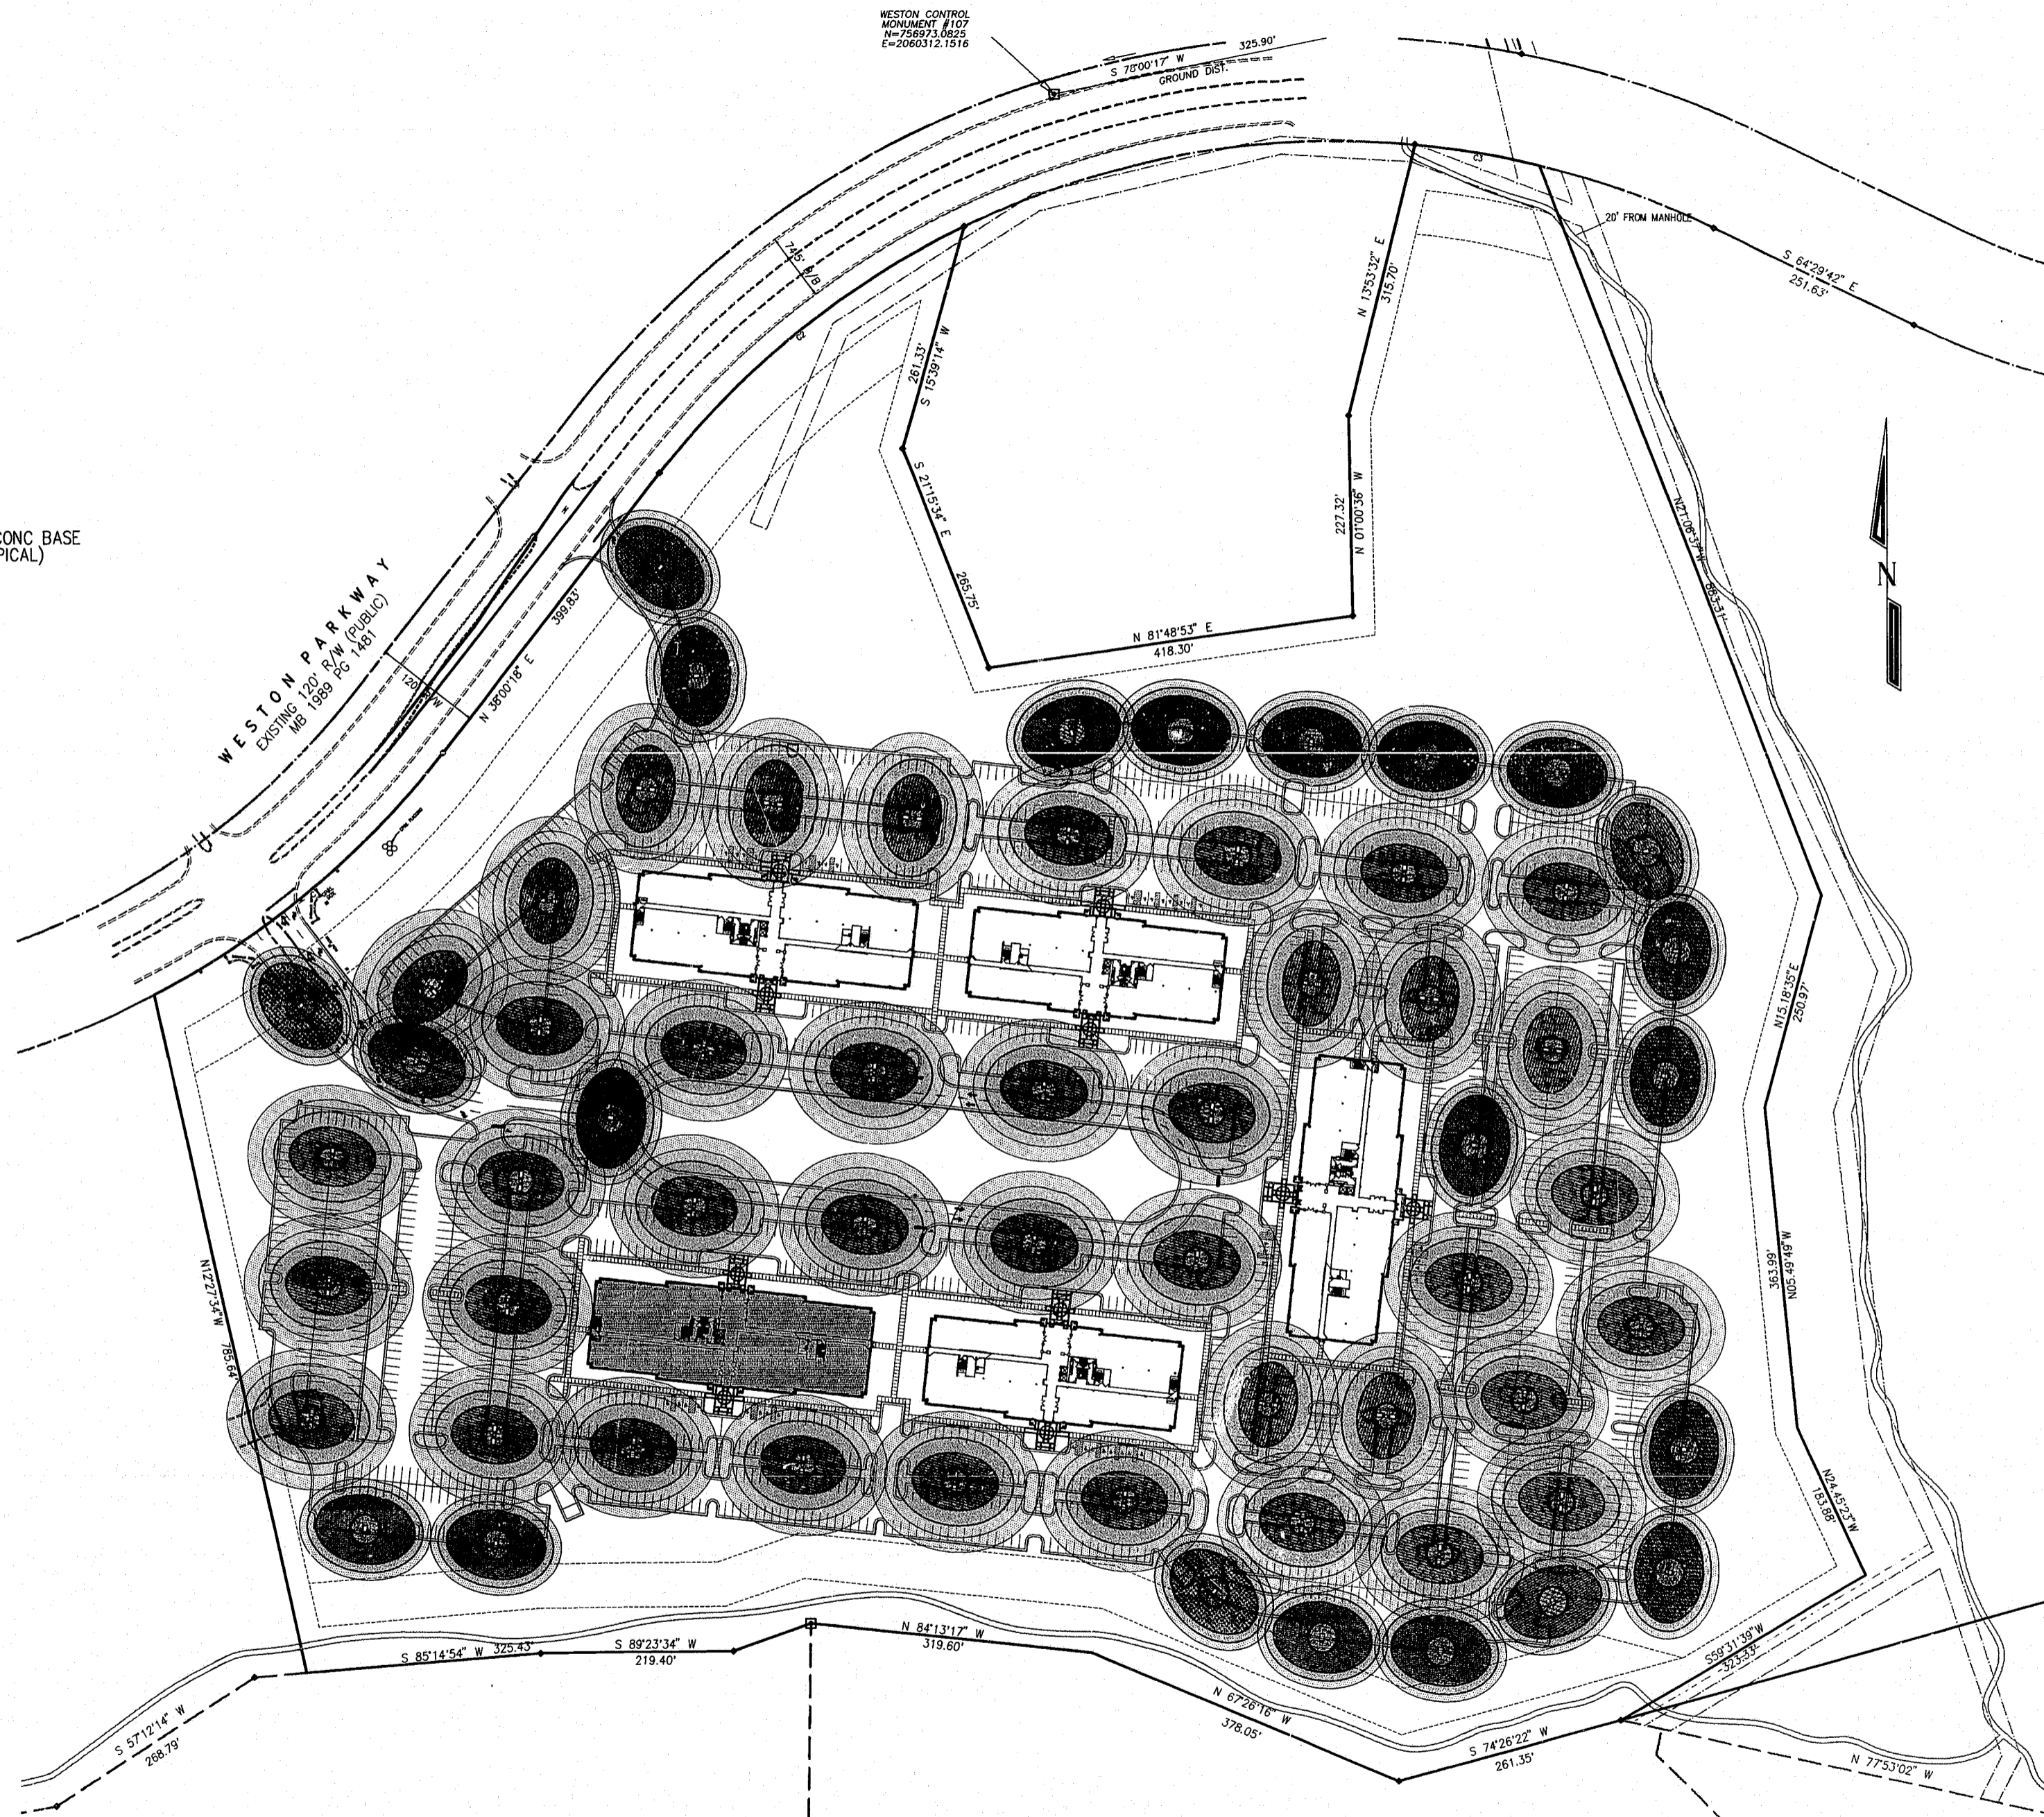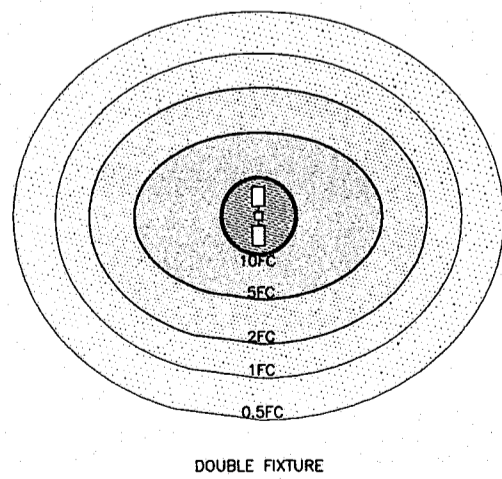

 99-67-078  
**APPROVED**  
60 7/1/99  
TM 7/2/99



K:\CADD\98\98043\plan.pro Mon May 3, 1999 03:27:46PM WITHERS & RAVENEL ENGINEERING & SURVEYING