



CALCULATION SUMMARY						
AREA NAME	DIMENSIONS	UNIT NAME	AVG	MAX	MIN	AVG/UNIT
New Area	(+)	20	31	06		347


ILLUMINATION SCHEDULE						
TYPE	SYMBOL	DESCRIPTION	TYPE	HEIGHT	FOOT CANDLE	FOOT CANDLE
04		30' POLE STREET FIXTURE	400 WATT	30	1.1	0.64
		METAL HALIDE BULB	4000			0.64

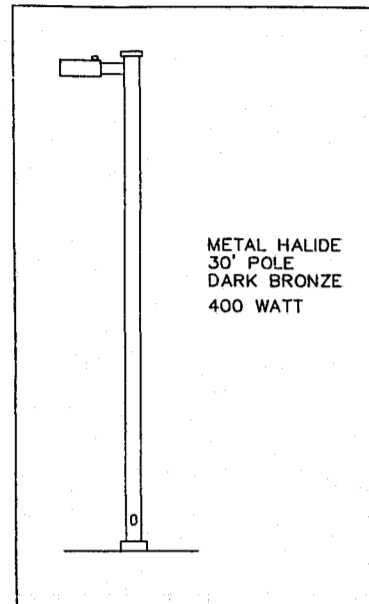

NOTE: ALL CONSTRUCTION SHALL BE PERFORMED IN ACCORDANCE WITH THE CURRENT TOWN OF CARY STANDARD SPECIFICATIONS AND DETAILS.

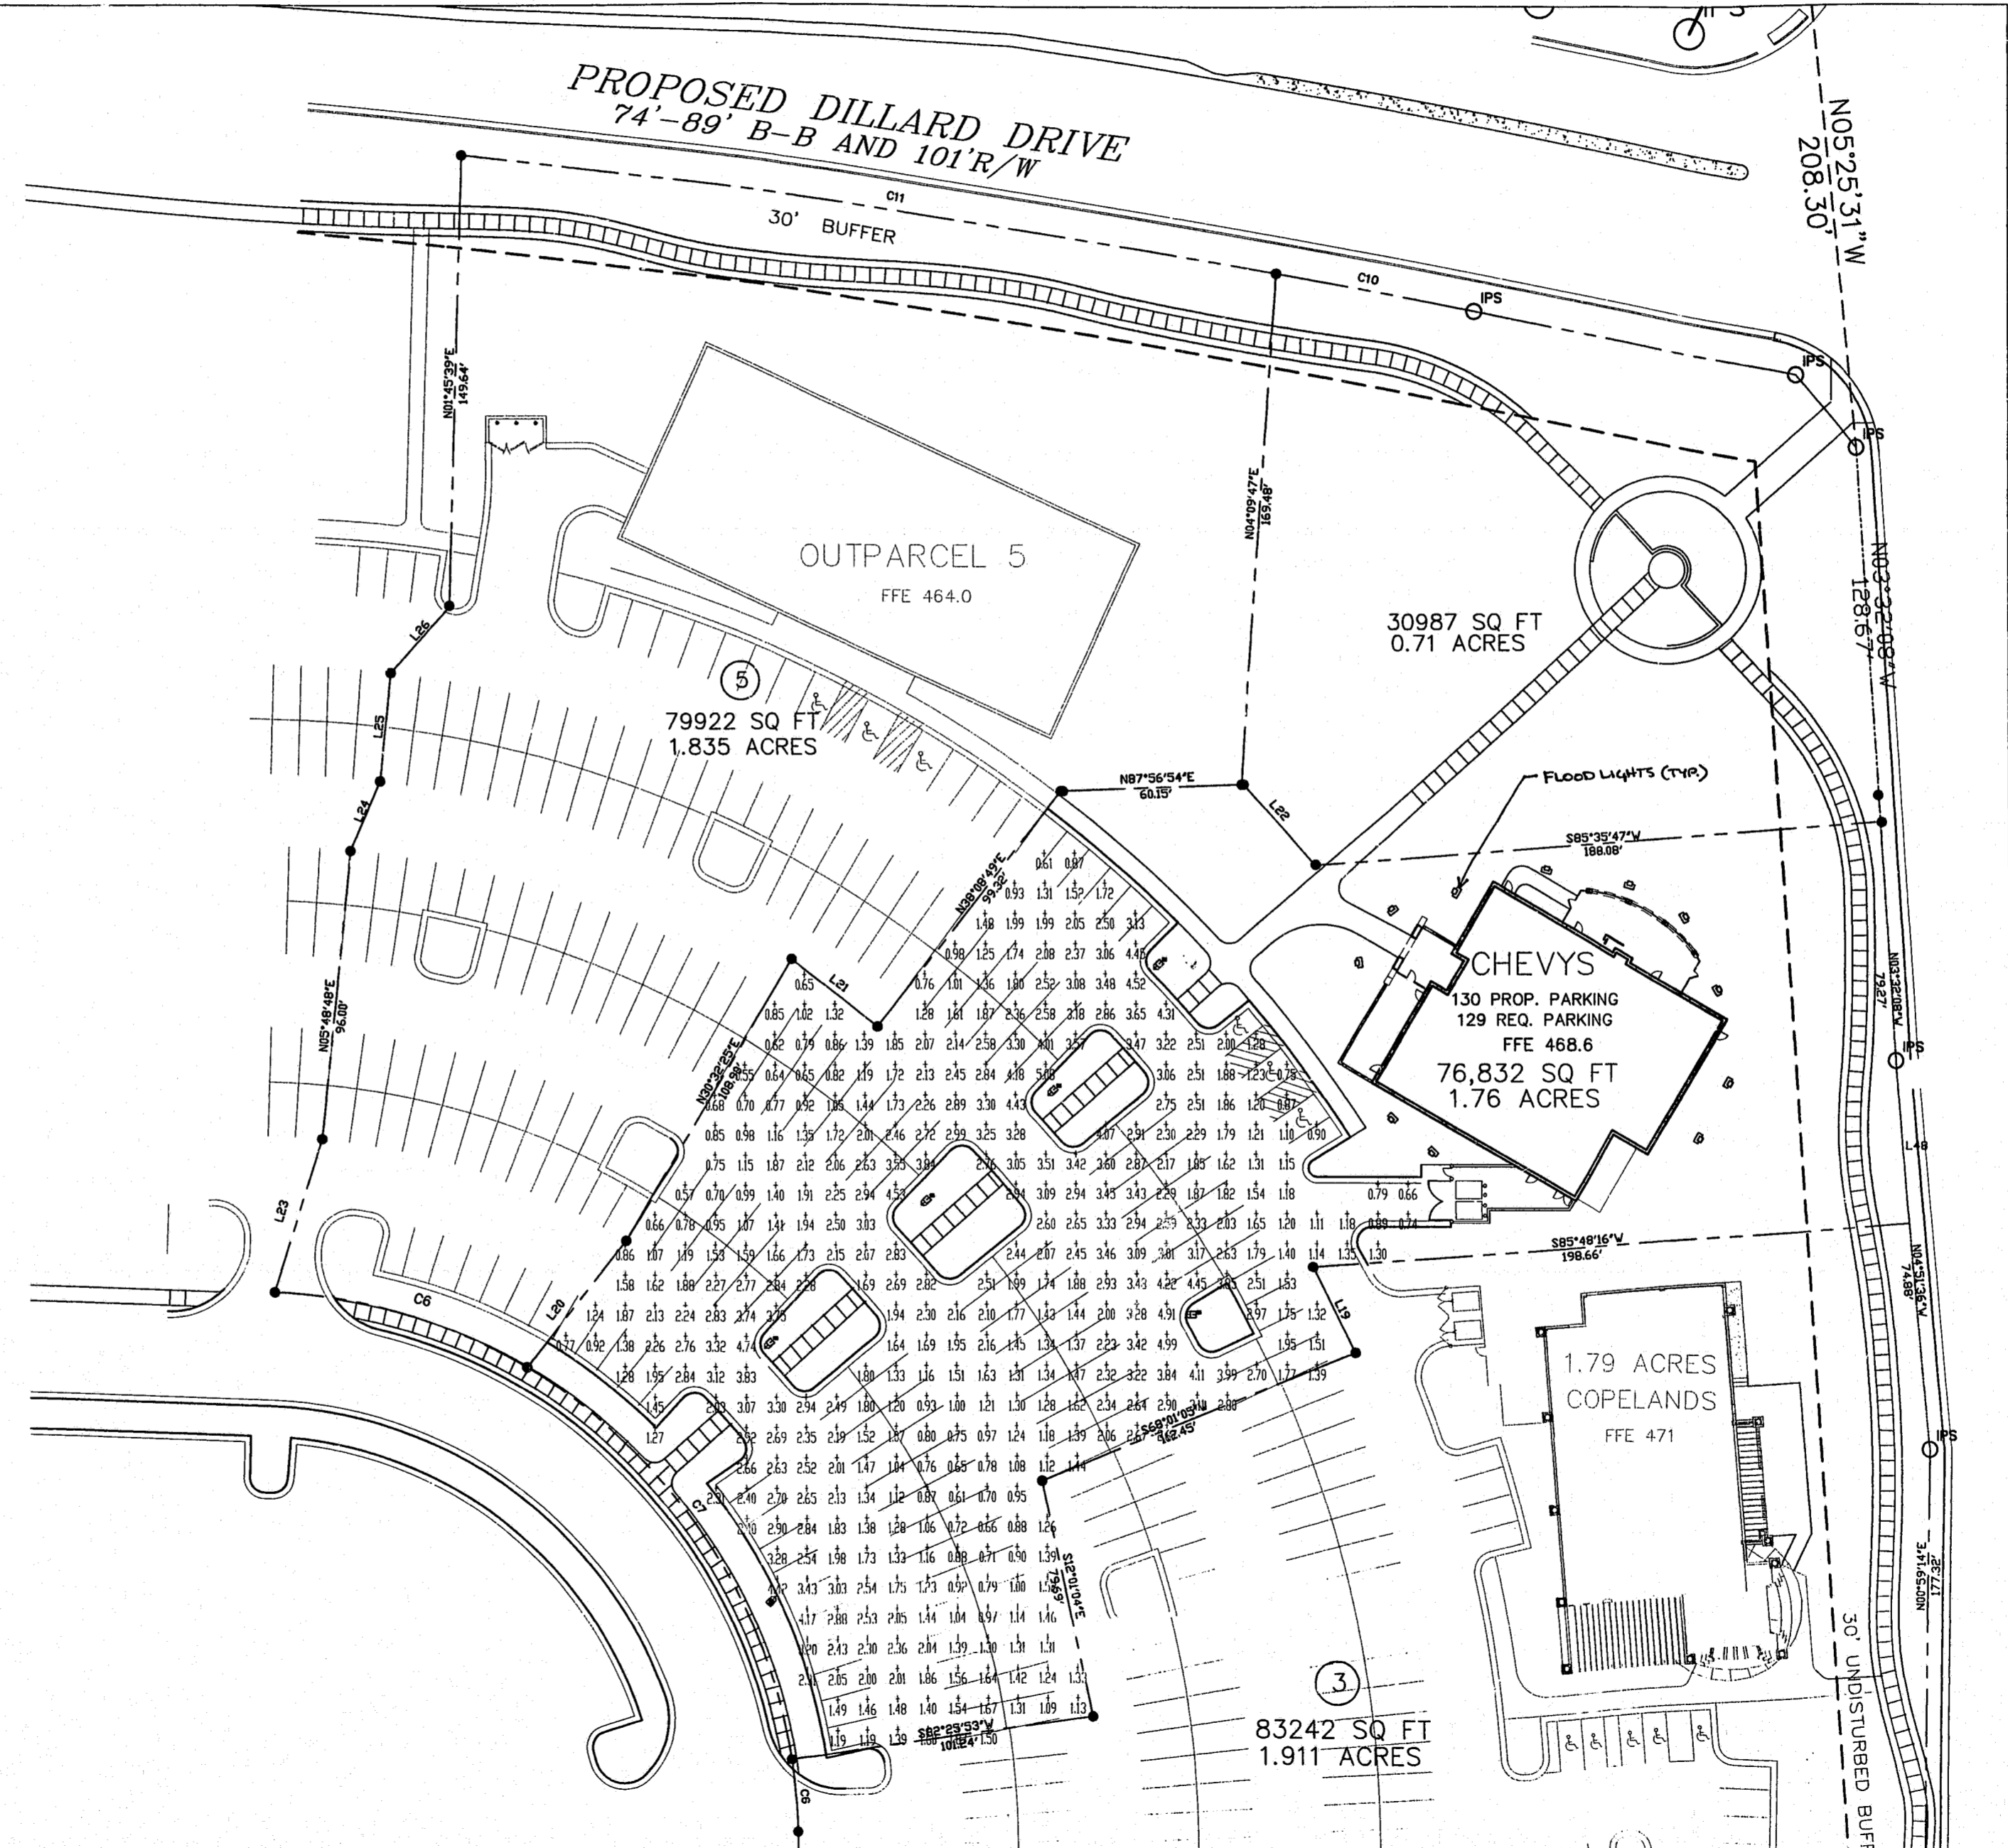

THE ROSE GROUP
ENGINEERS 821-101 Hutton St. Raleigh, NC 27608
PLANNERS (919) 829-0555
SURVEYORS (919) 829-9335 email: rosegrp.com

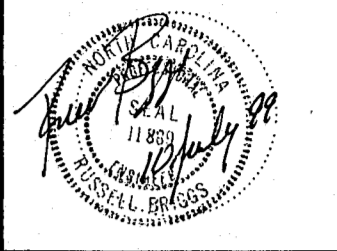

REVISIONS		
NO.	DATE	DESCRIPTION

PROJECT NAME
CHEVY'S FRESH MEX

2240 WALNUT ST.
CARY, NC

OWNER

PROJECT MANAGER	RJB
DRAWN BY	KRM
APPROVED BY	RJB
FILE NAME	CHEVYS-5_10.dwg
PROJECT NUMBER	98209
PLOT DATE	5-10-99

PROJECT INFORMATION

PROJECT MANAGER	RJB
DRAWN BY	KRM
APPROVED BY	RJB
FILE NAME	CHEVYS-5_10.dwg
PROJECT NUMBER	98209
PLOT DATE	5-10-99

SHEET NAME
LIGHTING PLAN

DRAWING SCALE
HORIZONTAL = 1"=30'

DATE
7-12-99

SHEET NUMBER
L11 OF 6