


THE ROBERTS/STACY GROUP
 ARCHITECTURE • PLANNING
 4011 WESTCHASE BUILDE VARD
 SUITE 100
 RALEIGH, NORTH CAROLINA 27667
 TELEPHONE: 919-831-1831
 FACSIMILE: 919-831-1833

BEA
 Baker Engineering Associates, P.A.
 3101 GUESS ROAD, SUITE 1
 DURHAM, NORTH CAROLINA 27705
 PHONE NO. 919-477-9202 FAX: 919-477-9202

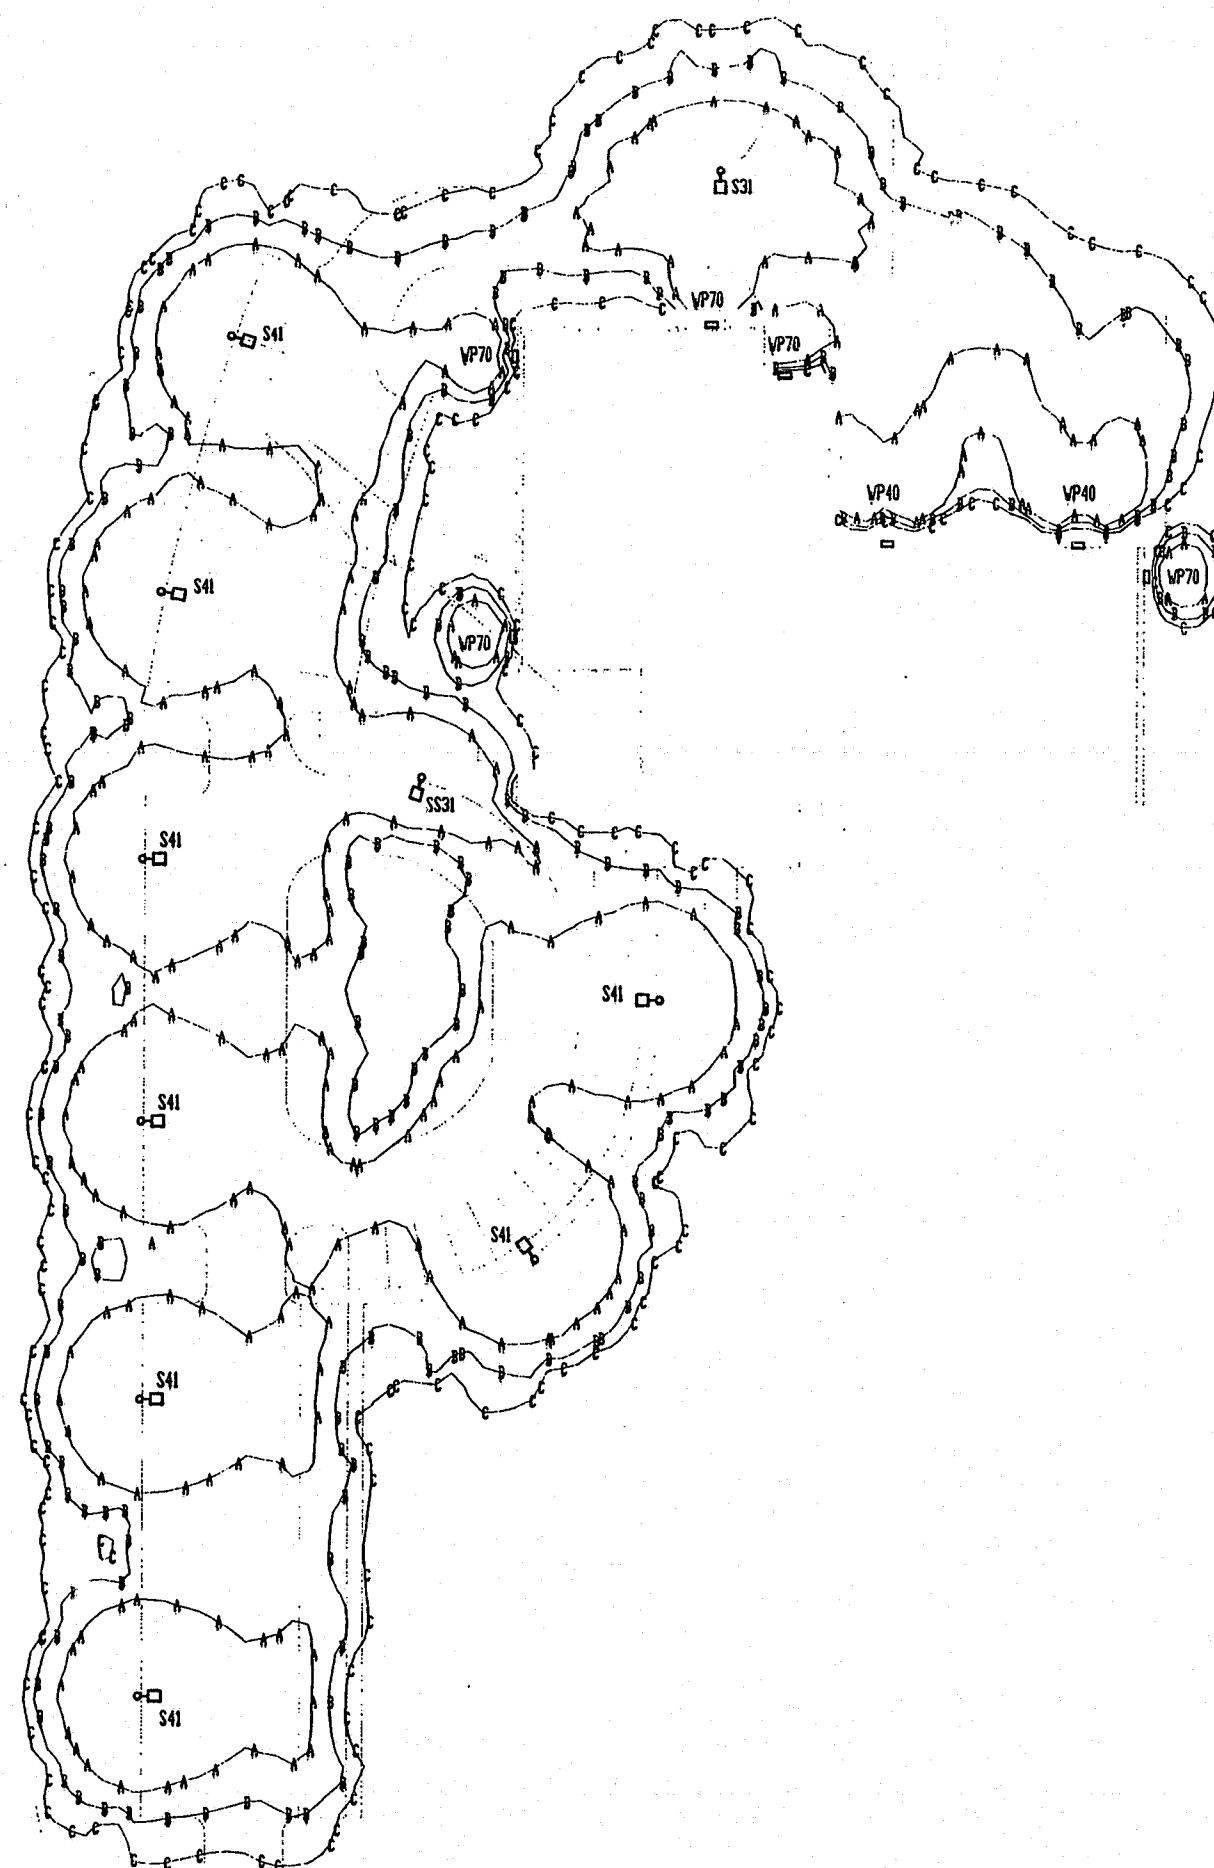

SITE PLAN
 SCALE: 1" = 40'



| LIGHTING CONTOUR LEVELS | |
|-------------------------|-------|
| MARK | LEVEL |
| A | 20 FC |
| B | 10 FC |
| C | 05 FC |

| POLE LIGHTING SCHEDULE | | | | | | | |
|------------------------|--------|-------|-------|------|----------|-------------|--------------------------|
| MARK | SYMBOL | LAMPS | | | DIST. | POLE HEIGHT | WALL HEIGHT |
| | | NO. | WATTS | TYPE | | | |
| S51 | □ | 1 | 400 | M.H. | TYPE III | 30'-0" | - |
| S41 | □ | 1 | 400 | M.H. | TYPE IV | 30'-0" | - |
| S531 | □ | 1 | 250 | M.H. | TYPE III | 15'-0" | - |
| WP10 | □ | 1 | 10 | M.H. | N/A | - | 10'-0" BY EXTERIOR DOORS |
| WP40 | □ | 1 | 400 | M.H. | N/A | - | 20'-0" ON BRICK WALL |

TOWN OF CARY
 COMMUNITY
 CENTER NO. 2
 AT FRED G. BOND METRO PARK
 CARY, NORTH CAROLINA

SITE
 LIGHTING
 PLAN

DRAWN BY: RDH II

APPROVED BY: SMM

SHEET NUMBER

SL-1.0

DATE: 6/30/97

PROJECT NUMBER: 176.01

6/30/97 176.01