

CONSTRUCTION DRAWINGS  
 FOR: THE ESTATES AT YATES POND  
 TEMPORARY PUMP STATIONS & FORCE MAIN  
 W&R PROJECT NO.: 2140308.00


# CONSTRUCTION PLANS

# THE ESTATES AT YATES POND

# TEMPORARY PUMP STATIONS & FORCE MAIN

1098 & 1129 WHITE OAK CHURCH ROAD  
 TOWN OF CARY, NORTH CAROLINA

FEBRUARY 03, 2015

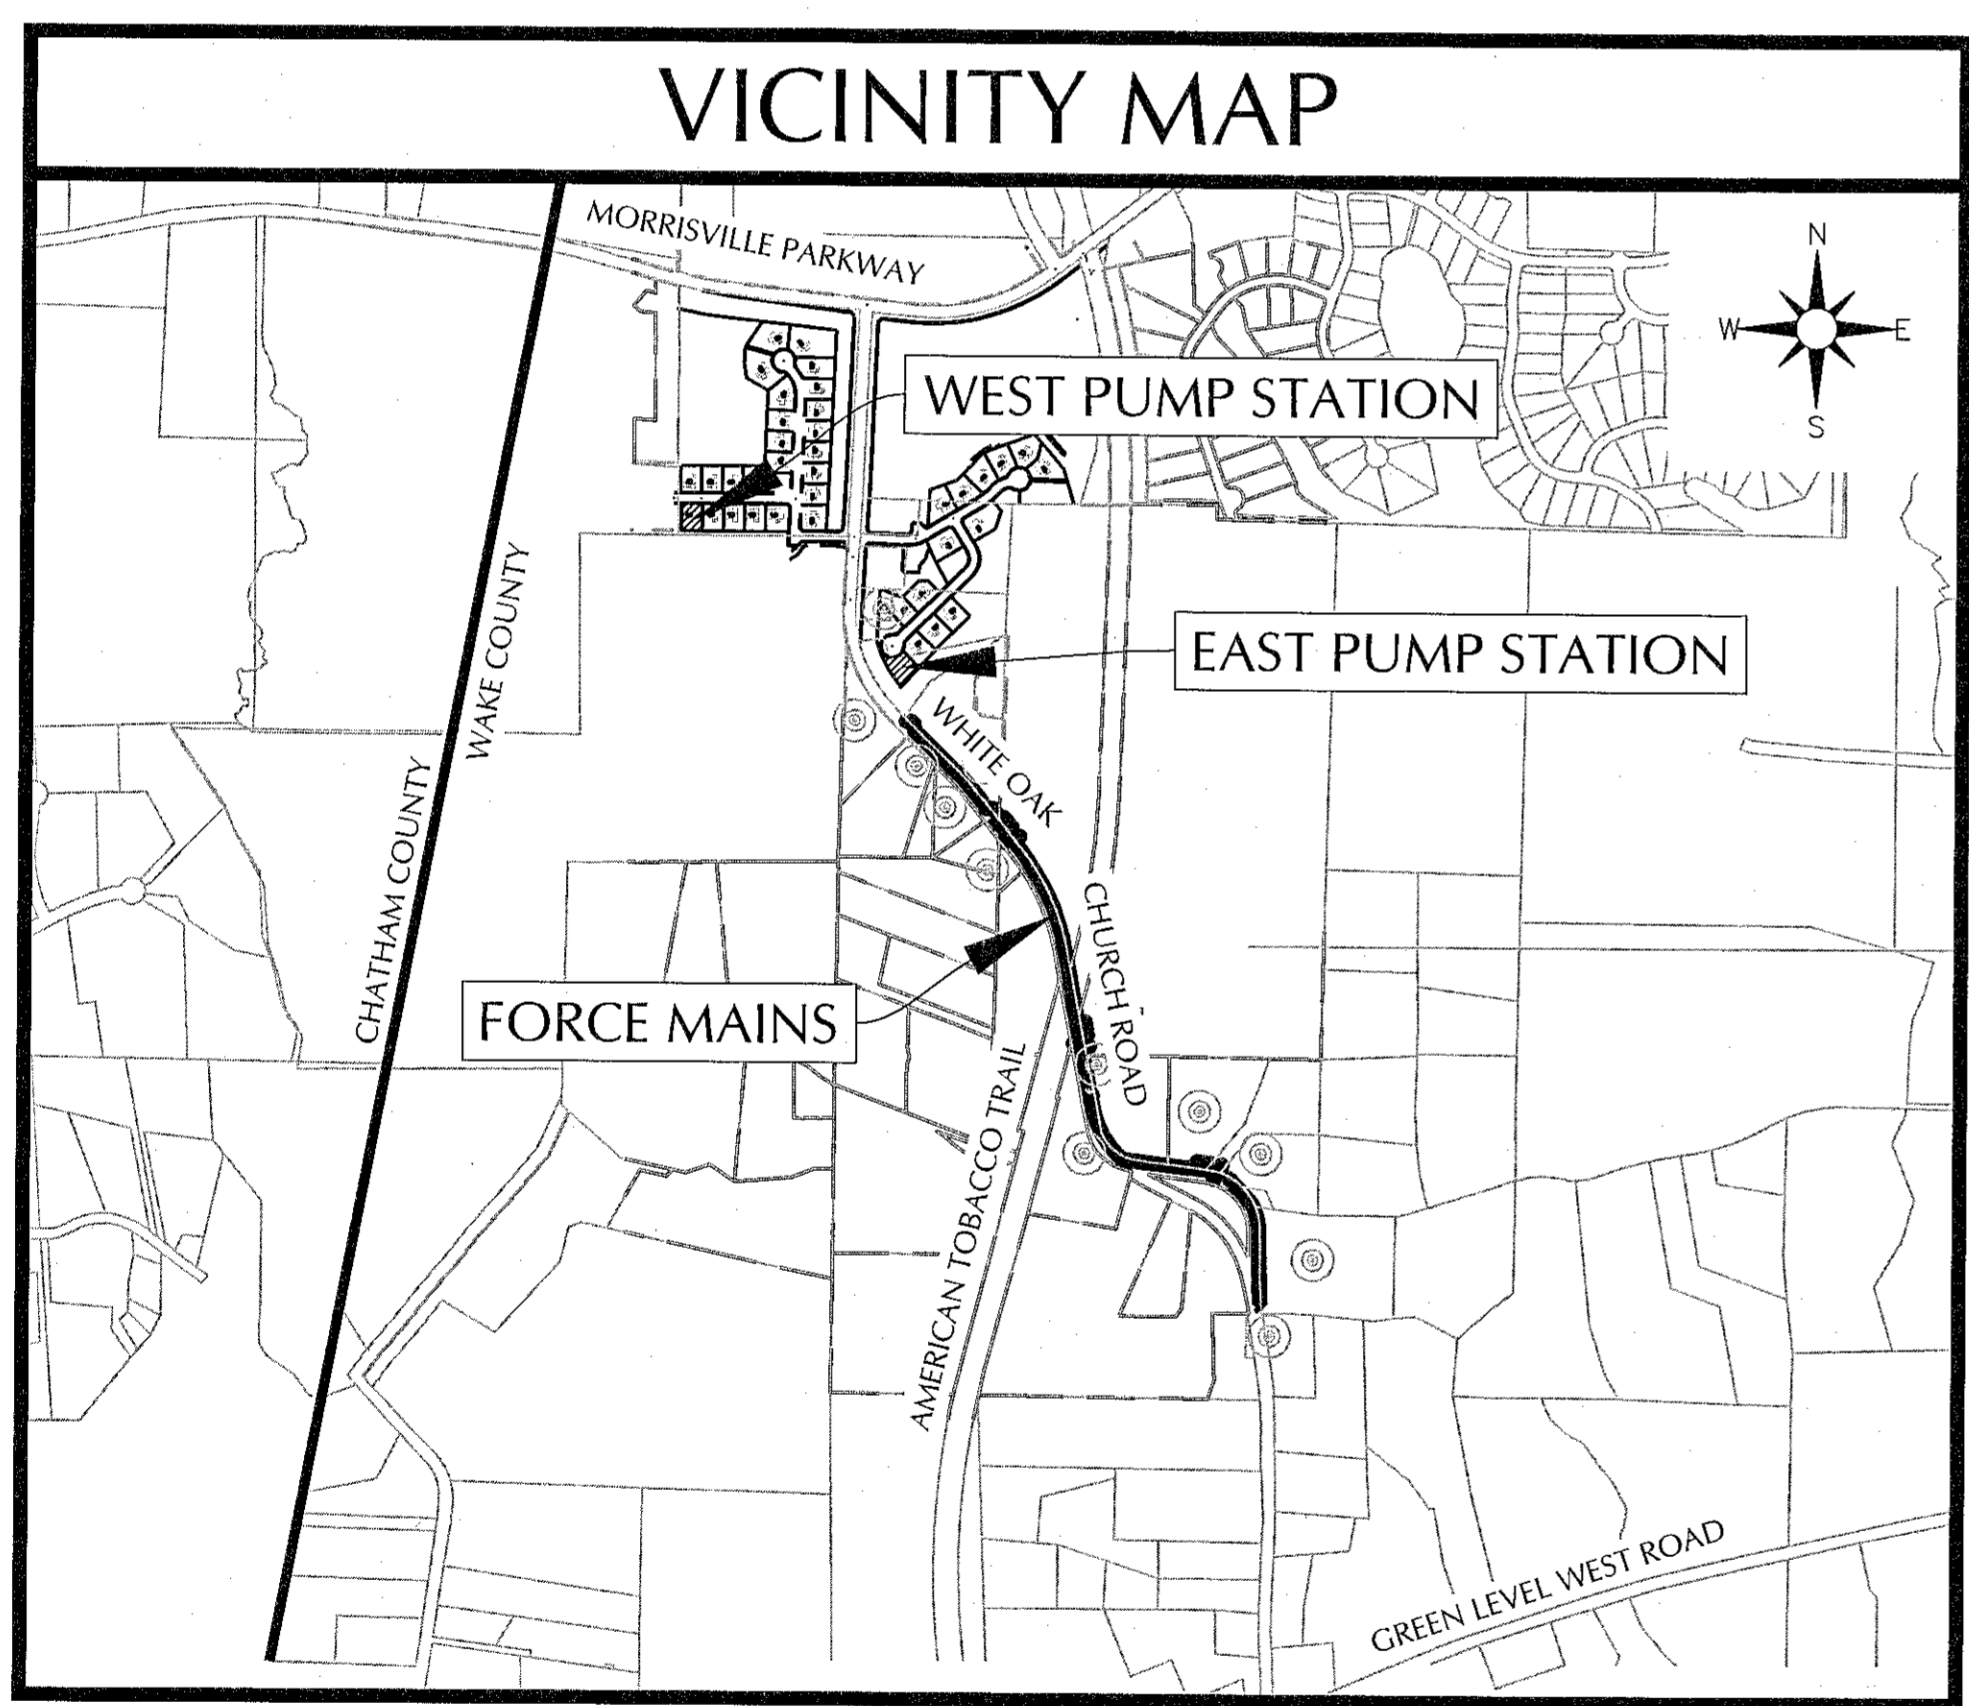

SCALE: 1"=2,000'

SHEET LIST TABLE	
SHEET NUMBER	SHEET TITLE
01	COVER SHEET
G-1	GENERAL NOTES & LEGEND
G-2	OVERALL PLAN
WPS-1	WEST PUMP STATION SITE PLAN
WPS-2	WEST PUMP STATION EROSION CONTROL PLAN
WPS-3	WEST PUMP STATION PLAN VIEW
WPS-4	WEST PUMP STATION SECTION VIEW
WPS-5	WEST PUMP STATION CHEMICAL FEED SYSTEM
WPS-6	WEST PUMP STATION ELECTRICAL LAYOUT
WPS-7	WEST PUMP STATION ELECTRICAL DETAILS
WPS-8	WEST PUMP STATION LANDSCAPE PLAN
EPS-1	EAST PUMP STATION SITE PLAN
EPS-2	EAST PUMP STATION EROSION CONTROL PLAN
EPS-3	EAST PUMP STATION PLAN VIEW
EPS-4	EAST PUMP STATION SECTION VIEW
EPS-5	EAST PUMP STATION ELECTRICAL LAYOUT
EPS-6	EAST PUMP STATION ELECTRICAL DETAILS
EPS-7	EAST PUMP STATION LANDSCAPE PLAN
FM-1	STA. 10+00 TO 22+00
FM-2	STA. 22+00 TO 36+00
FM-3	STA. 36+00 TO END
D-1	EROSION CONTROL DETAILS
D-2	CONSTRUCTION DETAILS
D-3	CONSTRUCTION DETAILS
D-4	CONSTRUCTION DETAILS
D-5	CONSTRUCTION DETAILS

**DEVELOPER/OWNER**

NORTHWEST COMMUNITY CHURCH  
 7712 CARPENTER FIRE STATION RD  
 CARY NC 27519  
 ATTN: MR. JOEL CARPENTER


**PREPARED BY:**

**WITHERS & RAVENEL**  
 ENGINEERS | PLANNERS | SURVEYORS  
 115 MacKenan Drive Cary, North Carolina 27511 tel: 919-469-3340 www.withersravenel.com License No. C-0382



KNOW WHAT'S BELOW.  
 CALL BEFORE YOU DIG.

Cary Project Number 14-SP-065  
 Cary HTE #: 15-0489  
**Approved by the Town of Cary**  
 Development Review Committee  
 Planner: *Kathleen* for MS Date: 3 Mar 2015

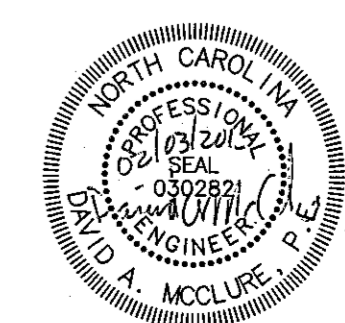

Town of Cary  
 Engineering Department  
 Approved Utility Extensions

Sewer permit # **PS15001**  
 By: *James A. McClure* 2/10/15

K:\14-0200\14-0200-northwest community church PA\03\03\03 - COVER.dwg - Tuesday, February 03, 2015 11:17:57 AM - MCLURE, DAW