

THE GROVE AT CARY PARK (PARCEL MR-9)

Cary, North Carolina

Site Plan Submittal (01-SB-012)

November 5, 2001

Revised: March 4, 2002

April 22, 2002

June 3, 2002

developer/owner:

REGENCY HOUSING
2700 WYCLIFF ROAD
RALEIGH, NC 27607
510-9660

consultants:

Land Planner/Landscape Architect:
JERRY TURNER & ASSOCIATES, INC.
RALEIGH, NORTH CAROLINA

Engineer:


WITHERS AND RAVENEL
CARY, NORTH CAROLINA

index

EXISTING CONDITIONS	1
OVERALL LAYOUT PLAN	2
SITE DETAILS	3, 3.1
LANDSCAPE PLAN	4
ACTIVITY CENTER LANDSCAPE PLAN	5
LANDSCAPE DETAILS AND PLANT LIST	6
OVERALL GRADING & STORM DRAINAGE	C-1
DETAILED GRADING PLAN	C-1.1
DETAILED GRADING PLAN	C-1.2
EROSION CONTROL PLAN	C-2
UTILITY PLAN	C-3
SANITARY SEWER PROFILES	C-4
LIGHTING PLAN	C-5
LIGHTING DETAILS	C-6
STORM & EROSION CONTROL DETAILS	C-7
UTILITY & ROADWAY DETAILS	C-8
POND DETAILS	C-9
STORM DRAINAGE HYDRAULIC PROFILES	C-10
ARCHITECTURALS	
WALL DETAILS	
BRIDGE DETAILS	

vicinity map

scale: 1"=500'

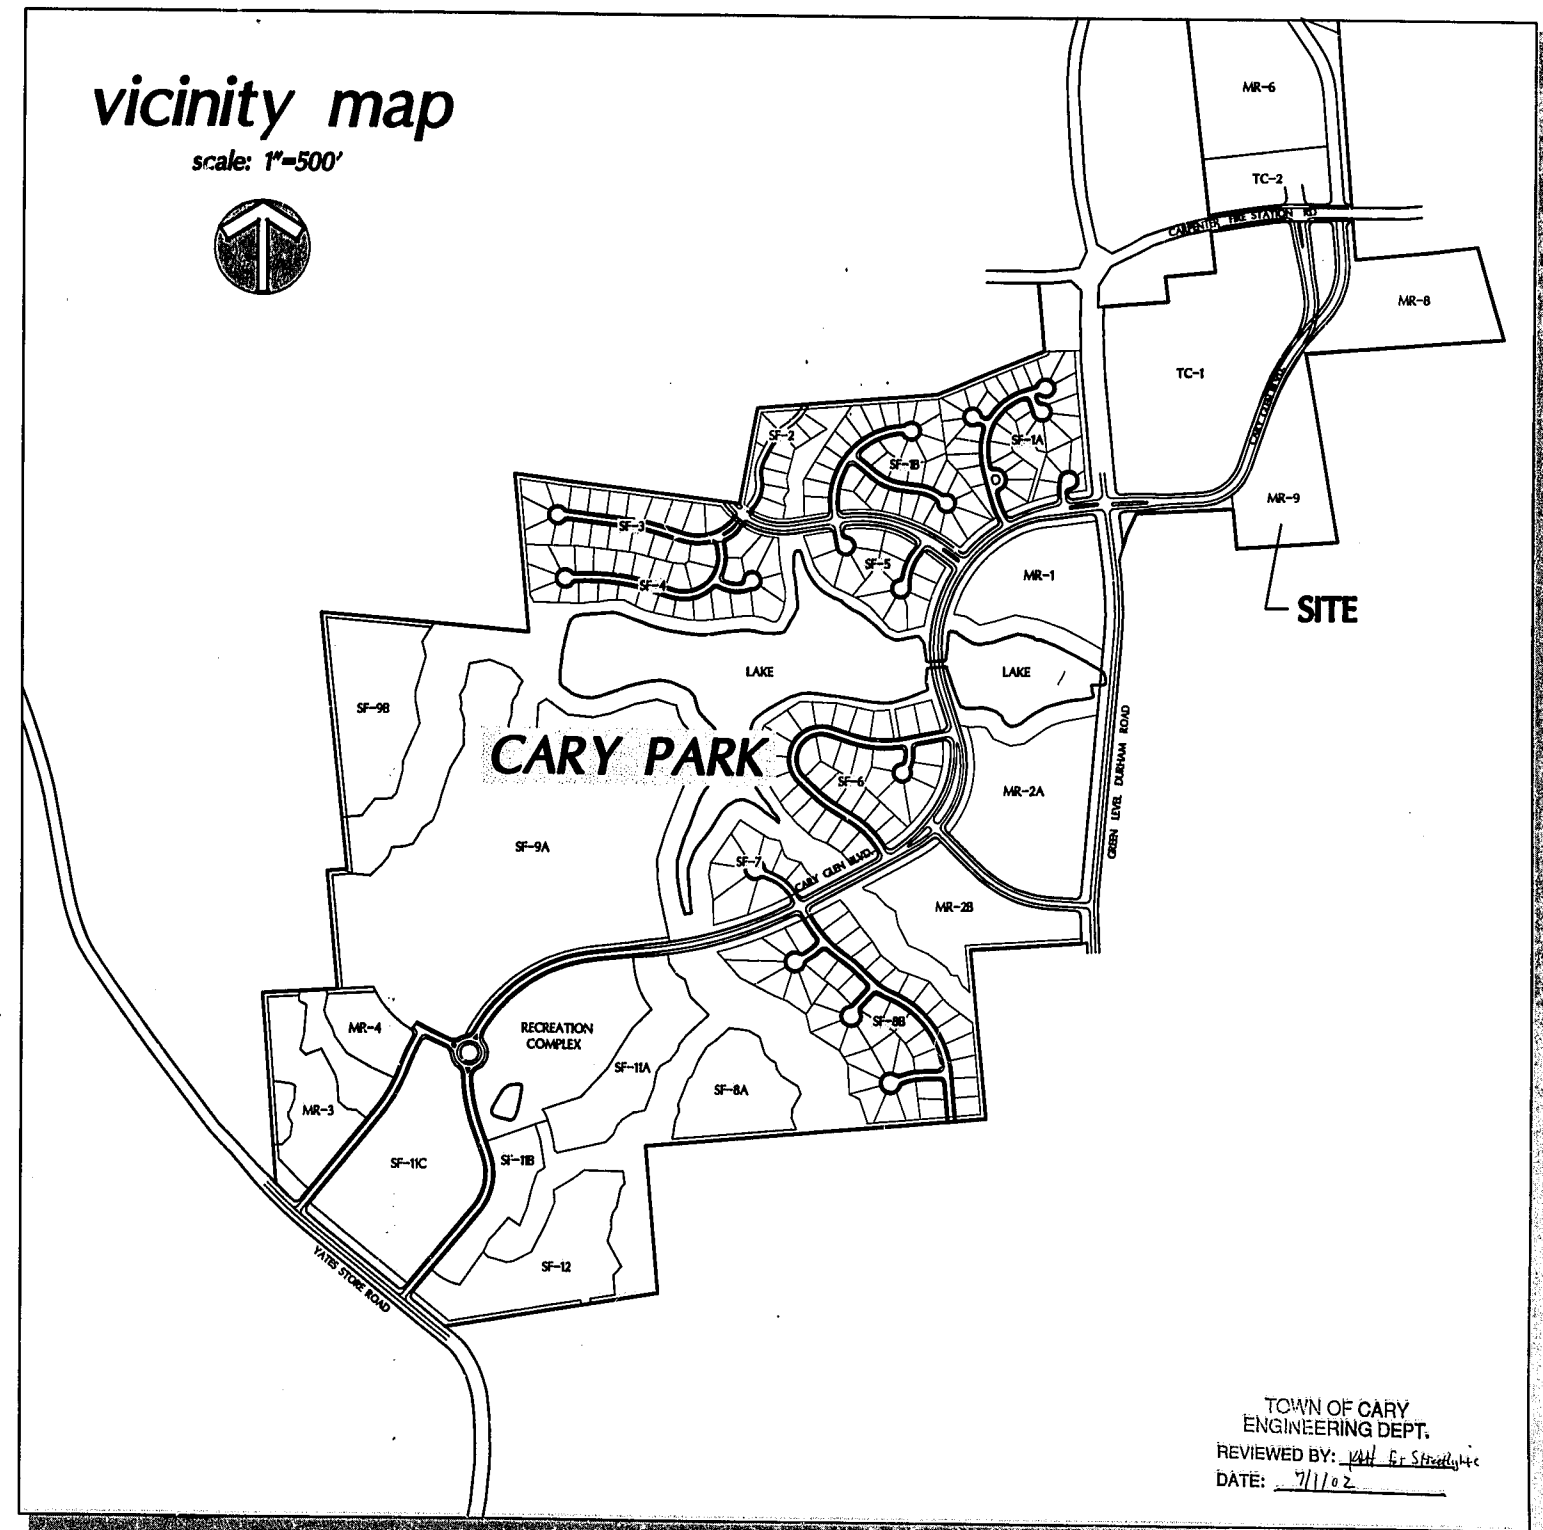

TOWN OF CARY
ENGINEERING DEPT.
REVIEWED BY: *[Signature]*
DATE: 7/1/02

01-SB-012
APPROVED
TOWN OF CARY
Approved by *[Signature]* Date 5-22-02
Planning *[Signature]* Date 10-13-02
Engineering *[Signature]* Date 6-12-02
ST 6.13.02