
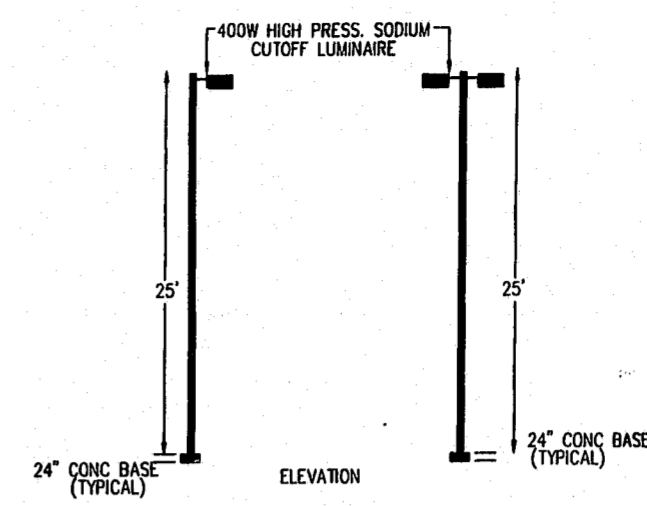


© JERRY TURNER & ASSOCIATES, INC. THIS DOCUMENT IS THE PROPERTY OF JERRY TURNER & ASSOCIATES. ALL RIGHTS ARE RESERVED AND ANY POSSESSION, REPRODUCTION, OR OTHER USE OF THIS DOCUMENT WITHOUT THE PRIOR PERMISSION OF JERRY TURNER & ASSOCIATES IS EXPRESSLY PROHIBITED.

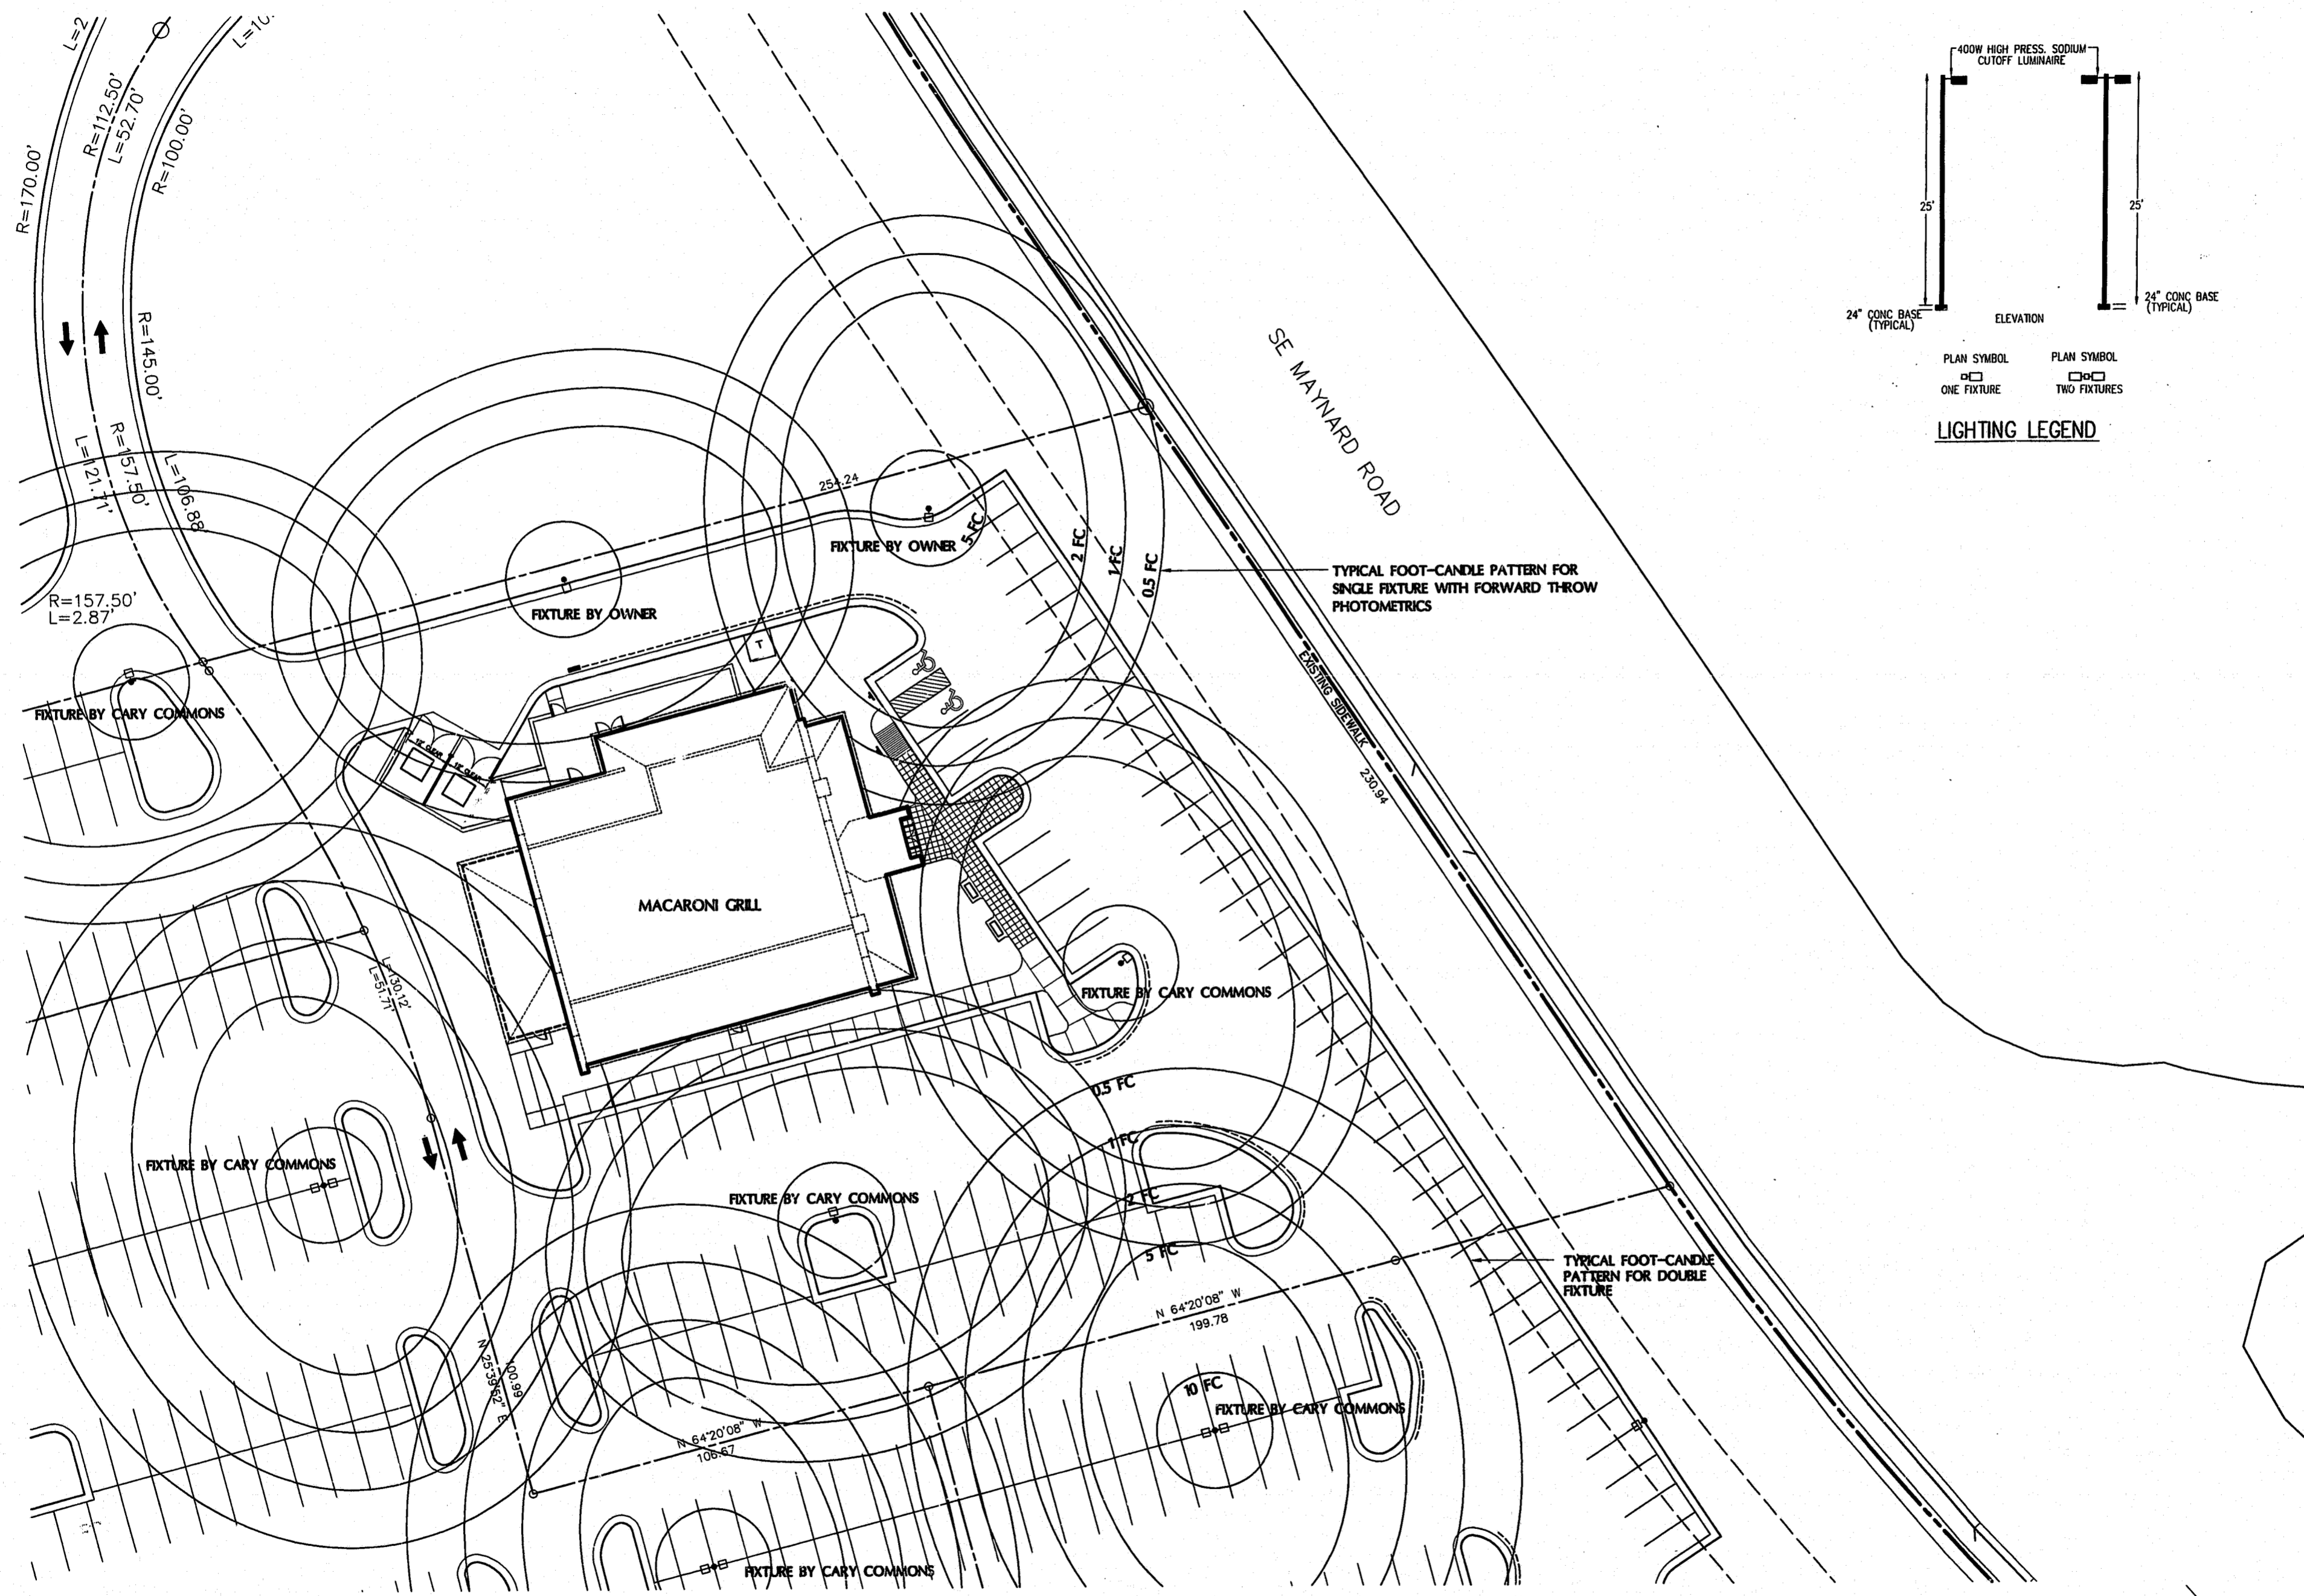

PLAN SYMBOL
 □ ONE FIXTURE
 □ TWO FIXTURES

LIGHTING LEGEND

JTA
JERRY TURNER & ASSOCIATES

LANDSCAPE ARCHITECTURE
 LAND PLANNING
 ENVIRONMENTAL DESIGN

905 JONES FRANKLIN ROAD
 RALEIGH, NORTH CAROLINA 27606
 (919) 851-7150

62 S.E. 6TH AVENUE
 DELRAY BEACH, FLORIDA 33483
 (407) 276-0453

PROJECT

**MACARONI GRILL
 CARY COMMONS**

CARY, NORTH CAROLINA

REVISIONS


- 6/19/95 DUMPSTER RELOC. & ENTRY WALK
- 6/28/95 RELOC. ISLAND, DUMPSTER & TWO LIGHT FIXTURES

DRAWN	CHECKED
TAS	LH
SCALE	DATE
1"=20'	5/26/95
TITLE	

LIGHTING PLAN

FILE NO.	JOB NO.
170	2093.05
SEAL	SHEET NO.

Professional seal for Jerry Turner & Associates, North Carolina, with the number 3.

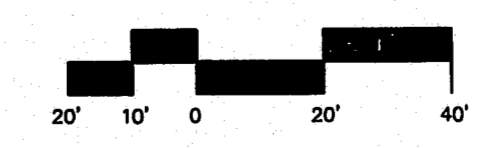

CONSTRUCTION DRAWING