


BROWN & JONES ARCHITECTS, INC.
 14 N. Boylan Ave. Raleigh, NC 27603
 Tel. (919) 831-2625 Fax 831-2626

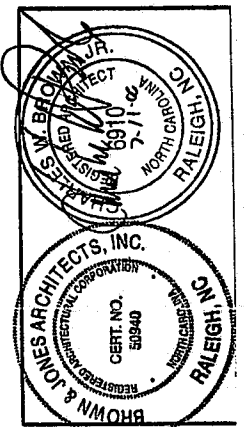

**PRESTONWOOD COUNTRY CLUB
 TENNIS COURTS, HALF-WAY SHELTER**
 Cary / Morrisville, North Carolina
 Wake County, North Carolina


FILE: 9923\A100.dcs
 DATE: 07/10/00
 DRAWN BY: cwb/new
 B&JA JOB #: 9923

THESE DRAWINGS ARE THE PROPERTY OF BROWN & JONES ARCHITECTS, INC. AND MAY NOT BE REPRODUCED WITHOUT WRITTEN PERMISSION. COPYRIGHT, 2000 BY BROWN & JONES ARCHITECTS, INC. ALL RIGHTS RESERVED.


A4.01

LEGEND

- HVAC EXHAUST GRILLE
- UNIT HEATER
- 1' X 4' FLUORESCENT FIXTURE
- RECESSED DOWNLIGHT
- PADDLE FAN

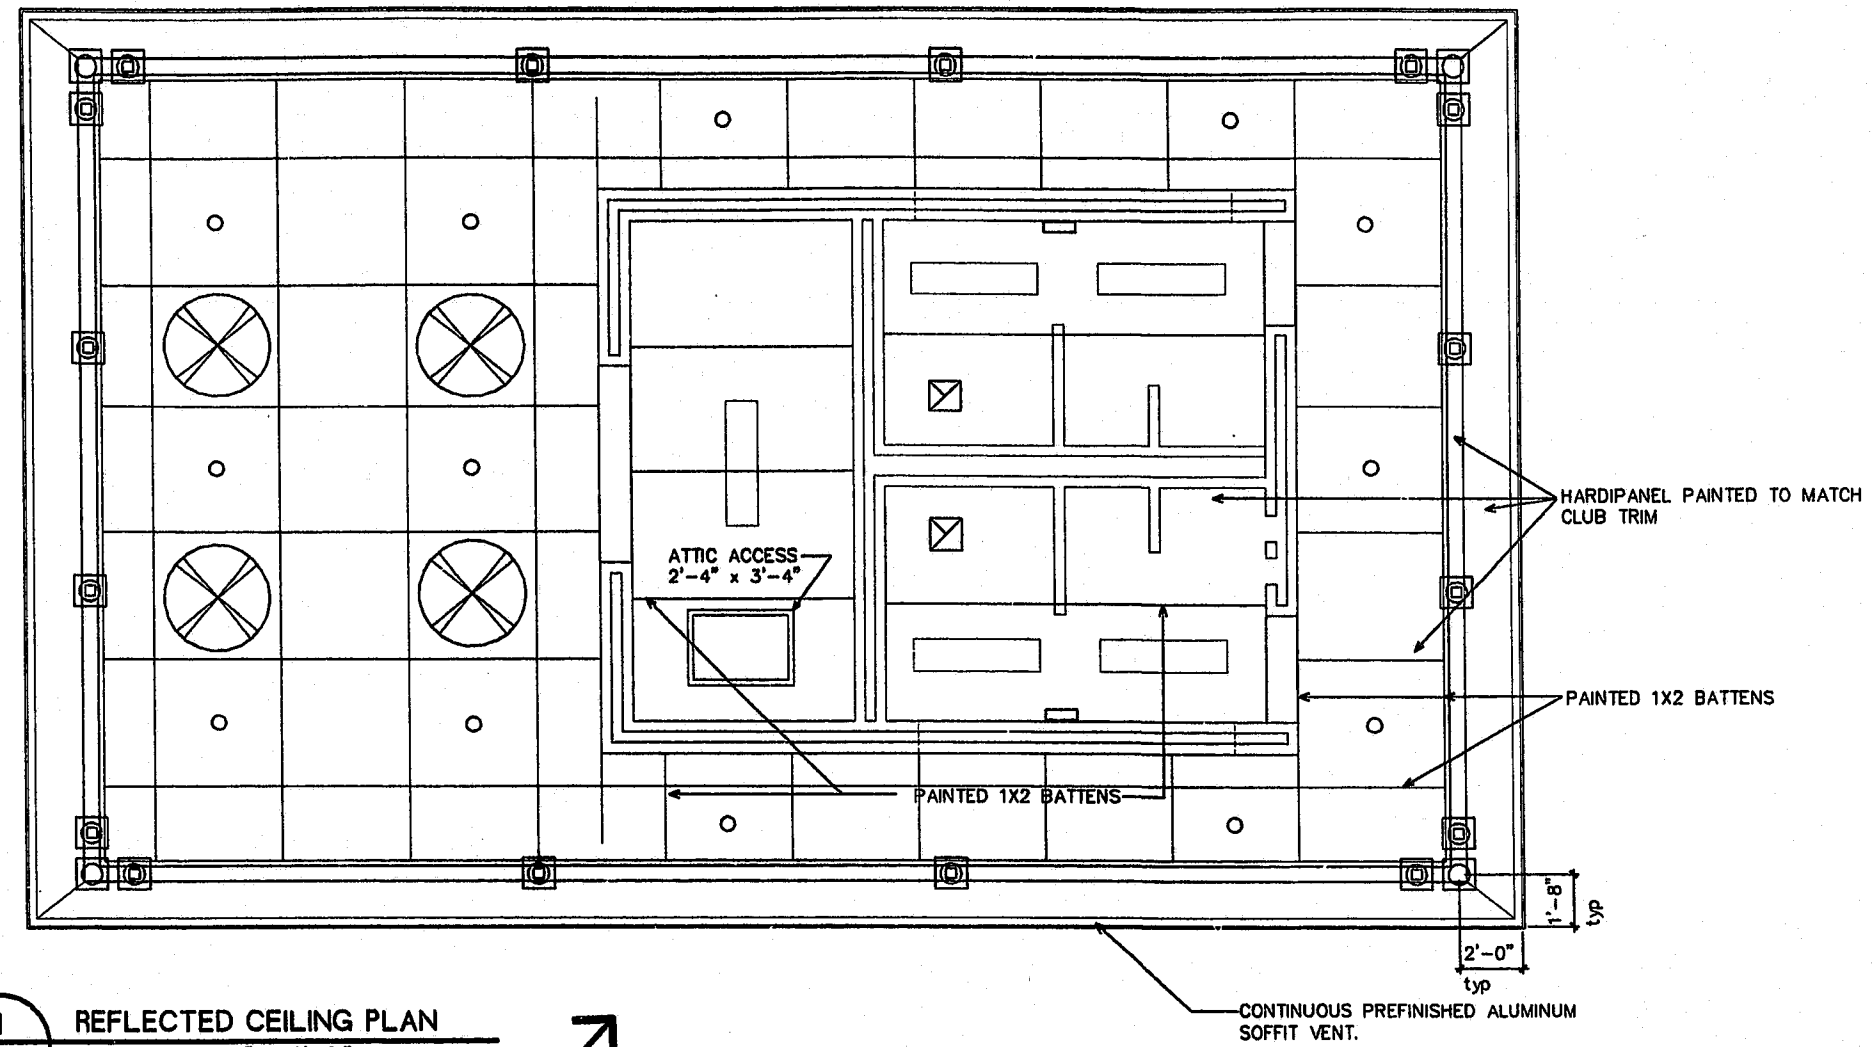

01 REFLECTED CEILING PLAN
 A4.01 SCALE: 1/4" = 1'-0"

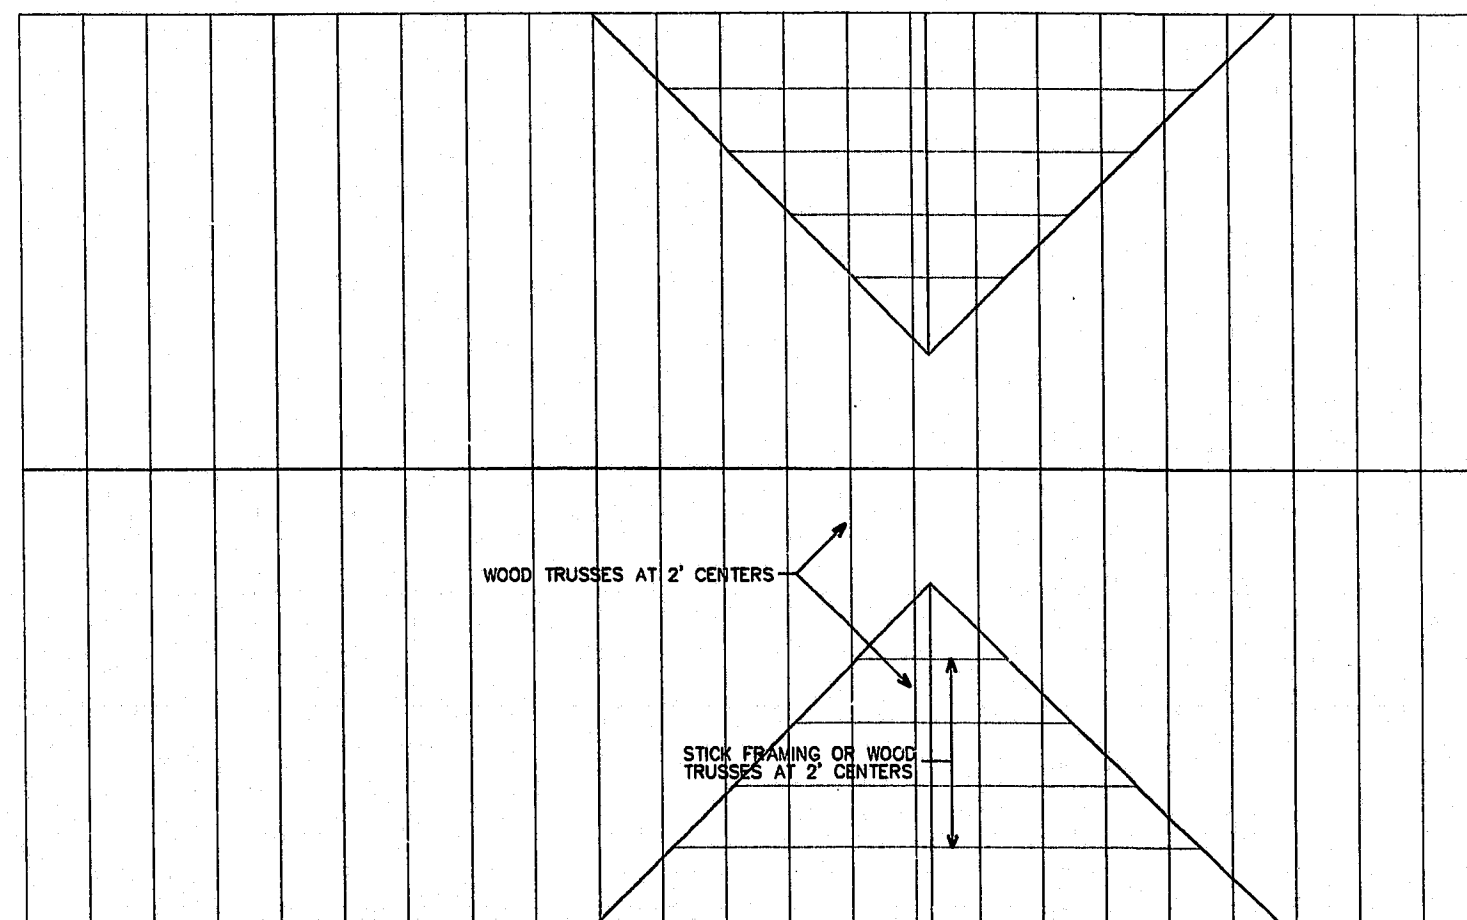

DIMENSIONS ON A1.01, A2.01, AND A2.02

02 FRAMING PLAN
 A4.01 SCALE: 1/4" = 1'-0"

99-58-201
APPROVED
 10/2/00
 10/2/00