



PROJECT No.:	DATE	DES.	DR.	CKD.
075356	01/17/18			


11301 Carmel Commons Blvd.  
 Suite 300  
 Charlotte, NC 28226  
 704.525.6284  
 FAX: 704.525.8529

**WOOLPERT**  
 ARCHITECTURAL | ENGINEERING | INTERIOR DESIGN

**SITE IMPROVEMENT PLANS**  
**WATERWALK MORRISVILLE**  
 1012 & 1016 LOWER SHILOH WAY  
 MORRISVILLE, NORTH CAROLINA

**TYPICAL SECTION & DETAILS**

CONSTRUCTION SHALL NOT START UNTIL CONSTRUCTION MANAGER INITIALIZES A SRW INSTALLATION MEETING WITH ALL PARTIES & DESIGN ENGINEER.

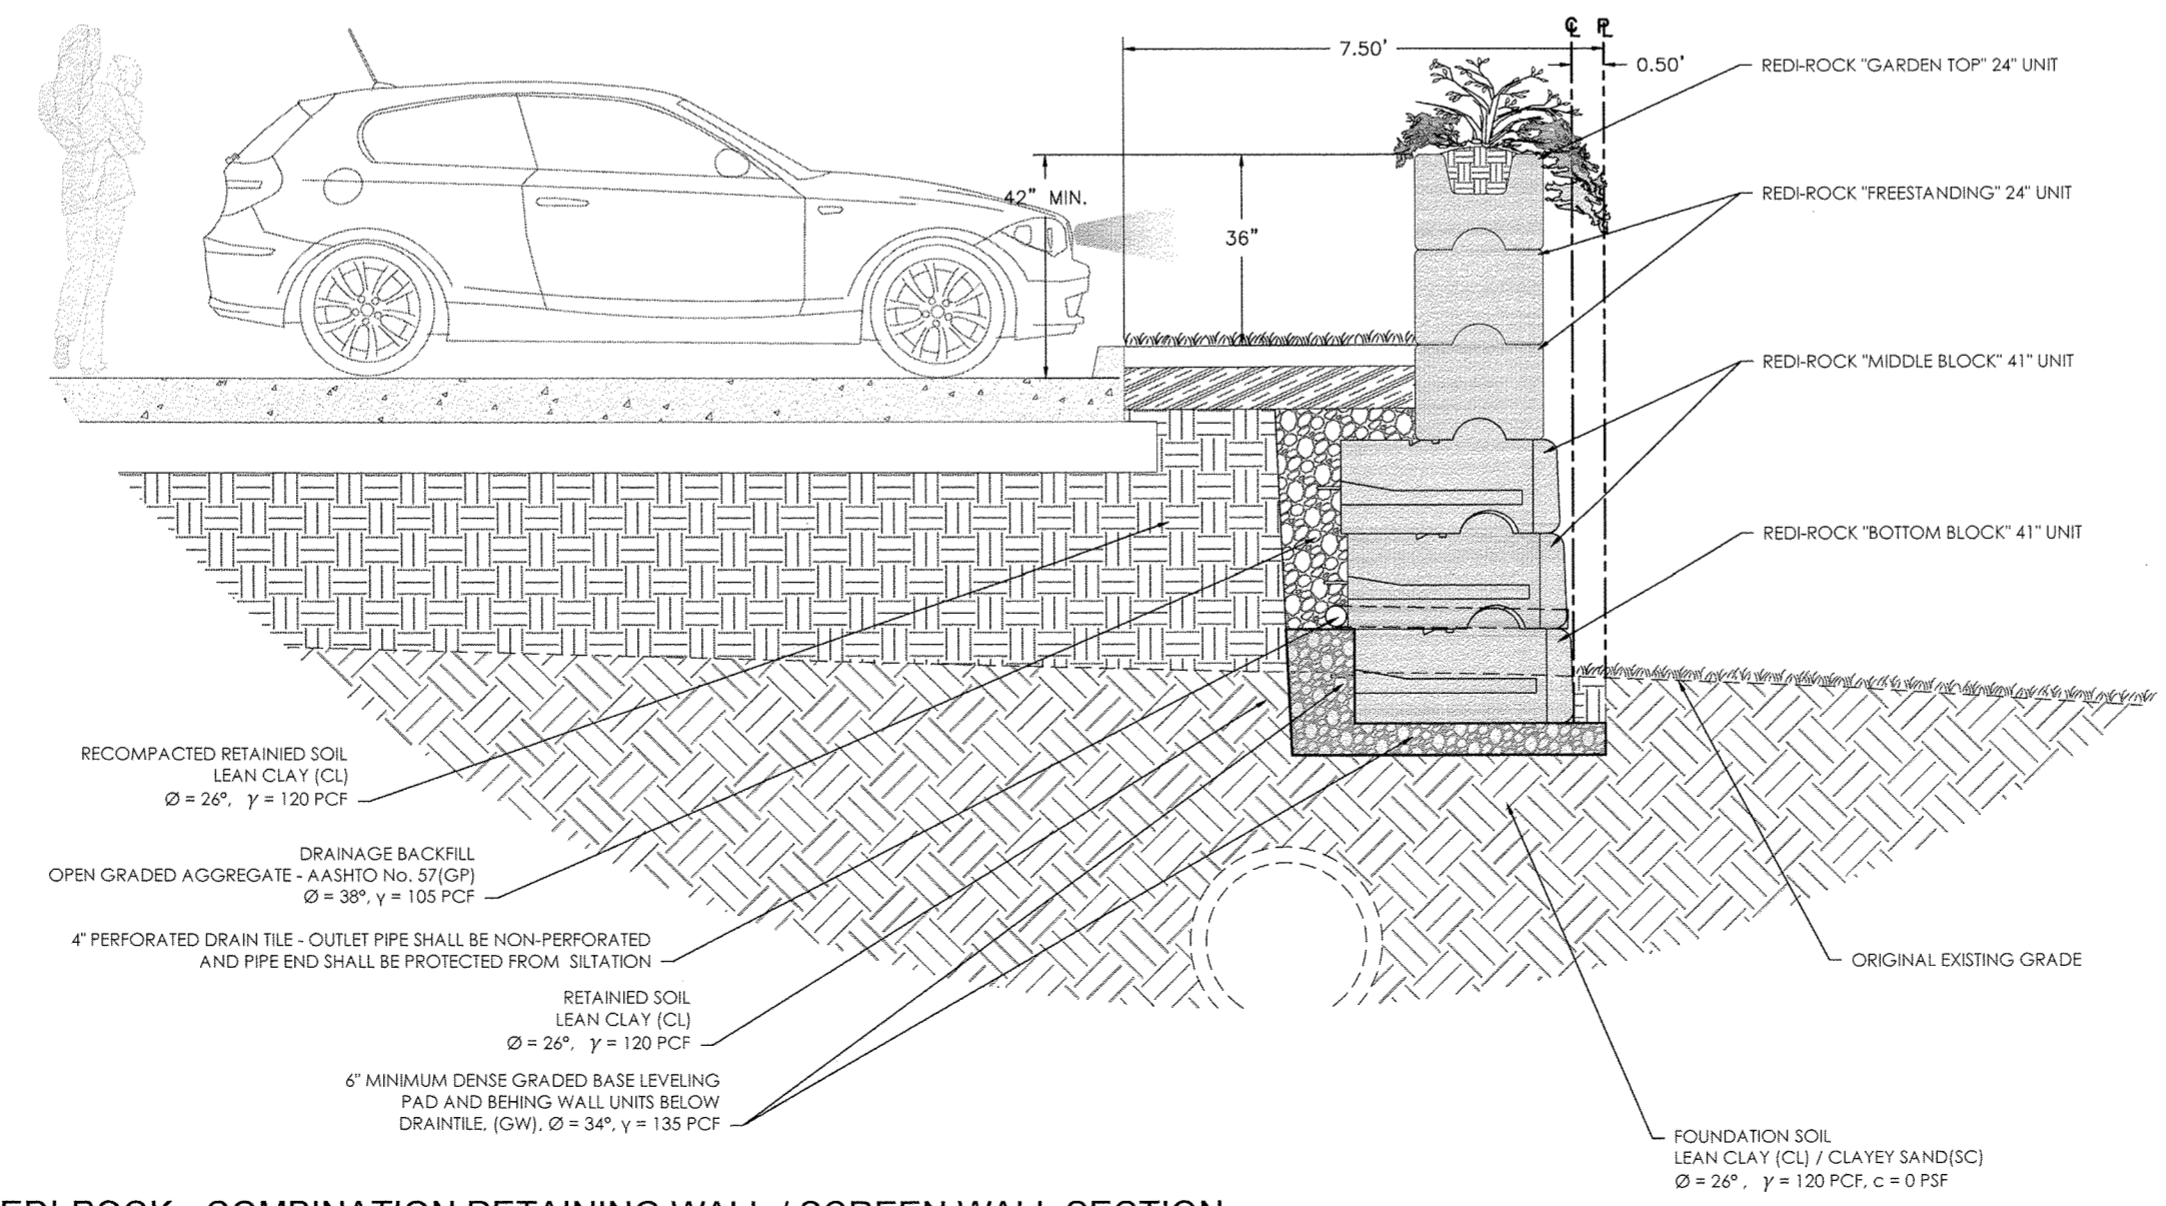

**REDI-ROCK - COMBINATION RETAINING WALL / SCREEN WALL SECTION**

SCALE: 1/2" = 1'

MORRISVILLE PROJECT # : 17-11000001 FILE # : 17-0001-S/C

Town of Morrisville  
 APPROVED FOR CONSTRUCTION

Signature: \_\_\_\_\_ Date: \_\_\_\_\_  
 Town of Morrisville, Town Engineer

Signature: *Amie R...* Date: 5/23/18  
 Town of Cary Utilities, Water and Sewer

Engineering: 5/21/18 PJP  
 Planning: 5/21/18 JLB  
 Other (specify): 5/21/18 JLB (S)

Engineering Inspection Services must be contacted (919) 463-6907 at a minimum 24 hours prior to the commencement of any construction activities.

SHEET NO.  
**R7**