



Revisions:

Proj. No.: 077730
Date: 01/18/2018
Drawn By: JY
Checked By: KE
Sheet Name:
BUILDING 2 PLANS

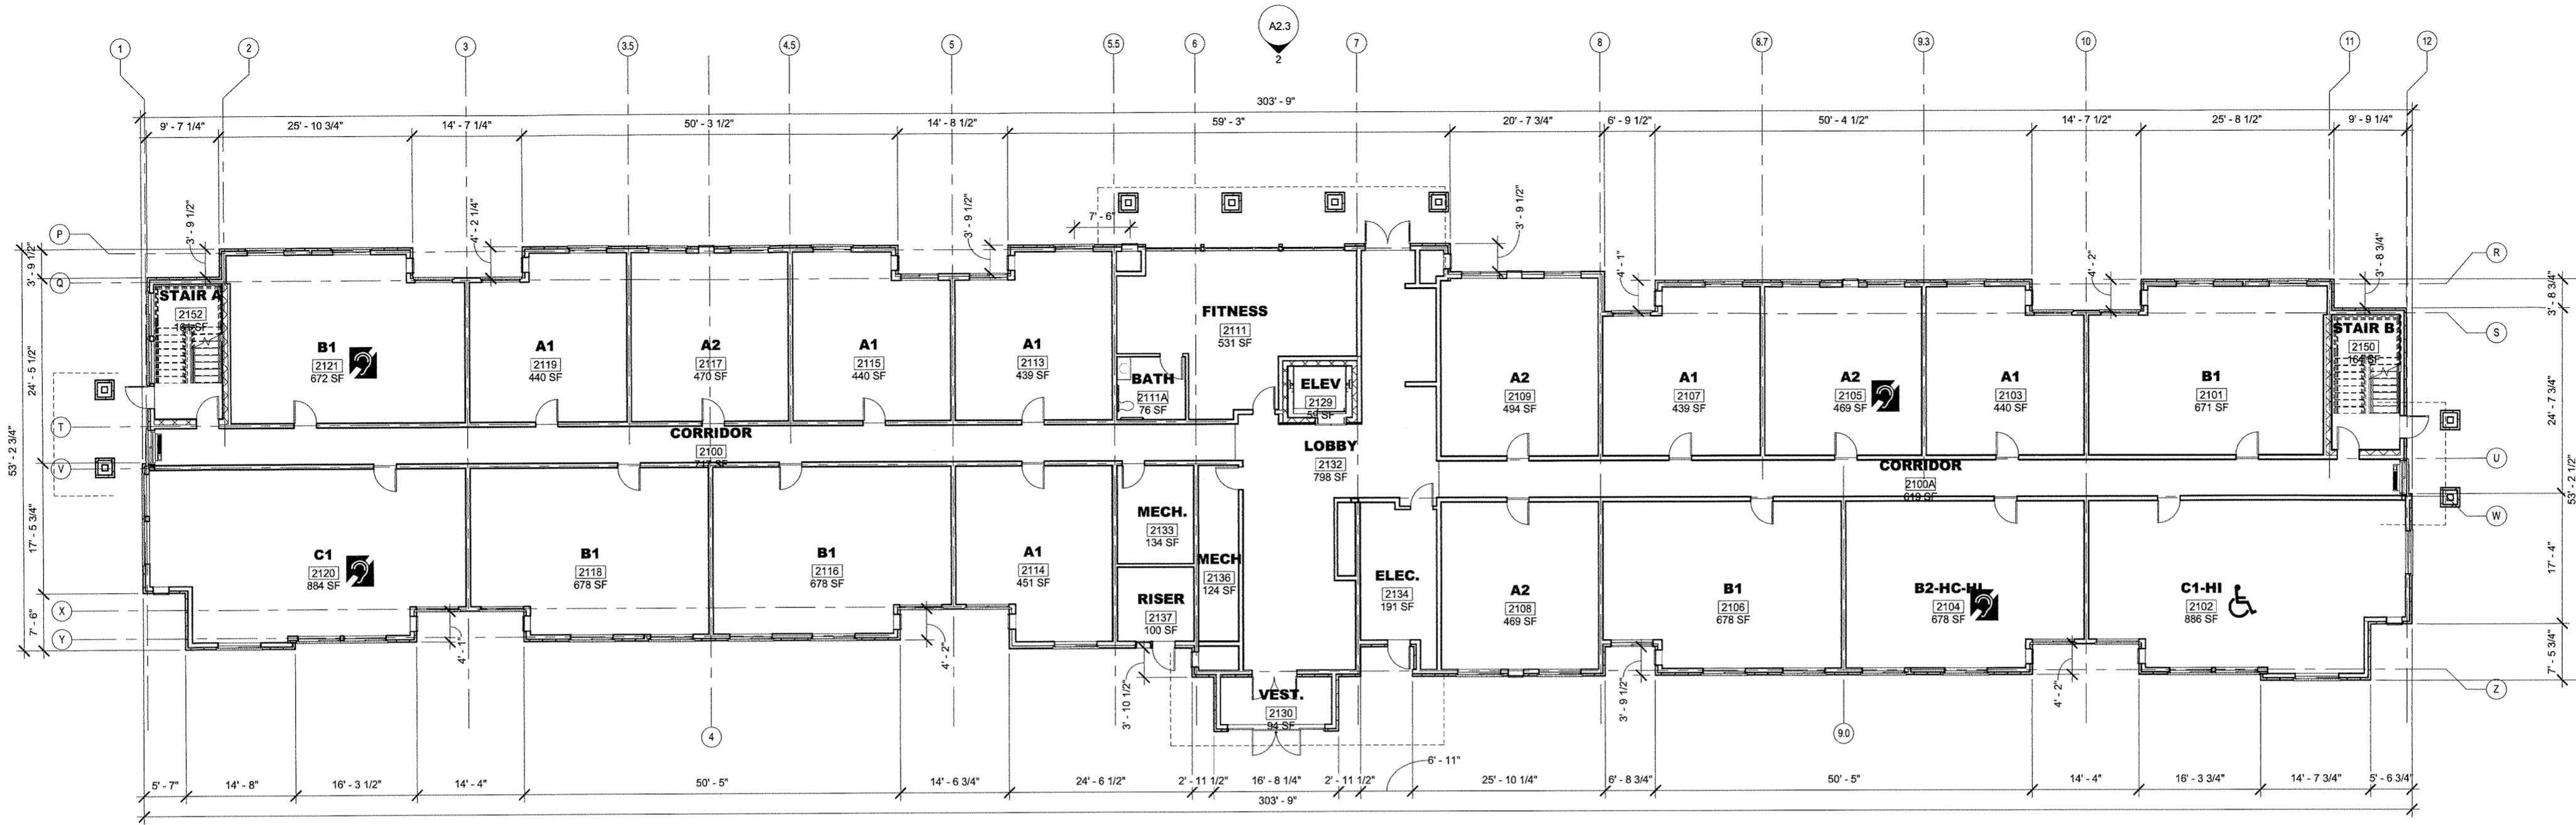

2 BUILDING 2 - FIRST FLOOR PLAN
SCALE: 3/32" = 1'-0"

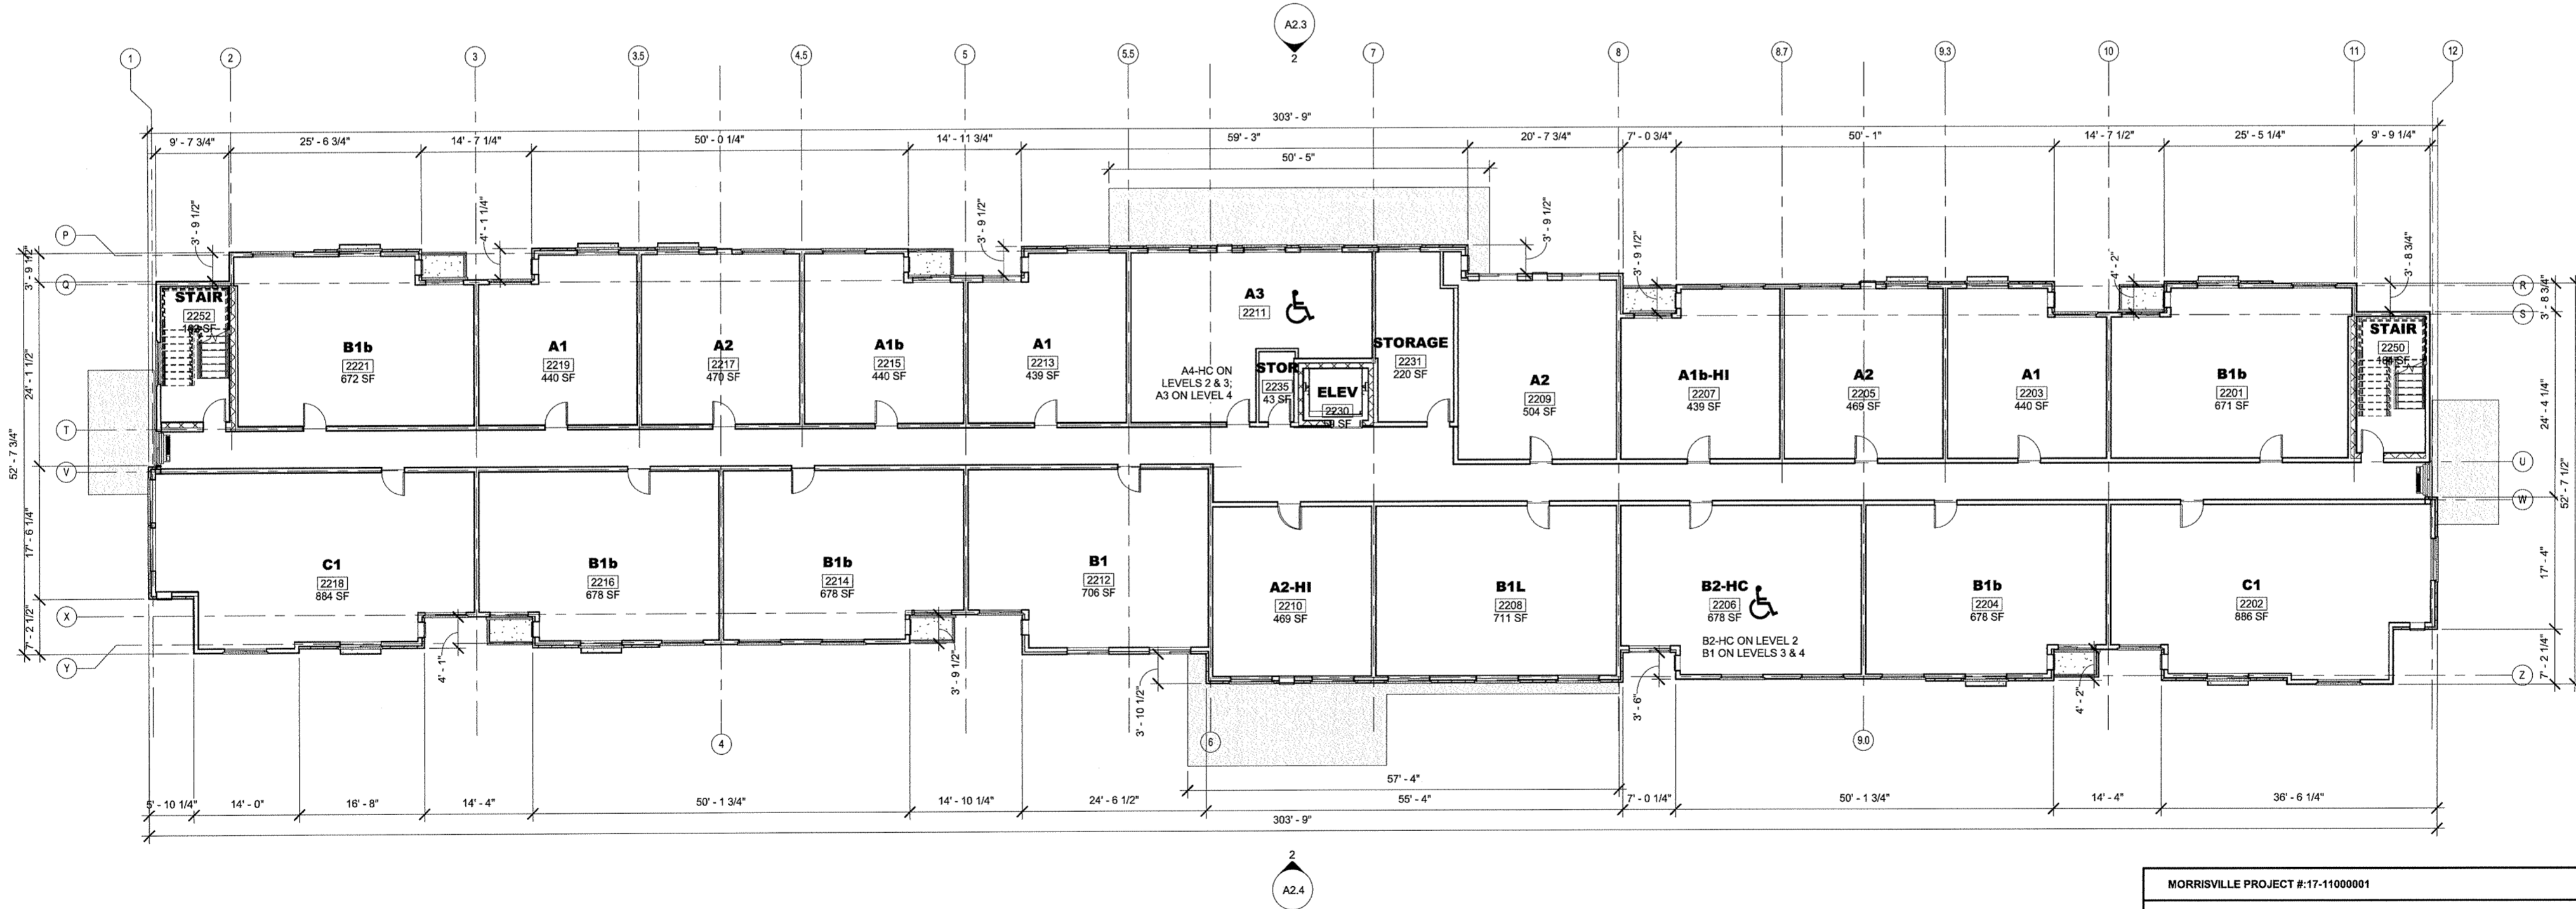

1 BUILDING 2 - TYPICAL FLOOR PLAN - SECOND THRU FOURTH
SCALE: 3/32" = 1'-0"

MORRISVILLE PROJECT #: 17-11000001		FILE #: 17-0001-SIC	
Town of Morrisville APPROVED FOR CONSTRUCTION			
Signature: <i>[Signature]</i>	Date: 5/31/18	Date/Initials	
Town of Morrisville, Town Engineer		Engineering: <i>[Signature]</i> R.P.	
		Planning: <i>[Signature]</i> A.L.	
		Other (Specify): <i>[Signature]</i> S.B.	
Signature: _____	Date: _____		
Town of Cary Utilities, Water and Sewer			
Engineering Inspection Services must be contacted (919) 463-6907 at minimum 24 hours prior to the commencement of any construction activities.			

