



Revisions:

Proj. No.: 077730  
Date: 01/18/2018  
Drawn By: JY  
Checked By: KE  
Sheet Name: ROOF PLAN

**A1.4**

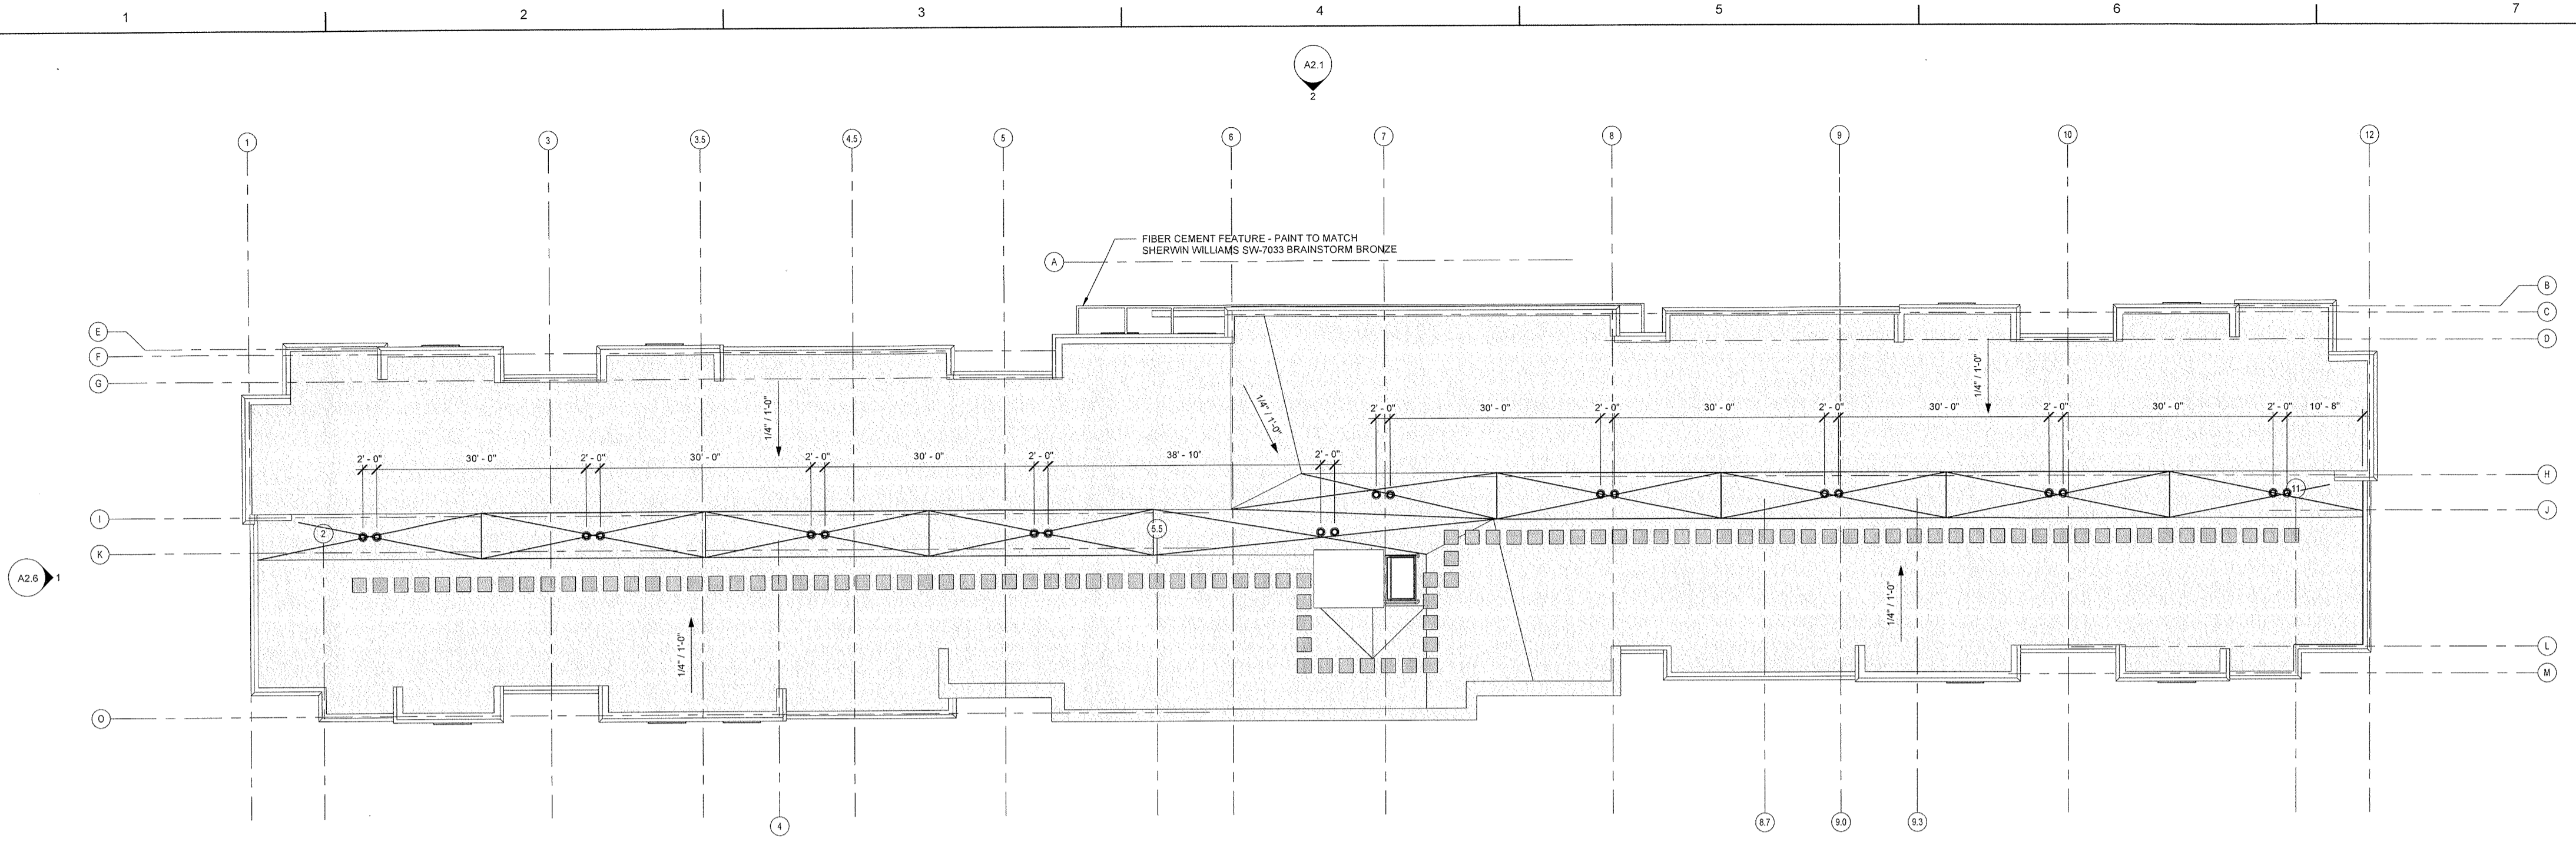


**2 BUILDING 1 - ROOF PLAN**  
SCALE: 3/32" = 1'-0"

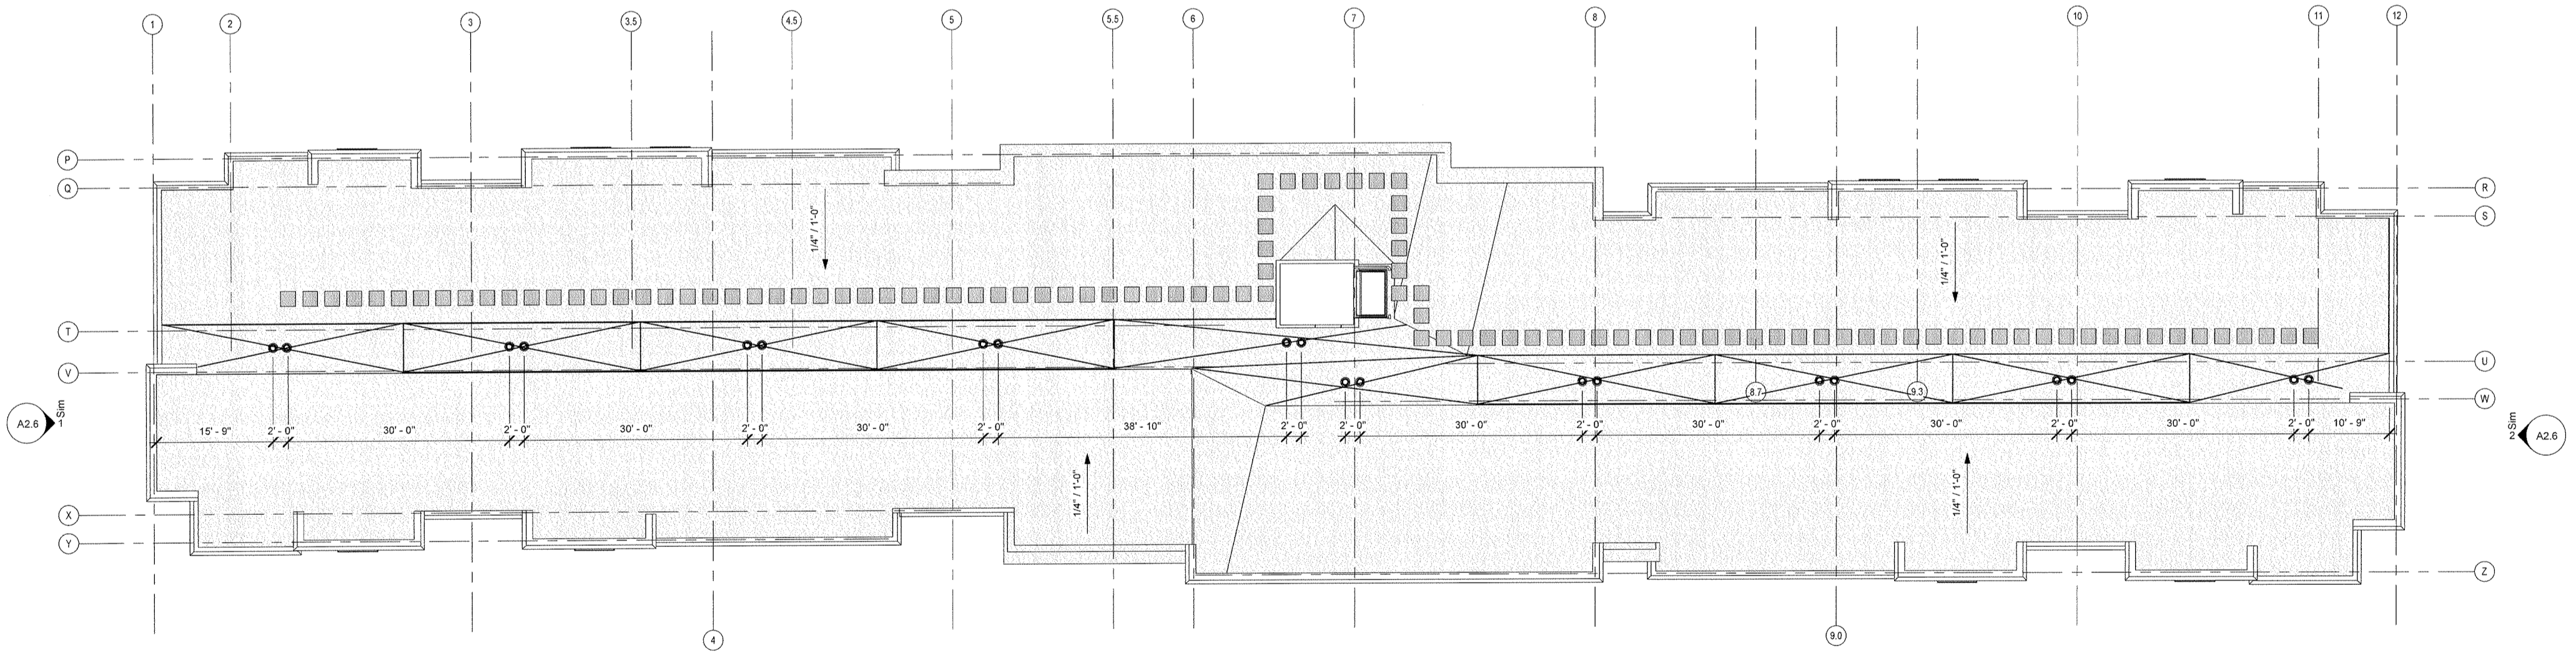

**1 BUILDING 2 - ROOF PLAN**  
SCALE: 3/32" = 1'-0"

MORRISVILLE PROJECT #17-11000001		FILE #: 17-0001-SIC	
Town of Morrisville			
APPROVED FOR CONSTRUCTION			
Signature: <i>[Signature]</i>	Date: 5/31/18	Date/Initials	
Town of Morrisville, Town Engineer		Engineering: <i>[Signature]</i> RLP	
		Planning: <i>[Signature]</i> 2/2/18	
		Other (Specify): <i>[Signature]</i> SB (62)	
Signature: _____	Date: _____	Town of Cary Utilities, Water and Sewer	
Engineering Inspection Services must be contacted (919) 463-6907 at minimum 24 hours prior to the commencement of any construction activities.			

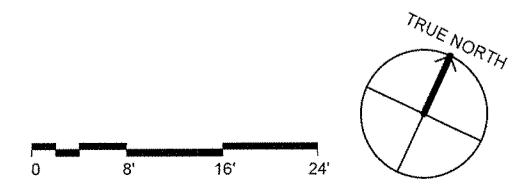

1/13/2018 2:05:23 PM BIM-360/WaterWalk\_Morrisville\MM\_Morrisville\_Site Approvals Option.rvt