



LIGHTING LEGEND

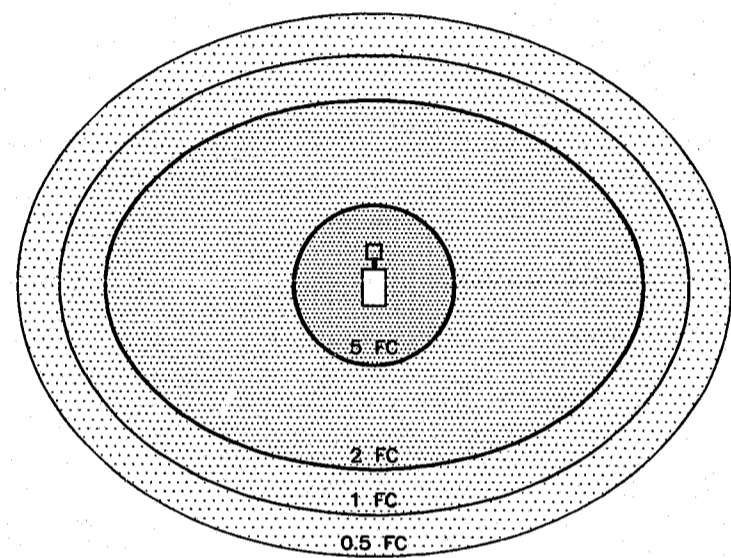

SINGLE FIXTURE

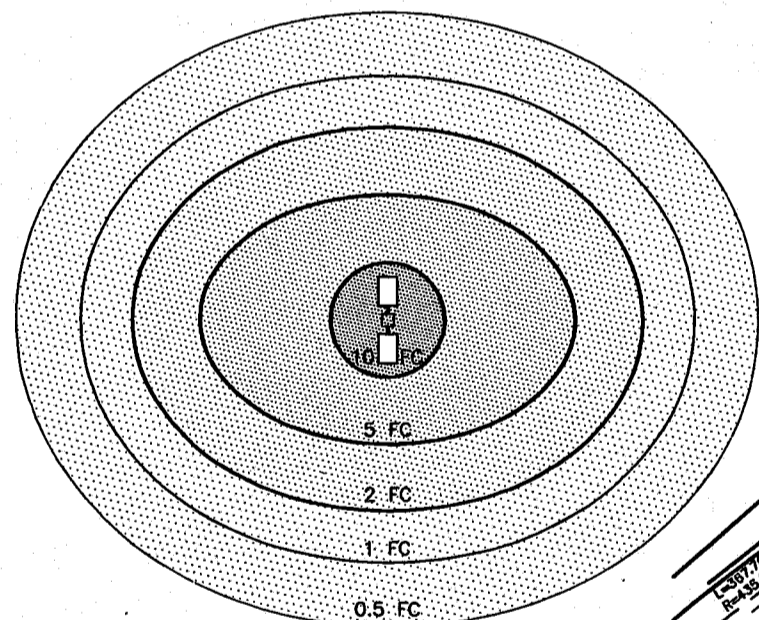

SINGLE FIXTURE


TYPICAL FOOTCANDLES

CURVE TABLE

CURVE	RADIUS	LENGTH	CHORD	BEARING
C.1	720.29'	189.63'	189.08'	N 21°29'35" W
C.2	435.54'	197.90'	196.20'	N 26°58'04" W

N/F
WAKE COUNTY
ZONED RESOURCE CONSERVATION

EX. 8" SANITARY SEWER (TOWN OF MORRISVILLE)

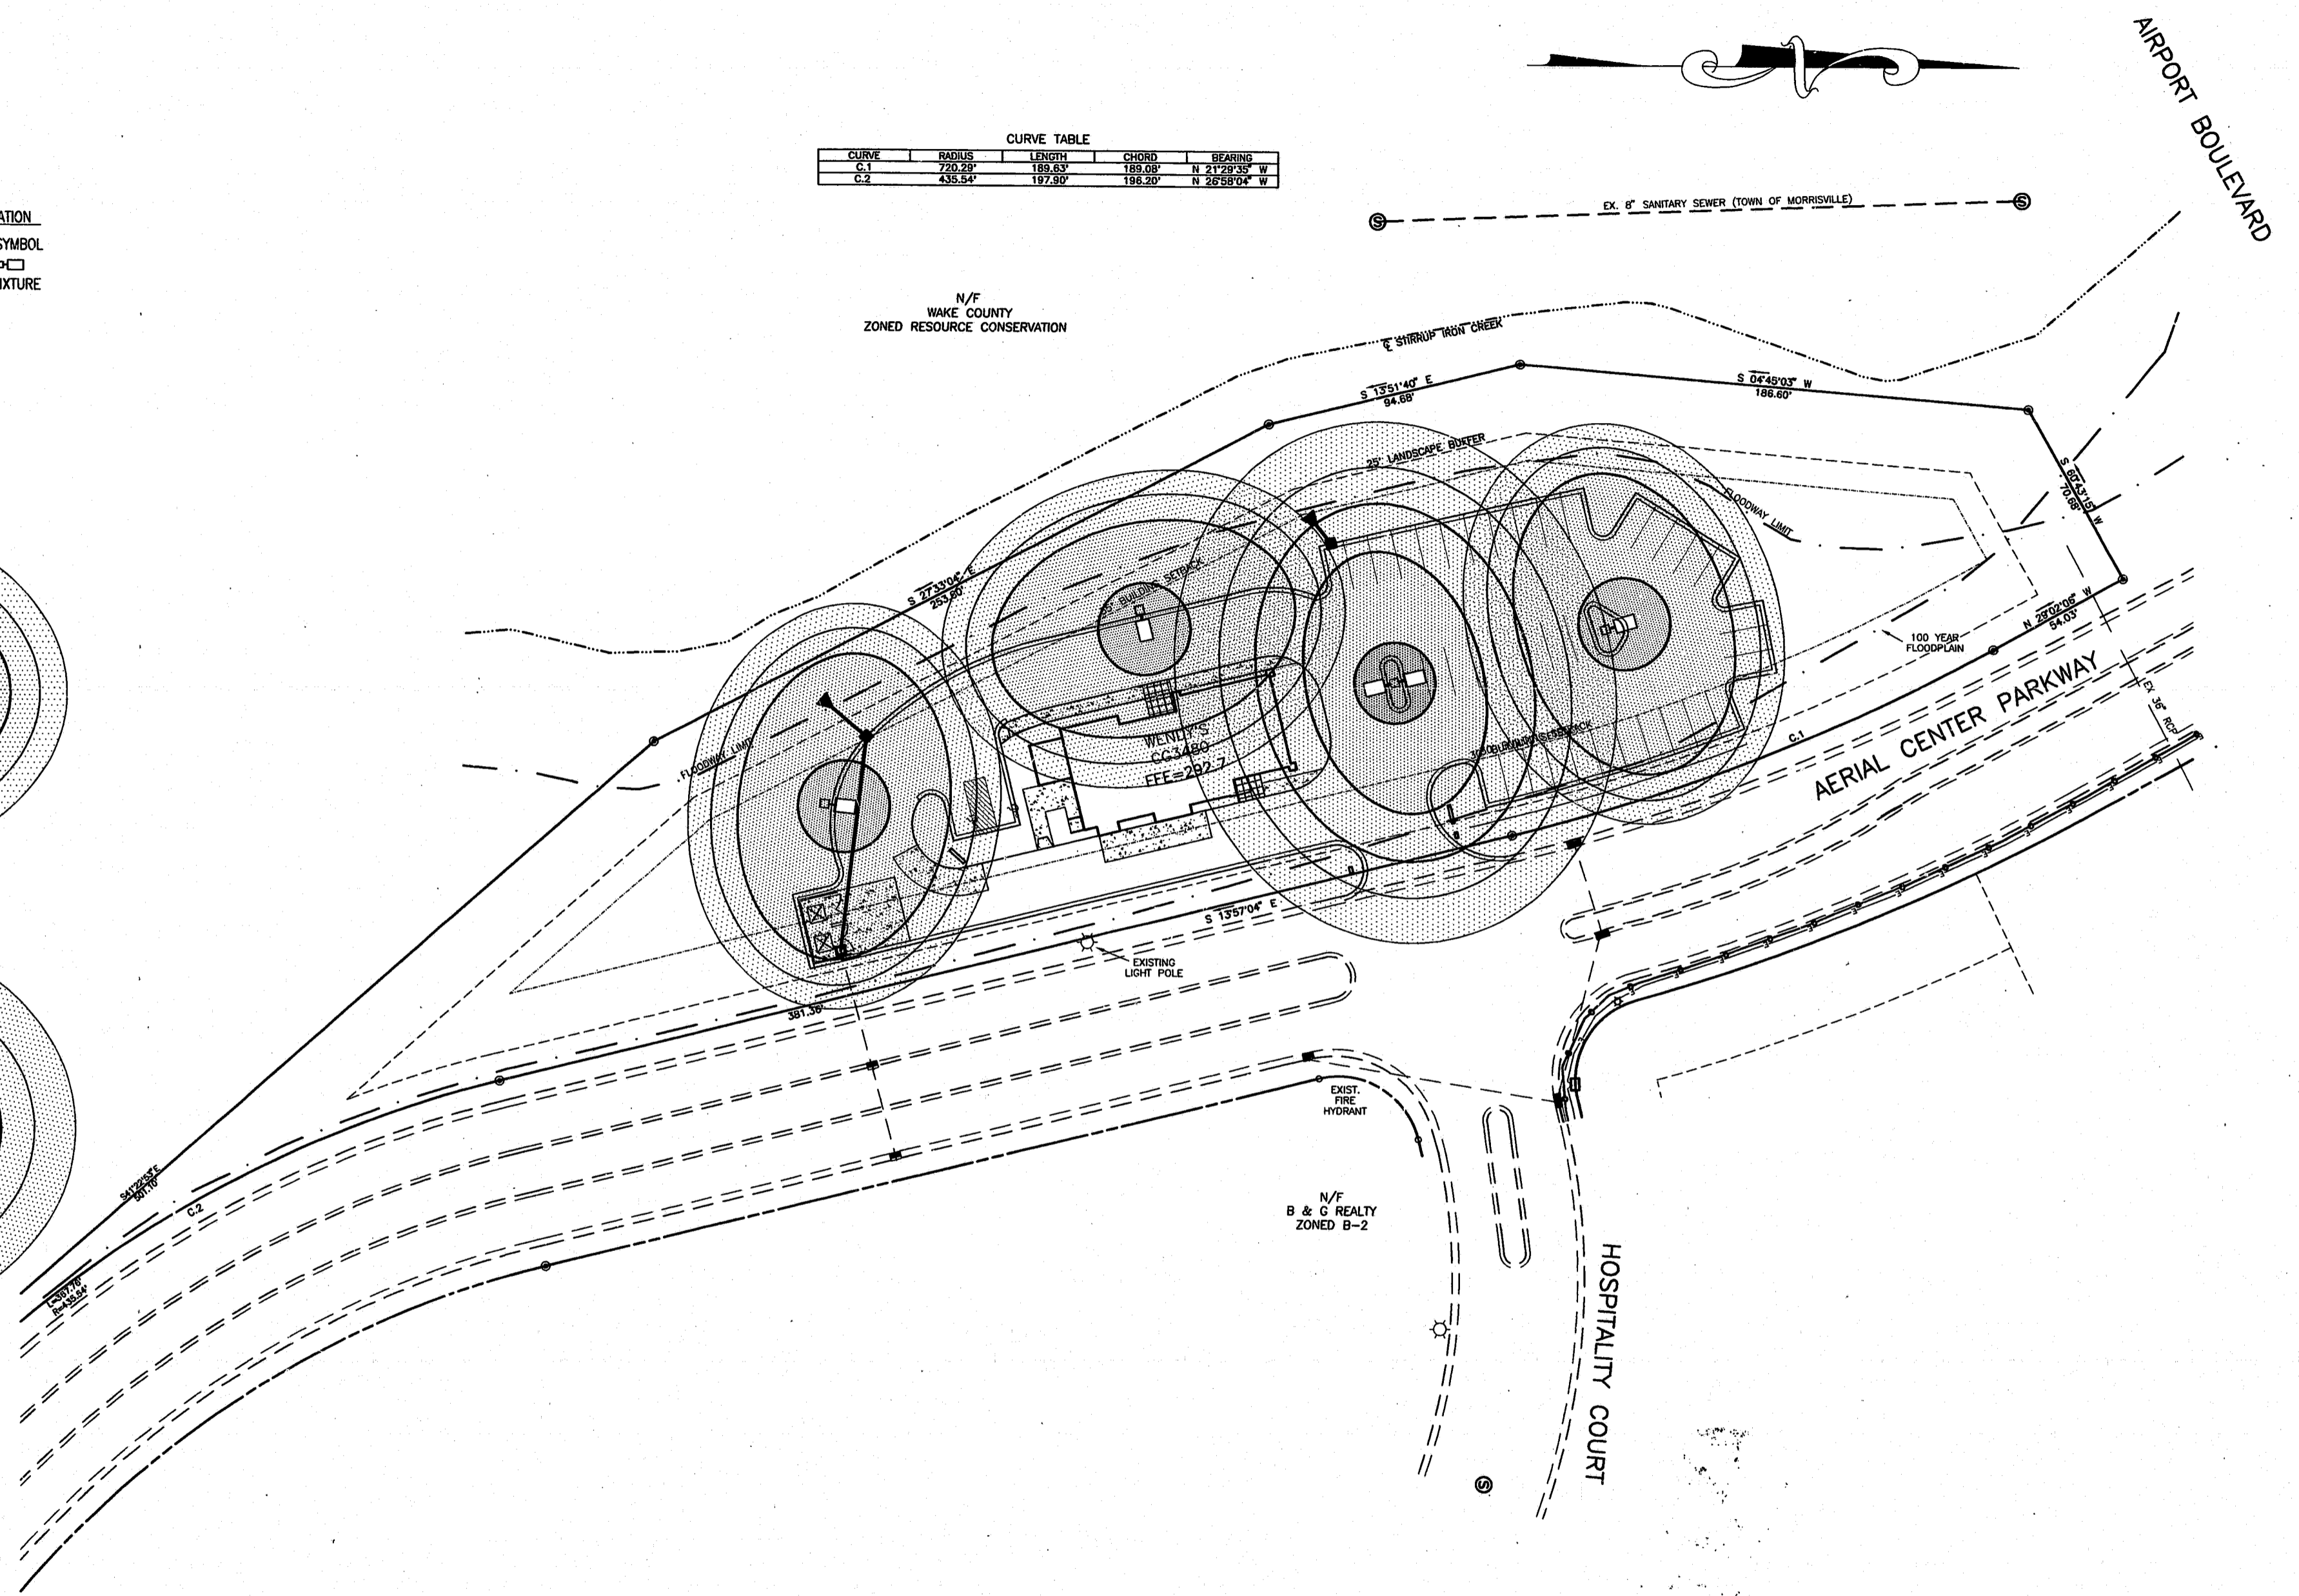

Withers & Ravenel
Engineering and Surveying, Inc.
111 MacKeran Drive, Cary NC 27511 Phone: 919-469-3340 Fax: 919-467-6008

Revisions			
No.	Description	Date	By

AIRPORT WENDY'S
CARY, NORTH CAROLINA

LIGHTING PLAN

Designer W&R	Scale 1"=30'	CAD File
Drawn By BDH	Date 10/26/95	Sheet No.
Checked By TW	Job No. 95134	4 of .