


CONCRETE CURB DETAIL

SCALE: 1" = 1'-0"

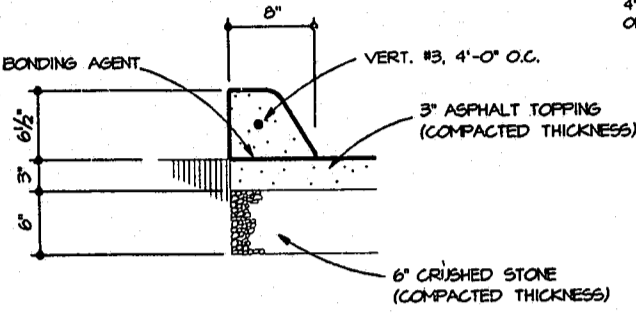

EXTRUDED CURB DETAIL

SCALE: 1" = 1'-0"


LIGHTING NOTES

1. ALL LIGHTING TO BE A 1000 WATT METAL HALIDE VERTICAL BURN FIXTURE. MULTIPLE DISTRIBUTION SHAPES (TYPES 1, 2, 3, 4) WILL BE ALLOWED TO MEET FOOTCANDLE REQUIREMENTS USING SEGMENTED OPTICS.
2. LOT IS REQUIRED TO HAVE AN AVERAGE OF 10 FOOTCANDLES AND THERE MUST BE REQUIRE TO MAINTAIN A MINIMUM OF 2 FOOTCANDLES.
3. LUMINAIRE FINISH TO BE BRONZE.
4. BALLAST SHALL BE MULTITAP 120, 208, 240, OR 277 VOLT. 480 VOLT AVAILABLE UPON REQUEST WITH A TWO (2) YEAR WARRANTY.
5. APPROVED DISTRIBUTORS:
 TRUETT LIGHTING 1-800-678-1932
 J. E. MARTIN ASSOC. 1-800-462-8235
 DESIGNED LIGHTING CONCEPTS 1-800-248-5483

SEE SHT 4 LIGHTING PLAN.


FOR PROPER INSTALLATION OF SITE LIGHTING ALWAYS USE DOUBLE NUTS AND WASHERS. THIS ASSEMBLY WILL PREVENT MOISTURE BUILD-UP IN THE POLE BY ALLOWING AIR TO CIRCULATE THROUGH THE INSIDE OF POLE. BASES MOUNTED DIRECTLY TO CONCRETE CAN CAUSE A MOISTURE BUILD-UP AND DETERIORATION OF THE POLE'S STABILITY (DO NOT GRUNT ASSEMBLY).

POLE HEIGHT = 30'-0"
 POLE DIAMETER = 5" (INCHES)
 POLE TYPE = STEEL SQUARE
 POLE FINISH = BRONZE
 BOLT SIZE = 1" (INCHES) BOLT CIRCLE
 ANCHOR BOLTS = 1"x3/8" W/DOUBLE NUT & WASHERS

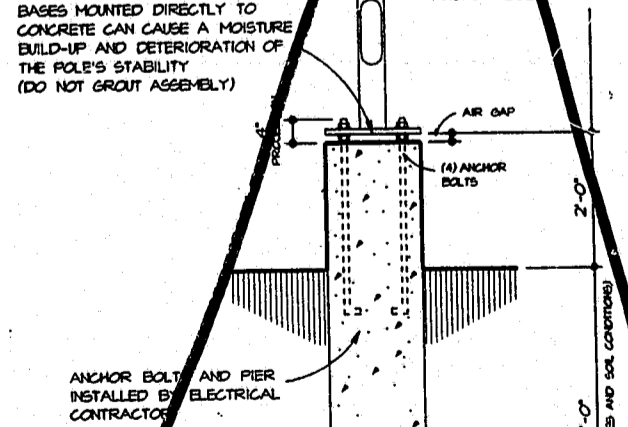

EXTERIOR POLE LIGHTS


SCALE: 1/2" = 1'-0"

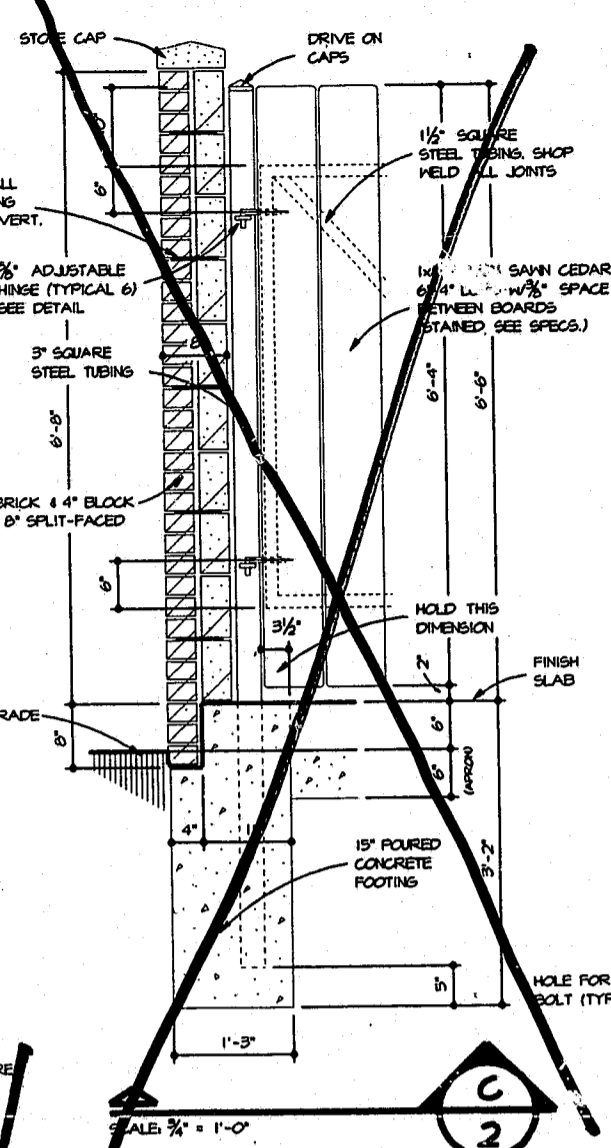

SCALE: 3/8" = 1'-0"

GATE LATCH DETAIL "A"

SCALE: 3" = 1'-0" (2 REQUIRED)

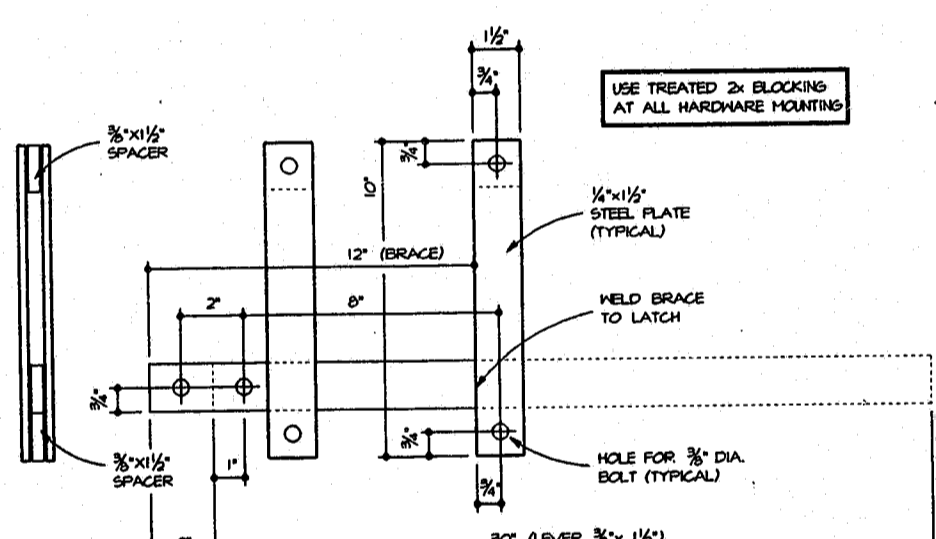


GATE LATCH DETAIL "B"

SCALE: 3" = 1'-0" (1 REQUIRED)




EXTERIOR SIGNAGE FOOTER

SCALE: 1" = 1'-0"

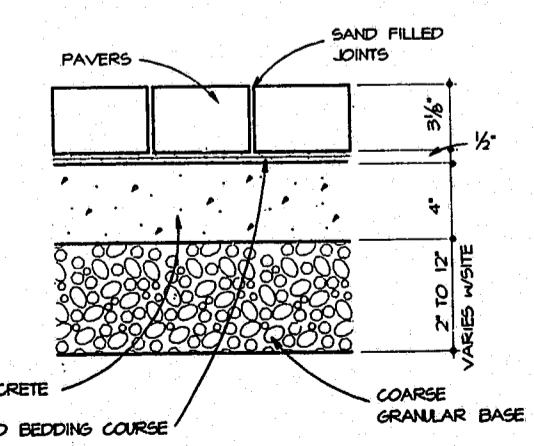

PAVER DETAIL

NO SCALE

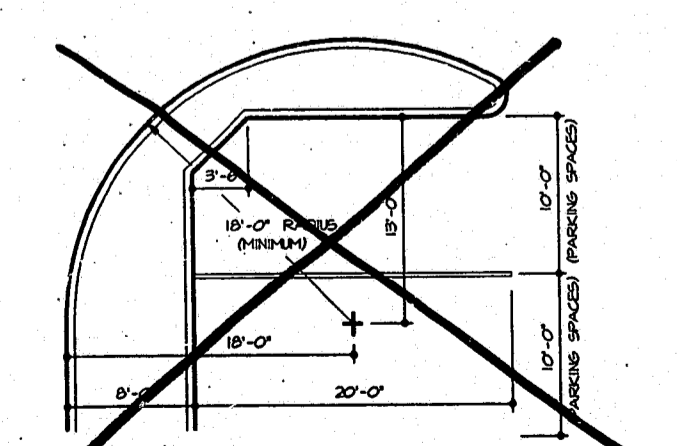


RECOMMENDED DRIVE-THRU RADIUS

SCALE: 1/4" = 1'-0"

STANDARD TRASH ENCLOSURE PLAN

SCALE: 3/8" = 1'-0"

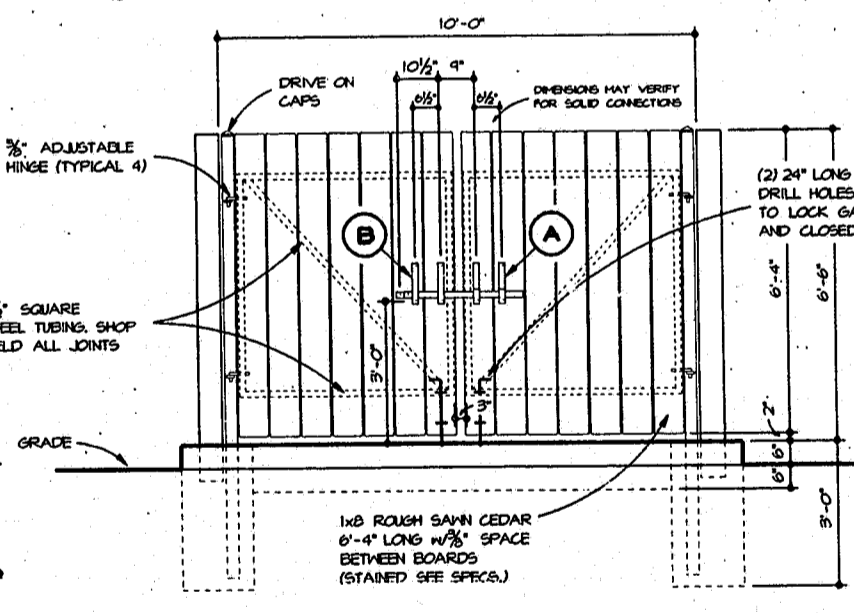


TYPICAL FRONT ELEVATION

SCALE: 3/8" = 1'-0"


OPTIONAL TRASH ENCLOSURE PLAN

SCALE: 3/8" = 1'-0"

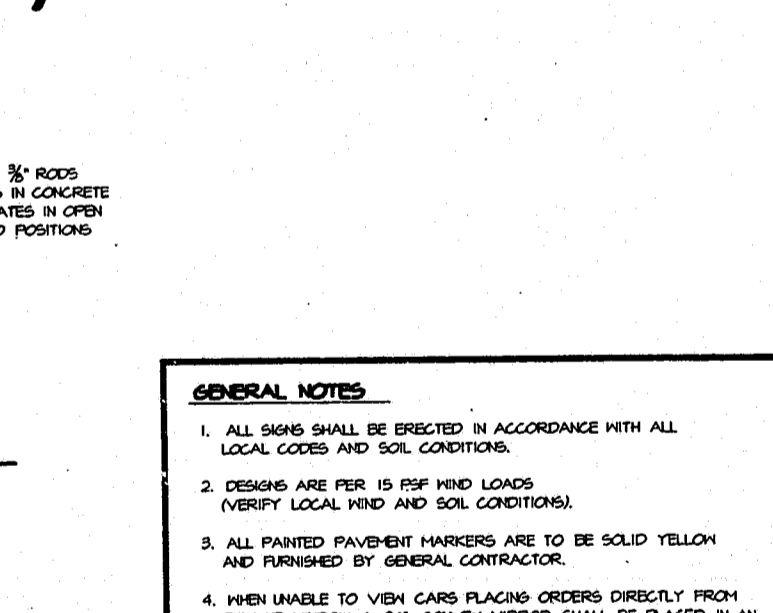

GENERAL NOTES


1. ALL SIGNS SHALL BE ERECTED IN ACCORDANCE WITH ALL LOCAL CODES AND SOIL CONDITIONS.
2. DESIGNS ARE PER 15 PSF WIND LOADS (VERIFY LOCAL WIND AND SOIL CONDITIONS).
3. ALL PAINTED PAVEMENT MARKERS ARE TO BE SOLID YELLOW AND FURNISHED BY GENERAL CONTRACTOR.
4. WHEN UNABLE TO VIEW CARS PLACING ORDERS DIRECTLY FROM PICK-UP WINDOW A 24" CONVEX MIRROR SHALL BE PLACED IN AN APPROPRIATE LOCATION TO VIEW CUSTOMERS AT ORDER STATION.

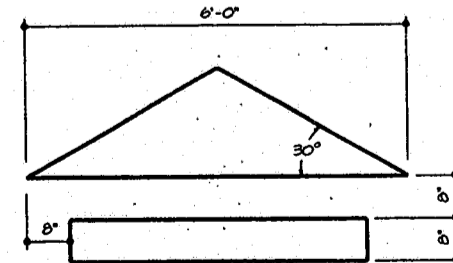

PICK-UP WINDOW

PAVEMENT MARKER DETAILS

SCALE: 1/2" = 1'-0"

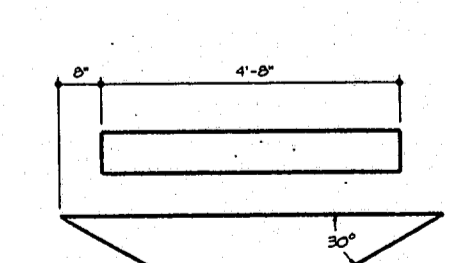

EXIT ONLY

0-DEC-1981 (REV)

NO.	DATE	REVISIONS	BY	DATE
1	1-2-85	GENERAL PLAN REVISION 15	JH	
2	8-20-85	GENERAL PLAN MAINTENANCE	JH	
3	12-6-85	REVISIONS FOR CARY, NORTH CAROLINA	JH	

SCALE: SHOWN

1-2-85	JH	PLAT
1-2-85	JH	PLAT
8-20-85	JH	PLAT
12-6-85	JH	PLAT

Wendy's
 Wendy's Old Fashioned Hamburgers

SITE DETAILS

PRELIMINARY BIDDING CONSTRUCTION

WENDY'S ASPIRANT BLVD. CARY, NORTH CAROLINA
 WENDY'S TEMPORARY NO. 6524 BRICK/FASCIA BUILDING

PLAN No. (Revision #5)
Cg-series CENTRAL GRILLE

JOB No.	SHEET No.
65234	10